
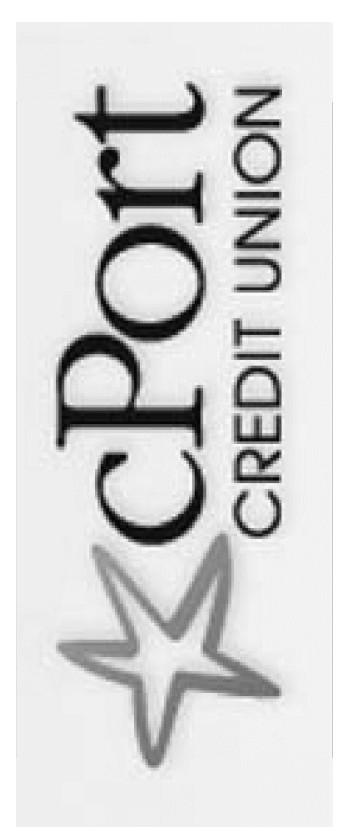


PROGRESS PRINT
NOT FOR CONSTRUCTION

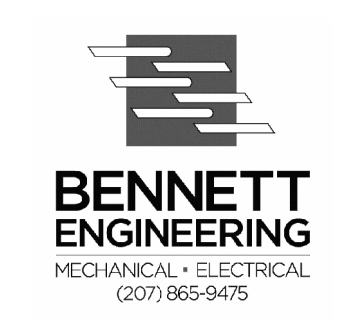

REVISIONS		
#	DATE	DESCRIPTION
1	8/19/11	Revised 90% Review Set

DATE:	08.19.11
PROJECT #:	090609
DRAWN BY:	twg
CHECKED BY:
DRAWING SCALE:	1/4"=1'-0"

SHEET TITLE
SECOND FLOOR LIGHTING PLAN

E201

© COPYRIGHT 1985-2011
REPRODUCTION OR RELEASE OF THIS
DOCUMENT WITHOUT WRITTEN
PERMISSION OF GAWRON TURGEON
ARCHITECTS IS PROHIBITED.