




THIRD FLOOR PLAN
SCALE: 1/8" = 1'-0"

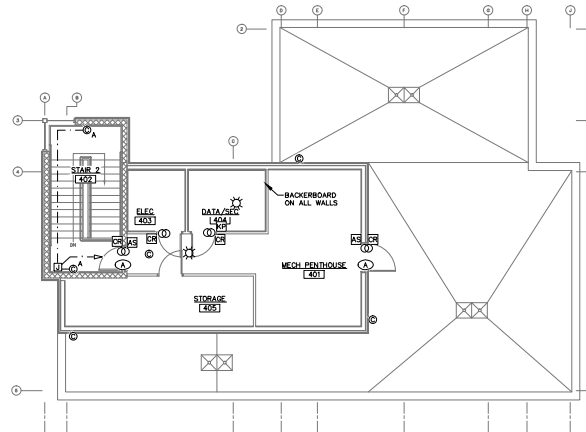

MECHANICAL PENTHOUSE PLAN
SCALE: 1/8" = 1'-0"

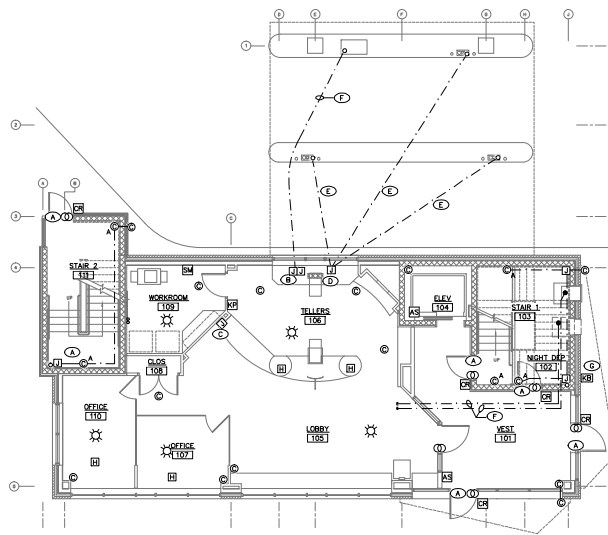

FIRST FLOOR PLAN
SCALE: 1/8" = 1'-0"

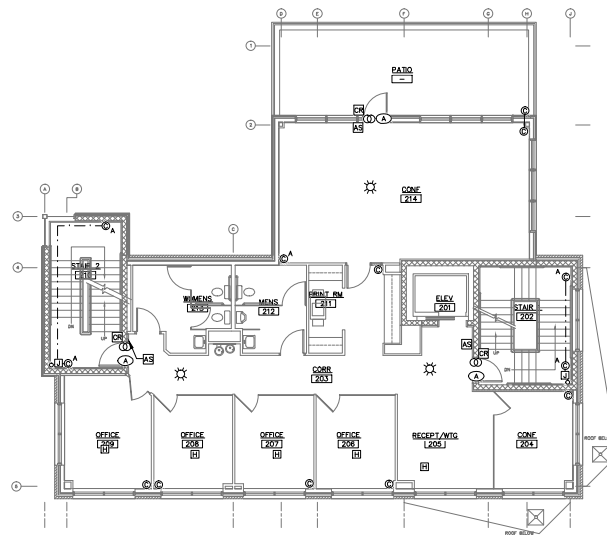


SECOND FLOOR PLAN
SCALE: 1/8" = 1'-0"

- GENERAL NOTES**
- ACCESS CONTROL, SECURITY DEVICES AND WIRING PROVIDED BY SECURITY VENDOR.
 - E.C. TO PROVIDE CONDUITS, JUNCTION BOXES AND BACKBOXES. COORDINATE WITH SECURITY VENDOR.
 - PROVIDE PULL STRINGS IN ALL EMPTY CONDUITS.

- KEYED NOTES**
- PROVIDE 1" C FROM INSIDE DOOR FRAME TO ABOVE CEILING.
 - PROVIDE 3 JUNCTION BOXES UNDERCOUNTER FOR POWER, SECURITY, AND DATA.
 - PROVIDE JUNCTION BOX BELOW COUNTER WITH CONDUIT STUBBED UP ABOVE THE CEILING.
 - PROVIDE JUNCTION BOX FOR AUDIO, COORDINATE WITH SECURITY VENDOR.
 - PROVIDE 3/4" C SCH 80 PVC TO AUDIO J-BOX AND VAV, COORDINATE WITH SECURITY VENDOR.
 - PROVIDE 3-3/4" C FOR POWER, DATA AND SECURITY.
 - PROVIDE ALARM CONTACTS FOR KNOX BOX.

 - LEGEND**
- Ⓜ CAMD READER - PROVIDE BACKBOX AT LATCH HEIGHT, 3/4" C TO ABOVE CEILING.
 - Ⓜ ARMING STATION - PROVIDE BACKBOX AT 48" AFF, 3/4" C TO ABOVE CEILING.
 - Ⓜ DOOR CONTACTS - PROVIDE JUNCTION BOX LATCH SIDE, 3/4" C TO ABOVE CEILING.
 - Ⓜ MOTION SENSOR - PROVIDE BACKBOX.
 - Ⓜ IP CAMERA - PROVIDE BACKBOX, 3/4" C TO ABOVE CEILING.
 - Ⓜ ANALOG CAMERA - PROVIDE SURFACE BACKBOX, 3/4" C TO ABOVE CEILING AS INDICATED.
 - Ⓜ KEYPAD - PROVIDE BACKBOX AT 48", 3/4" C TO ABOVE CEILING.
 - Ⓜ WIRELESS HOLD-UP BUTTON
 - Ⓜ SECURITY MONITOR - AT 80" AFF PROVIDE DUPLEX RECEPTACLE AND JUNCTION BOX FOR VIDEO WIRING, 3/4" C TO ABOVE CEILING, SEE EPI01 FOR POWER WIRING.



Hewlett & Whitney
ENGINEERS & DESIGNERS
TECHNOLOGY & SECURITY SOLUTIONS
161 MAIN STREET WINTHROP, MAINE
Tel 207.637.9900 Fax 207.637.7504
PLOT DATE: Jul 21, 2015

NO.	DATE	DESCRIPTION

ISSUE FOR CONSTRUCTION
07.22.15

TAC Architectural Group Inc.



BSB - MARGINAL WAY
PORTLAND, MAINE

PROJECT NO: 1502
CAD DWG FILE: Elec-Plans.dwg
DRAWN BY: ELP/COH
CHK'D BY: COH
COPYRIGHT: 2015

ACCESS CONTROL AND SECURITY PLANS

HEY102