



THIRD FLOOR PLAN

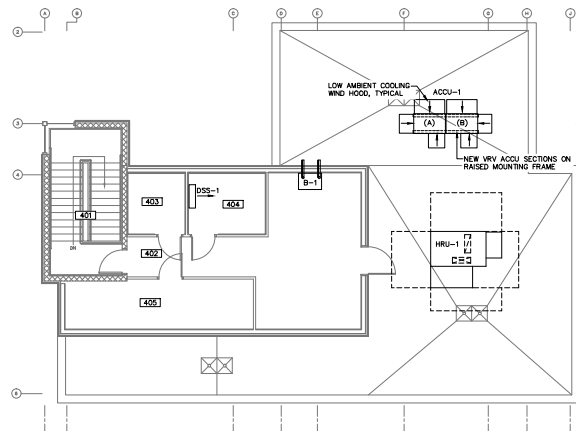


MECHANICAL PENTHOUSE PLAN

GENERAL HEATING NOTES

1. MINIMUM PIPE SIZE = 3/4".
2. LOCATE CONTROL VALVES FOR HEATING SYSTEM TO CORRESPOND WITH VRV SYSTEM ZONING

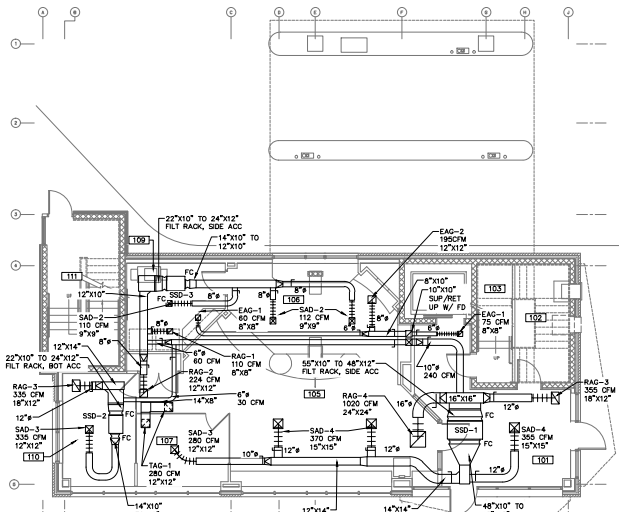

FIRST FLOOR PLAN

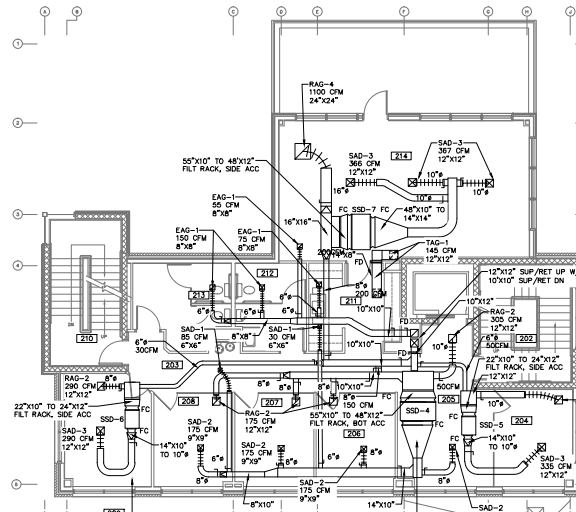

SECOND FLOOR PLAN

SCALE: 1/8" = 1'-0"




161 MAIN STREET WINTHROP, MAINE  
Tel 207.637.7400 Fax 207.637.7534

PLOT DATE: Jul 21, 2015

NO.	DATE	DESCRIPTION
ISSUE FOR CONSTRUCTION		
07.22.15		

 ISSUE FOR CONSTRUCTION  
07.22.15



BSB - MARGINAL WAY

PORTLAND, MAINE

PROJECT NO: 1502  
CAD DWG FILE: HVAC-Plans.dwg  
DRAWN BY: GRL, KWW  
CHK'D BY: KWW  
COPYRIGHT: 2015

SHEET TITLE  
HVAC DUCTWORK PLANS

H102