


- FINISH PLAN NOTES:**
- REFER TO ARCHITECTURAL ABBREVIATIONS ON SHEET G1002 FOR ALL ABBREVIATIONS SHOWN.
 - ABBREVIATIONS ON AF SHEETS INCLUDE:
APC: ACOUSTIC PANEL CEILING
CG: CORNER GUARD
CPT: CARPET
LVT: LUXURY VINYL TILE
MB: MARKERBOARD
PLAM: PLASTIC LAMINATE
PT: PAINT
VCT: VINYL COMPOSITION TILE
SS: SOLID SURFACE
WD: WOOD
WB: RESILIENT WALL BASE
 - REFER TO FINISH SCHEDULES ON SHEET AF601 FOR MORE INFORMATION.
 - REFER TO SPECIFICATION FOR PRODUCT INFORMATION.
 - REFER TO REFLECTED CEILING PLANS ON SHEETS AE106-AE108 FOR MORE INFORMATION.
 - REFER TO INTERIOR ELEVATIONS ON SHEETS AE201.
 - WALL, FLOOR, AND BASE FINISH TRANSITIONS ARE TO OCCUR ON INSIDE CORNERS U.N.O. VERIFY QUESTIONABLE FIELD CONDITIONS WITH ARCHITECT. REFER TO AF501 FOR TRANSITION DETAILS.
 - INSTALL NEW TRANSITION STRIPS WHERE NEW FLOORING MATERIAL ABUTS DISSIMILAR FLOORING MATERIAL. FLOORING CONTRACTOR TO VERIFY LOCATION AND STYLE OF FLOORING TRANSITION STRIPS BEFORE INSTALLATION. CENTERLINE OF FLOORING TRANSITIONS BETWEEN ROOMS TO OCCUR AT CENTERLINE OF DOOR PANEL, U.N.O.

GENERAL CEILING PLAN NOTES



- REFER TO SHEET G1002 FOR ALL ABBREVIATIONS.
- ALL HEIGHTS GIVEN ARE FROM FINISHED FLOOR OF BUILDING.
- CONTRACTOR TO VERIFY LOCATION OF MAIN CEILING TEE'S BEFORE PROCEEDING WITH FIXTURE INSTALLATION NOTIFY ARCHITECT OF INTERFERENCES.
- NOTIFY ARCHITECT OF ANY DISCREPANCIES BETWEEN ARCHITECTURAL REFLECTED CEILING PLANS AND ELECTRICAL LIGHTING PLANS PRIOR TO CONSTRUCTION.
- REFER TO ELECTRICAL PLANS FOR LOCATION OF STROBES AND EXIT SIGNS.
- ALL CEILING GRILLES, TRIM EDGES, AND SLOT DIFFUSERS TO MATCH ADJACENT CEILING COLOR.
- ALL SPRINKLER HEADS TO OCCUR AT CENTER OF TILE. AT 3rd AND 4th FLOOR, SPRINKLER HEADS TO REMAIN IN PLACE EXCEPT AS REQUIRED TO MOVE TO AT LEAST 4" FROM NEW CEILING GRID.
- LAYOUT TILES AS SHOWN IN REFLECTED CEILING PLAN. ALL CEILINGS TO MATCH EXISTING REMOVED CEILING ELEVATION OR 9'-0" A.F.F. UNLESS NOTED OTHERWISE. SEE ELECTRICAL, MECHANICAL, AND PLUMBING SHEETS FOR ADDITIONAL INFORMATION.
- ALL RECESSED LIGHT FIXTURES IN ACOUSTIC PANEL CEILING GRID TO BE CENTERED IN TILE UNLESS NOTED OTHERWISE

CEILING LEGEND

- ELECTRICAL SYMBOLS INDICATING LIGHTING LOCATIONS. REFER TO EL SHEETS FOR SIZE / TYPE OF LIGHTING FIXTURES.
- MECHANICAL SYMBOLS INDICATING SUPPLY DIFFUSER OR EXHAUST/RETURN GRILLE LOCATIONS. REFER TO MH SHEETS FOR SIZE / TYPE OF DIFFUSER / GRILLE.
- 2'-0"x2'-0" ACOUSTICAL PANEL CEILING & METAL SUSPENSION GRID.
- NEW 5/8" GYPSUM WALL BOARD CEILING OR SOFFIT.

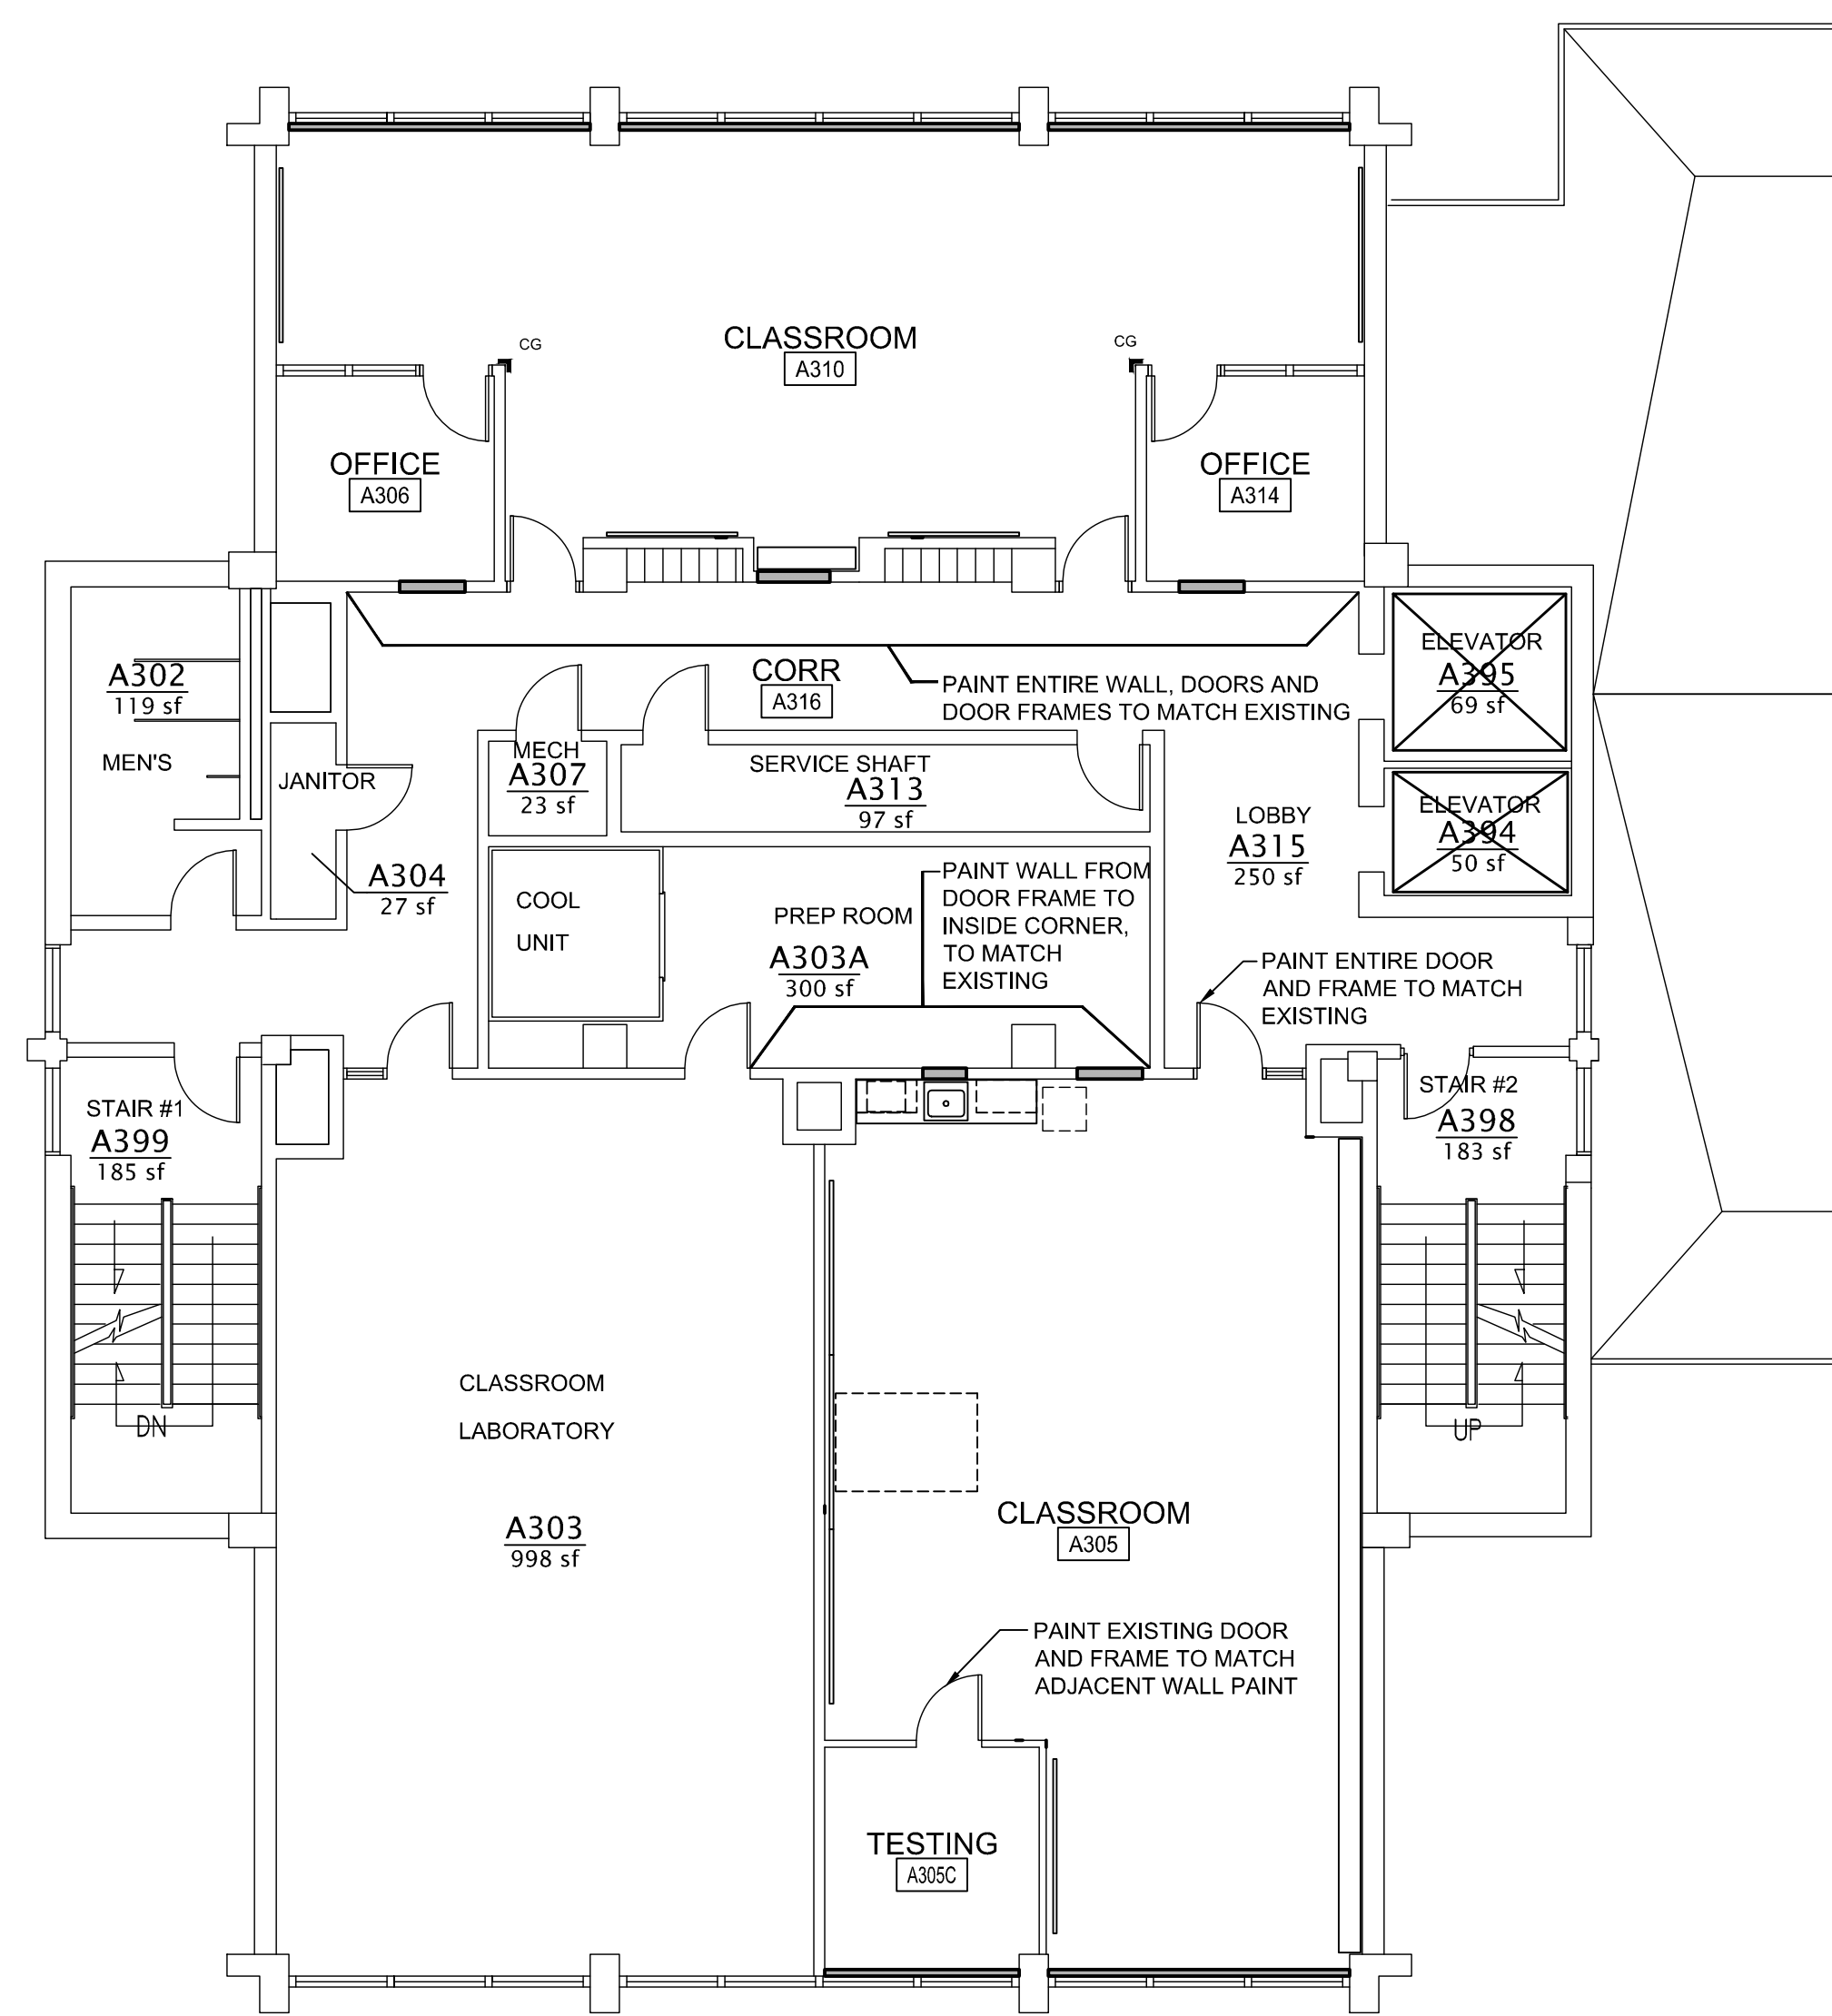


- FINISH PLAN LEGEND:**
- SHADED GRAPHIC APPLIES TO ROOMS W/ PATTERN ONLY. SEE FINISH SCHEDULE FOR FINISH IN ROOMS WITHOUT SHADING.
- SHEET OR ROLL PATTERN DESIGNATION. SEE NOTE 1
 TILE PATTERN DESIGNATION. SEE NOTE 1
 EXIST. FLOOR TO REMAIN

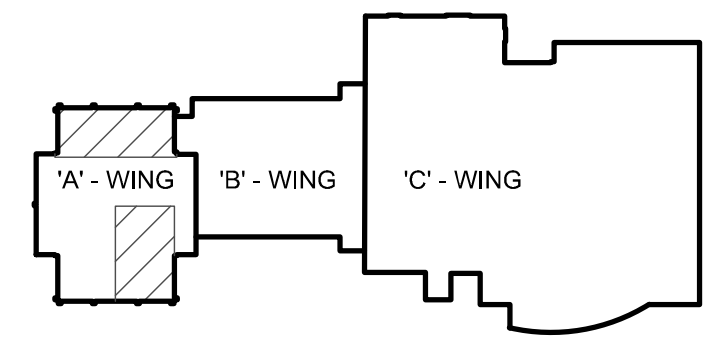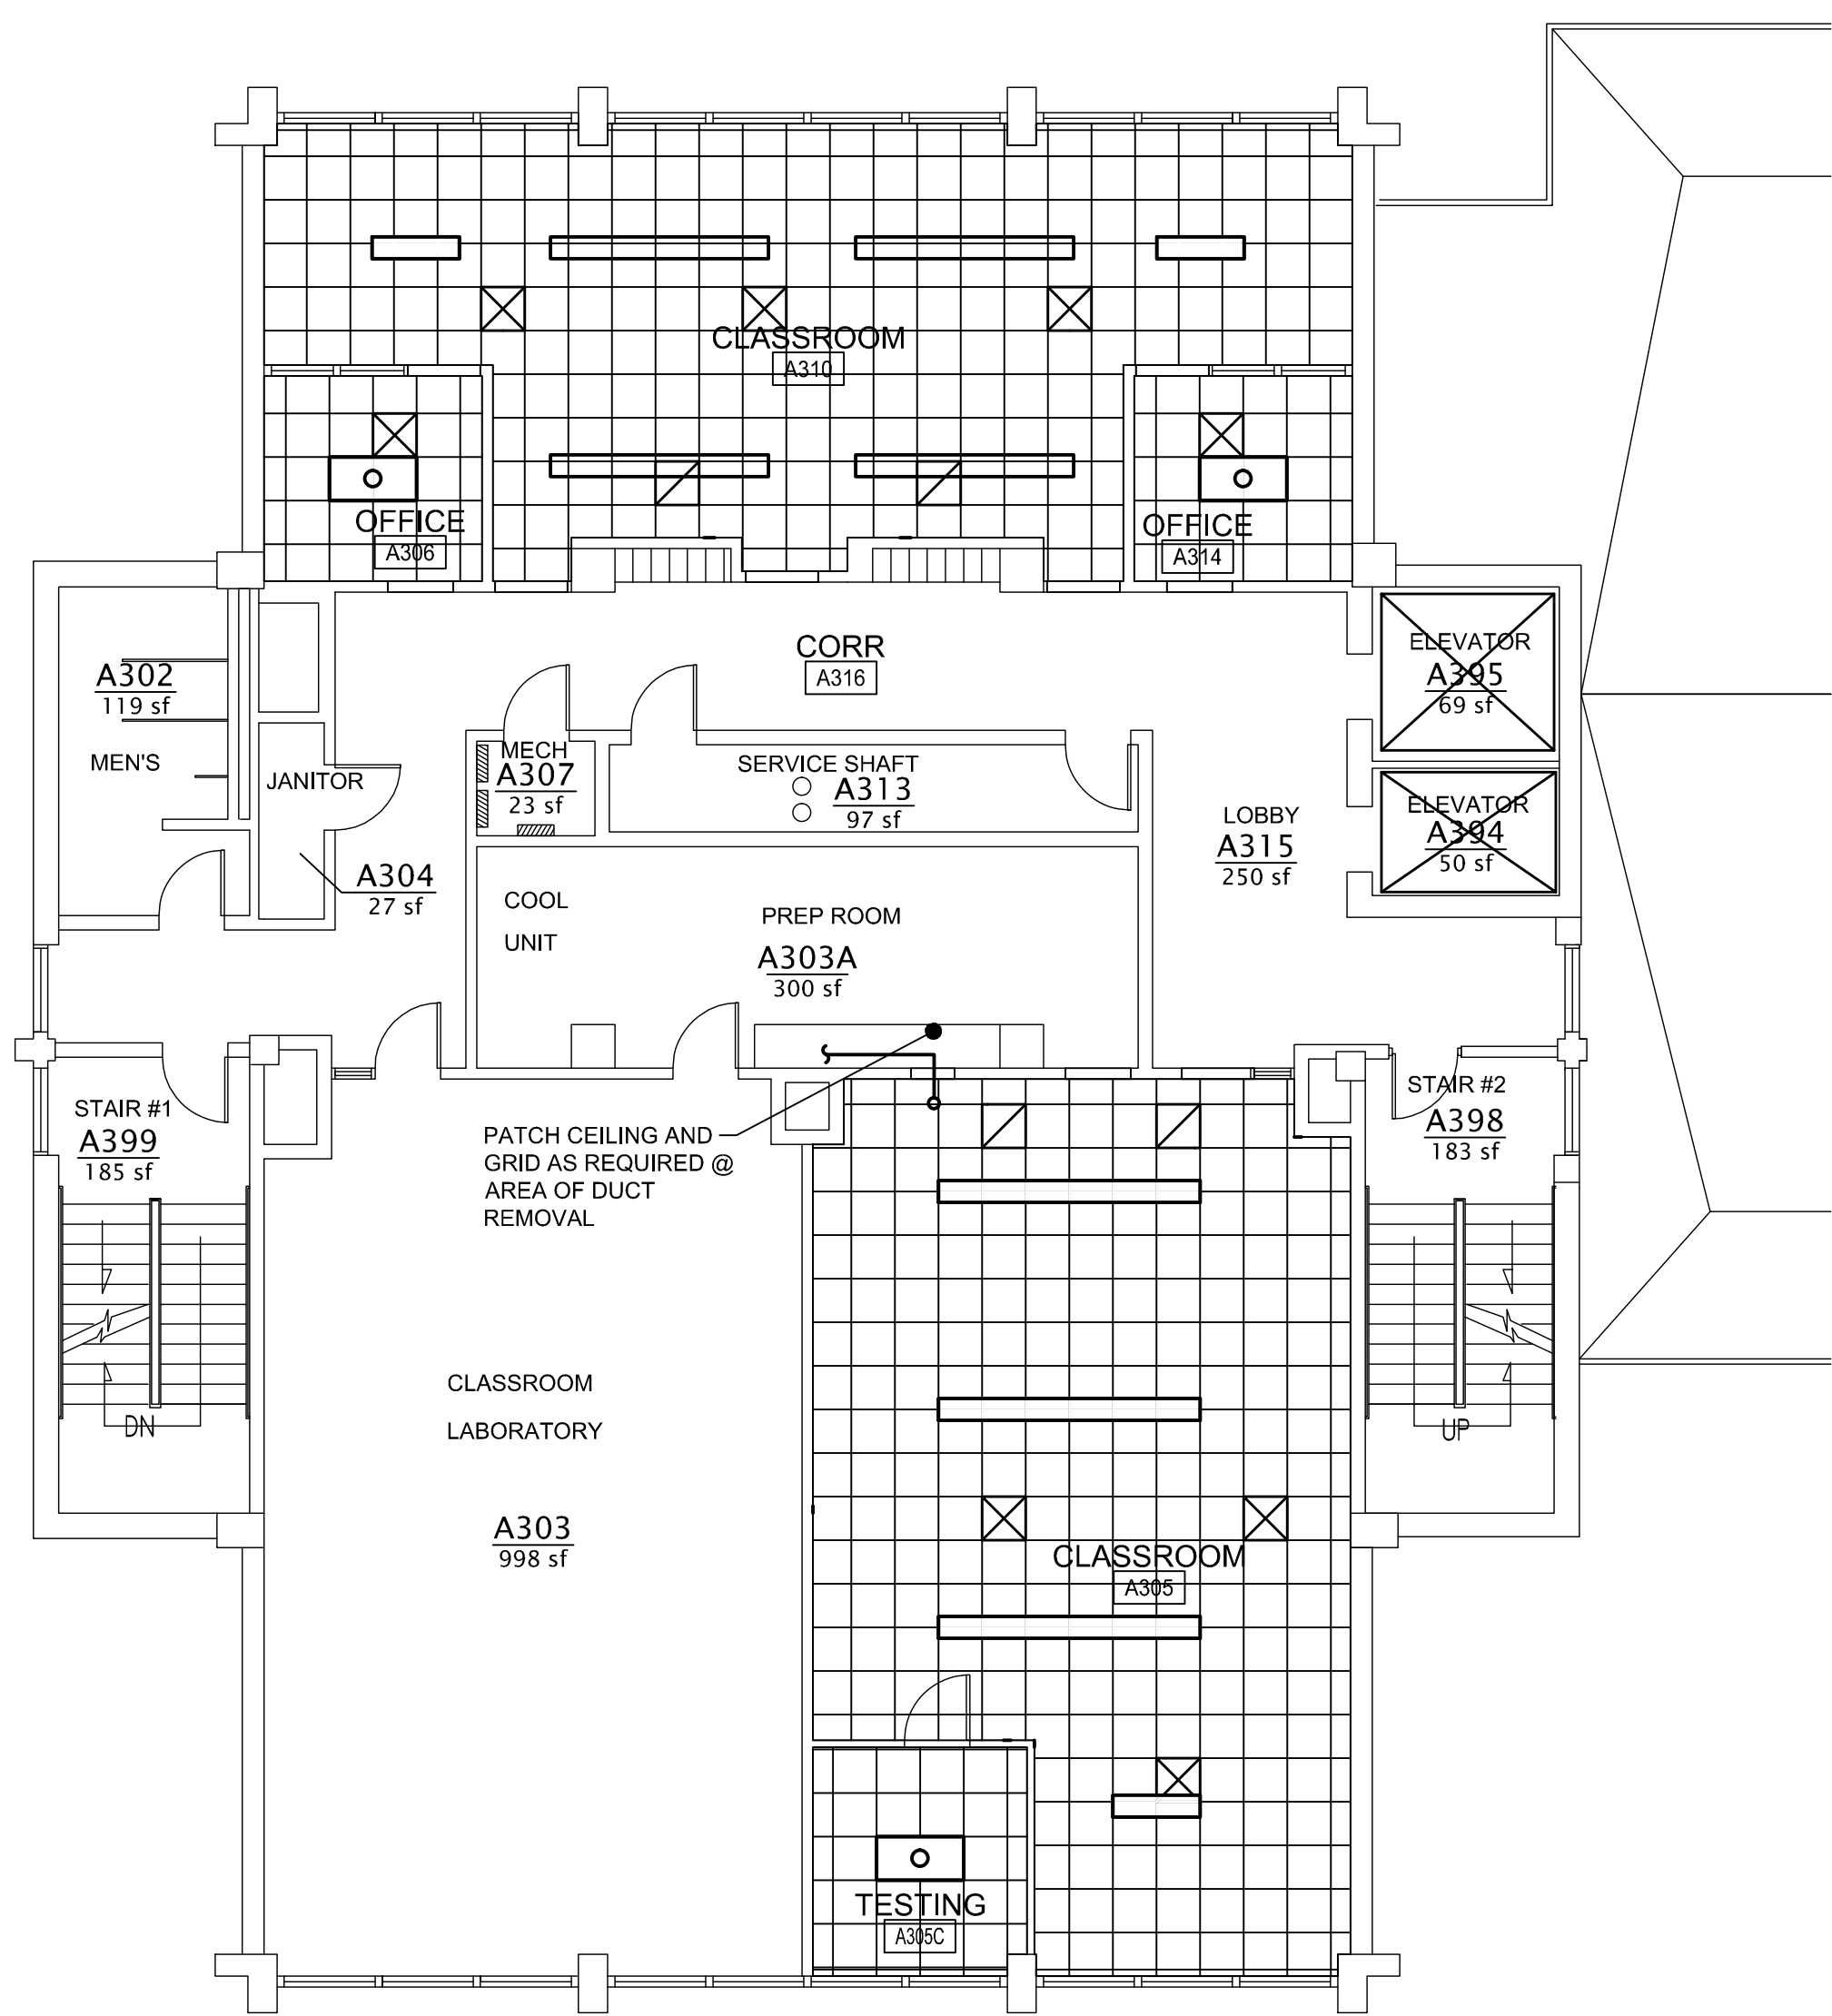

KEY PLAN

REV.	DESCRIPTION	DATE
0	BID DOCUMENTS	01-13-17

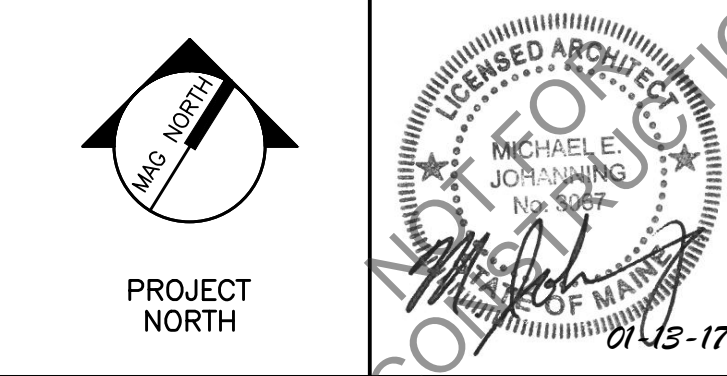

WBRC
ARCHITECTS + ENGINEERS
WWW.WBRCAE.COM
BANGOR, MAINE 207-647-4511
PORTLAND, MAINE 207-628-4511
SUWANEE, FLORIDA 941-5560075

USM SCIENCE BUILDING OFFICE RENOVATIONS

PROJECT: PORTLAND, ME
THIRD FLOOR REFLECTED CEILING PLAN AND FINISH PLAN

SHEET TITLE:	4128.10 - AE106
WBRC CAD FILE:	4128.10 GRAPHIC SCALE: 0"
PROJECT No.:	AS NOTED
SCALE:	MEJ SHEET No.
PROJECT MANAGER:	JLR/RAD
DRAWN BY:	MEJ
CHECKED BY:	MEJ

A1 THIRD FLOOR FINISH PLAN

A10 THIRD FLOOR REFLECTED CEILING PLAN

1/8" = 1'-0"

1/8" = 1'-0"

1/2/2017 3:37 PM T:\02 PROJECTS - MAINE\101-4200\12810 USM SCIENCE BLDG CONSULTATION\2 DESIGN\WORKS\BIDD\USM SCIENCE BUILDING\3 SHEETS\12810-4E106 THIRD FLOOR REFLECTED CEILING PLAN AND FINISH PLAN.DWG BSE/BJB