

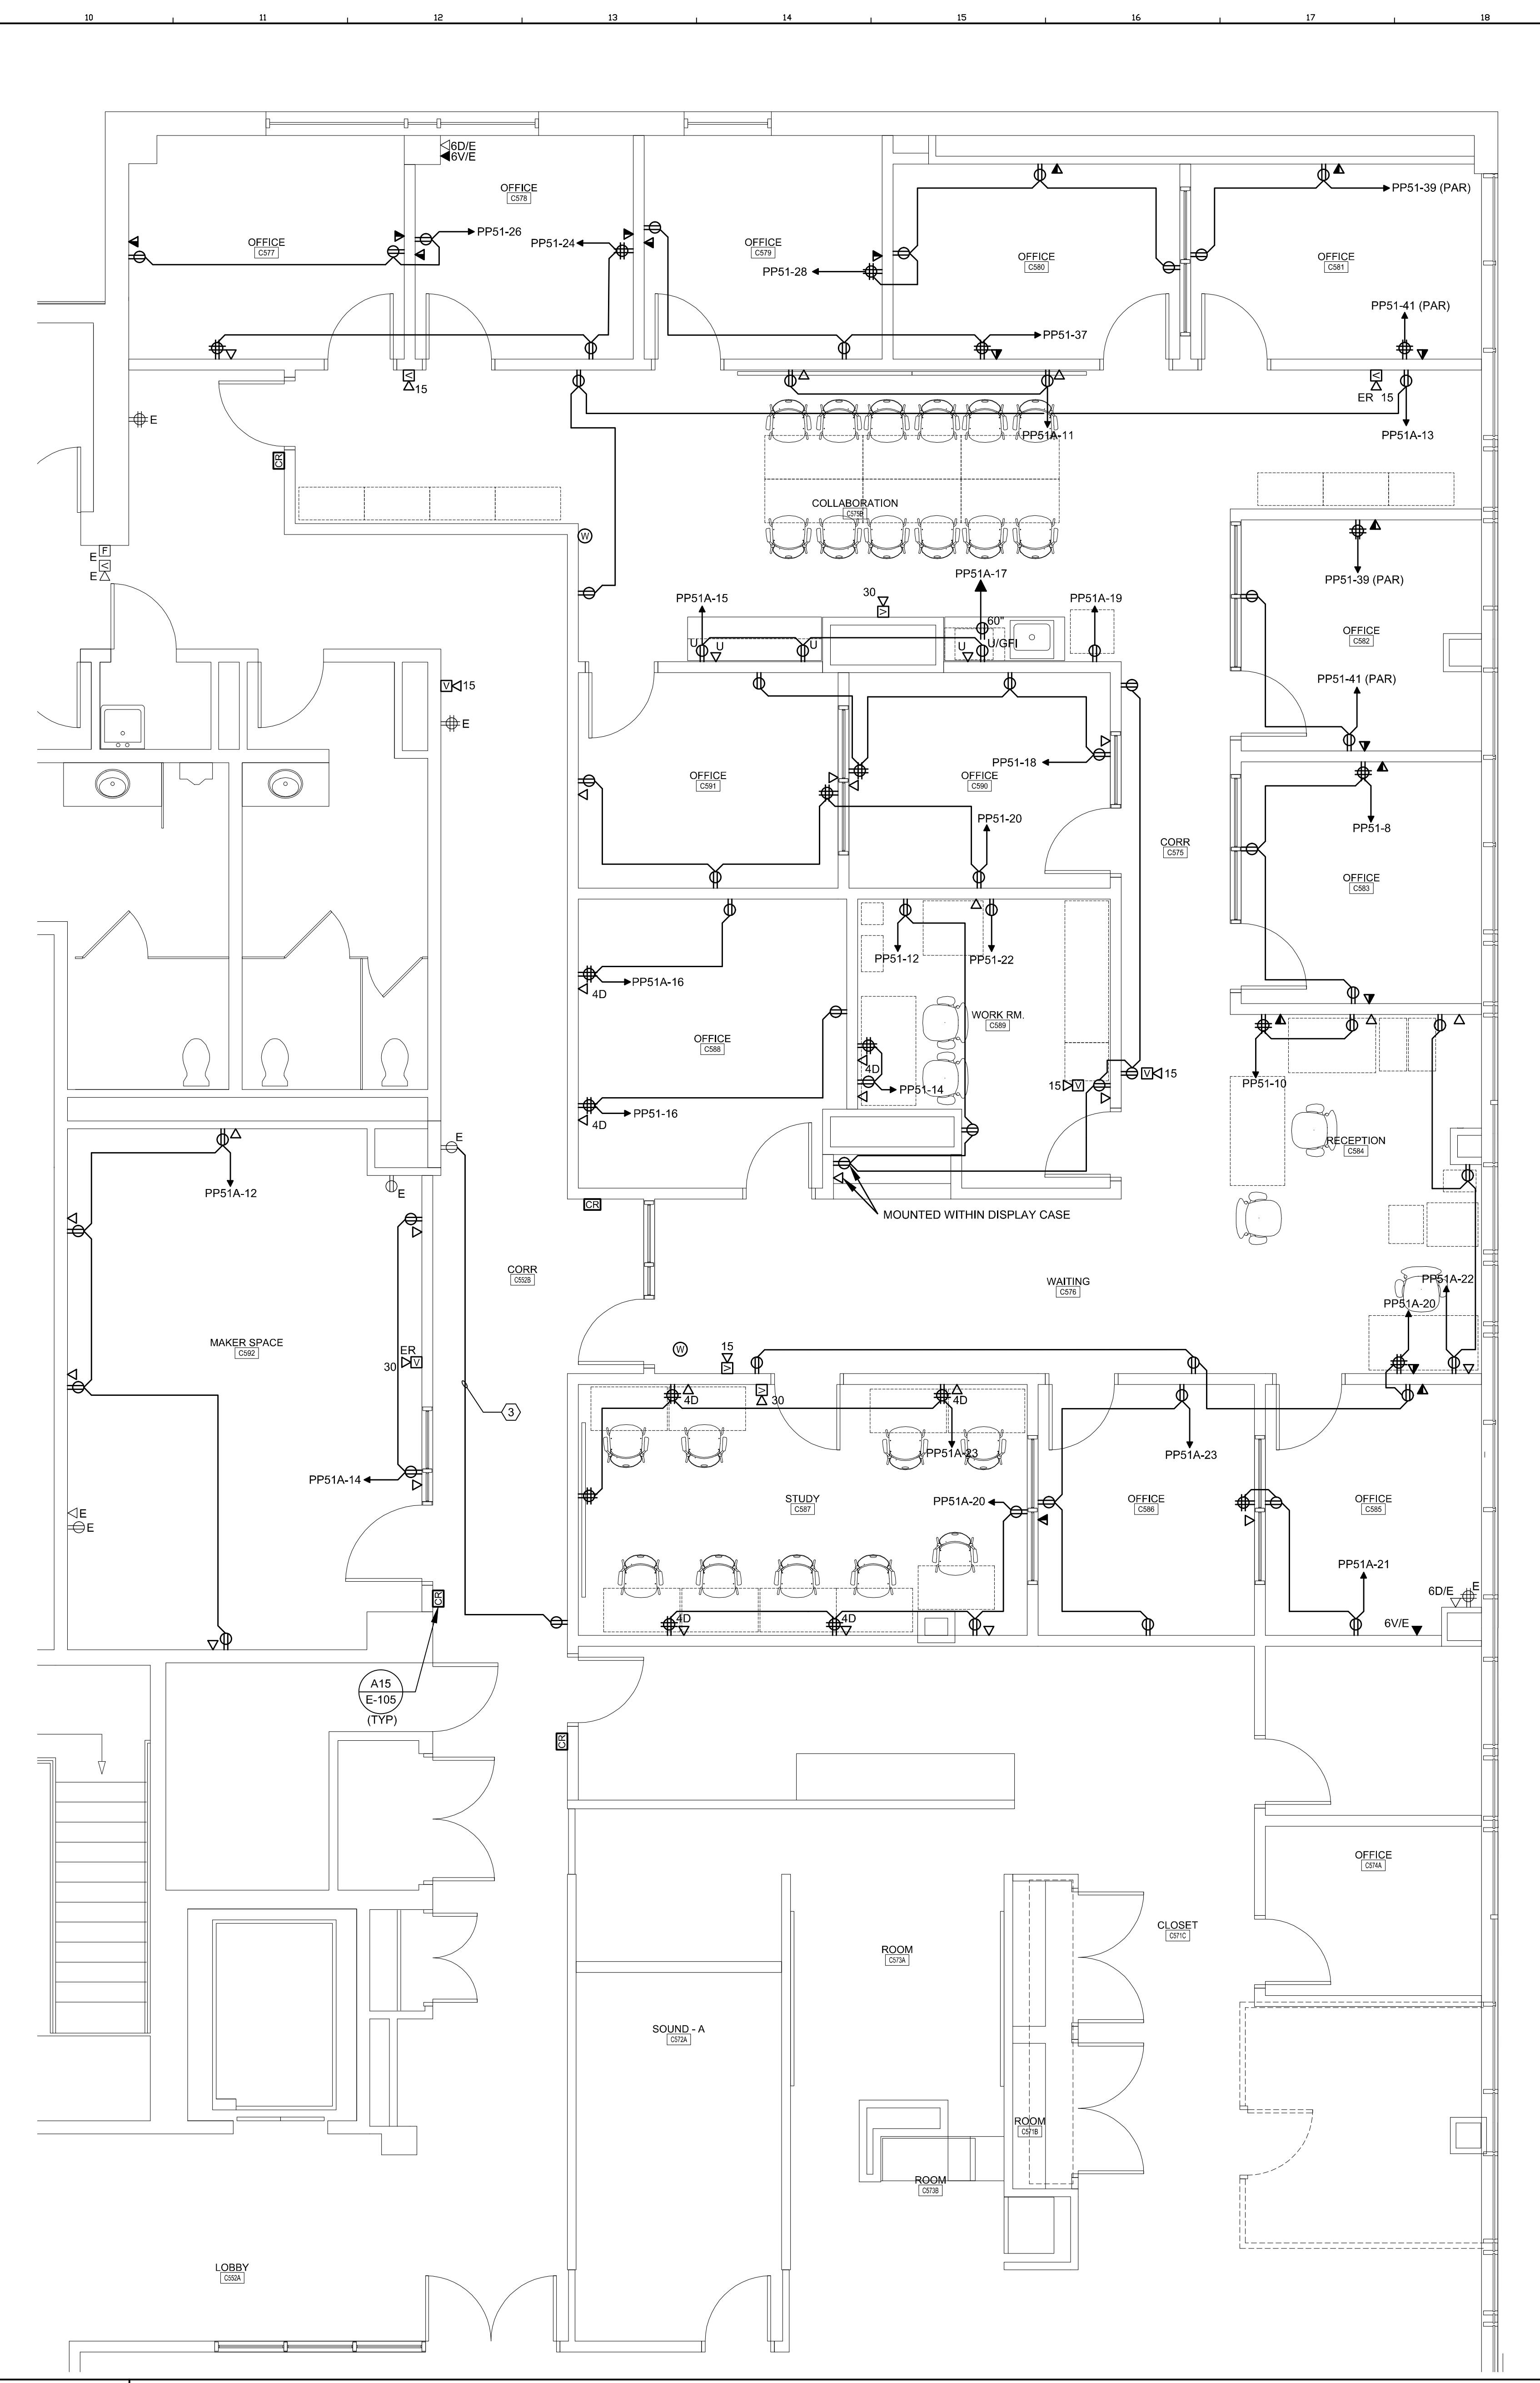



1/13/2017 2:54 AM T:\02 PROJECTS - MAINE\101-4200\4128.10 USM SCIENCE BLDG CONSULTATION\2 DESIGN\WORKS\BLDG\SCIENCE BUILDING\SHEETS\128.10-E-401 ELECTRICAL ENLARGED PLANS.DWG - DREN.WASTENBERGERE

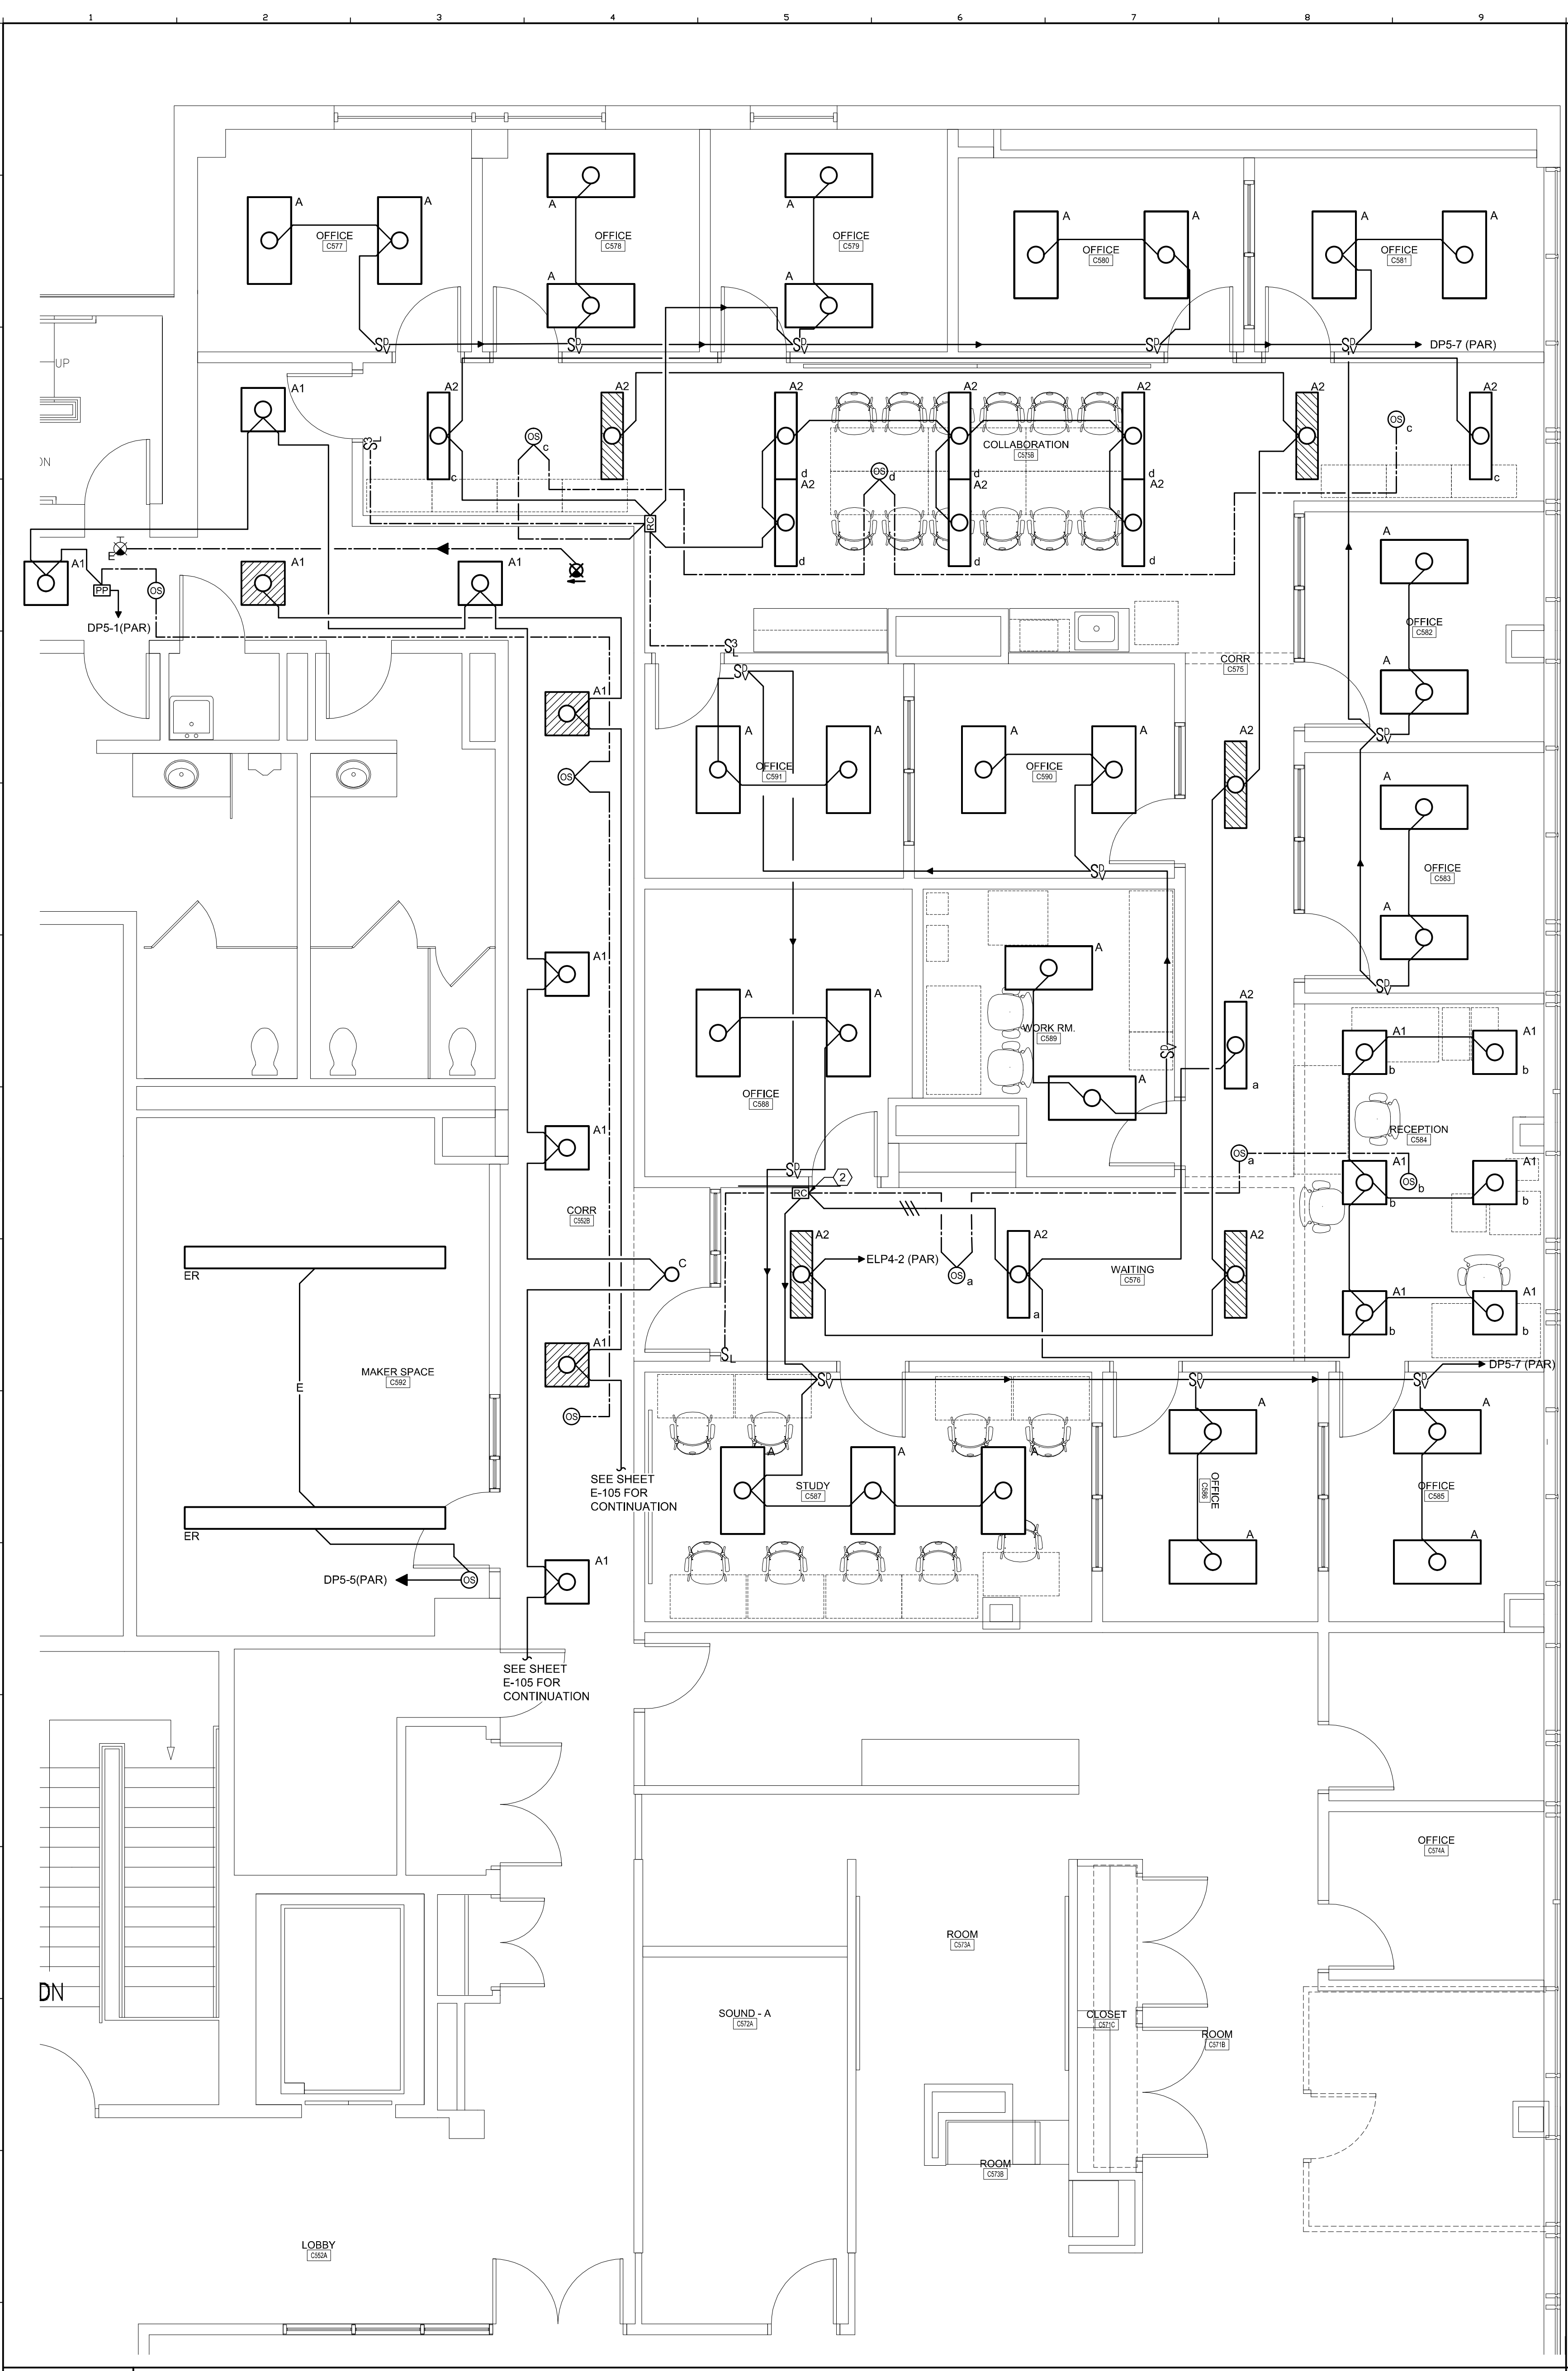

- TECHNICAL NOTES:**
- CONNECT EXISTING FIXTURES TO NEW CONTROL DEVICE.
 - ROOM CONTROLLER NOTE FROM E-103.
 - CONNECT TO EXISTING POWER CIRCUIT.

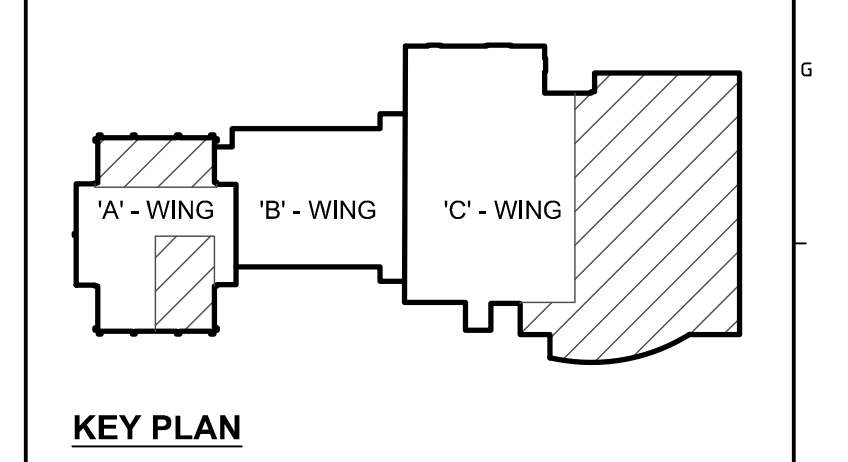

REV.	DESCRIPTION	DATE
0	BID DOCUMENTS	01-13-17

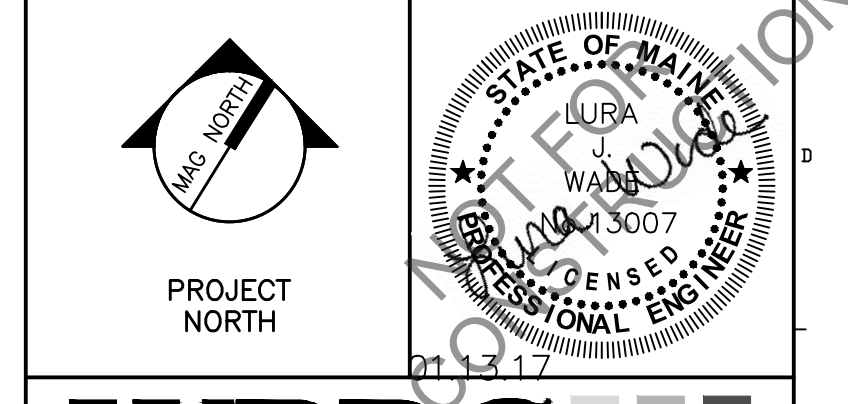

WBRCE
ARCHITECTS • ENGINEERS
WWW.WBRCE.COM
BANGOR, MAINE 207-647-4511
PORTLAND, MAINE 207-628-4511
SUDBURY, FLORIDA 941-556-0757

USM SCIENCE BUILDING OFFICE RENOVATIONS

PROJECT: PORTLAND, ME
ELECTRICAL ENLARGED PLANS

SHEET TITLE: 4128.10 - E-401
PROJECT No. 4128.10 GRAPHIC SCALE: 0"

SCALE: AS NOTED
PROJECT MANAGER: MEJ
DRAWN BY: DVS
CHECKED BY: LJW
E-401

A1 FIFTH FLOOR ENLARGED LIGHTING PLAN
1/4" = 1'-0"

A10 FIFTH FLOOR ENLARGED POWER PLAN
1/4" = 1'-0"