

# USM SCIENCE BUILDING OFFICE RENOVATIONS

70 FALMOUTH ST.  
PORTLAND, ME  
USM PROJECT #2016-029  
BID DOCUMENTS  
01-13-17

## INDEX

### GENERAL DRAWINGS

G1001 - COVER SHEET  
G1002 - SYMBOLS AND ABBREVIATIONS  
G1003 - THIRD, FOURTH, AND FIFTH FLOOR REFERENCE PLANS

### ARCHITECTURAL DRAWINGS

AE103 - THIRD FLOOR PLAN AND REMOVALS PLAN  
AE104 - FOURTH FLOOR PLAN AND REMOVALS PLAN  
AE105 - FIFTH FLOOR PLAN AND REMOVALS PLAN  
AE106 - THIRD FLOOR REFLECTED CEILING PLAN AND FINISH PLAN  
AE107 - FOURTH FLOOR REFLECTED CEILING PLAN AND FINISH PLAN  
AE108 - FIFTH FLOOR REFLECTED CEILING PLAN AND FINISH PLAN  
AE201 - INTERIOR ELEVATIONS  
AE401 - ENLARGED FLOOR PLAN  
AE501 - WALL TYPES  
AE502 - MISC DETAILS  
AE601 - DOOR AND WINDOW SCHEDULE AND TYPES  
AF501 - FINISH SCHEDULE AND DETAILS

### MECHANICAL DRAWINGS

M-801 - MECHANICAL LEGEND  
M-103 - THIRD FLOOR MECHANICAL PLANS  
M-104 - FOURTH FLOOR MECHANICAL PLANS  
M-105 - FIFTH FLOOR MECHANICAL PLANS  
M-401 - MECHANICAL PART PLANS  
M-501 - MECHANICAL DETAILS & SCHEDULES

### ELECTRICAL DRAWINGS

E-001 - ELECTRICAL LEGEND  
E-103 - THIRD FLOOR ELECTRICAL PLANS  
E-104 - FOURTH FLOOR ELECTRICAL PLANS  
E-105 - FIFTH FLOOR ELECTRICAL PLANS  
E-401 - ELECTRICAL ENLARGED PLANS  
E-501 - ELECTRICAL DETAILS  
E-601 - PANELBOARD SCHEDULES




PROJECT  
LOCATION



USM PROJECT #2016-029

| SIGNATURE   | DATE |
|-------------|------|
| OWNER:      |      |
| ARCHITECT:  |      |
| CONTRACTOR: |      |

| REV. | DESCRIPTION   | DATE     |
|------|---------------|----------|
| 0    | BID DOCUMENTS | 01-13-17 |

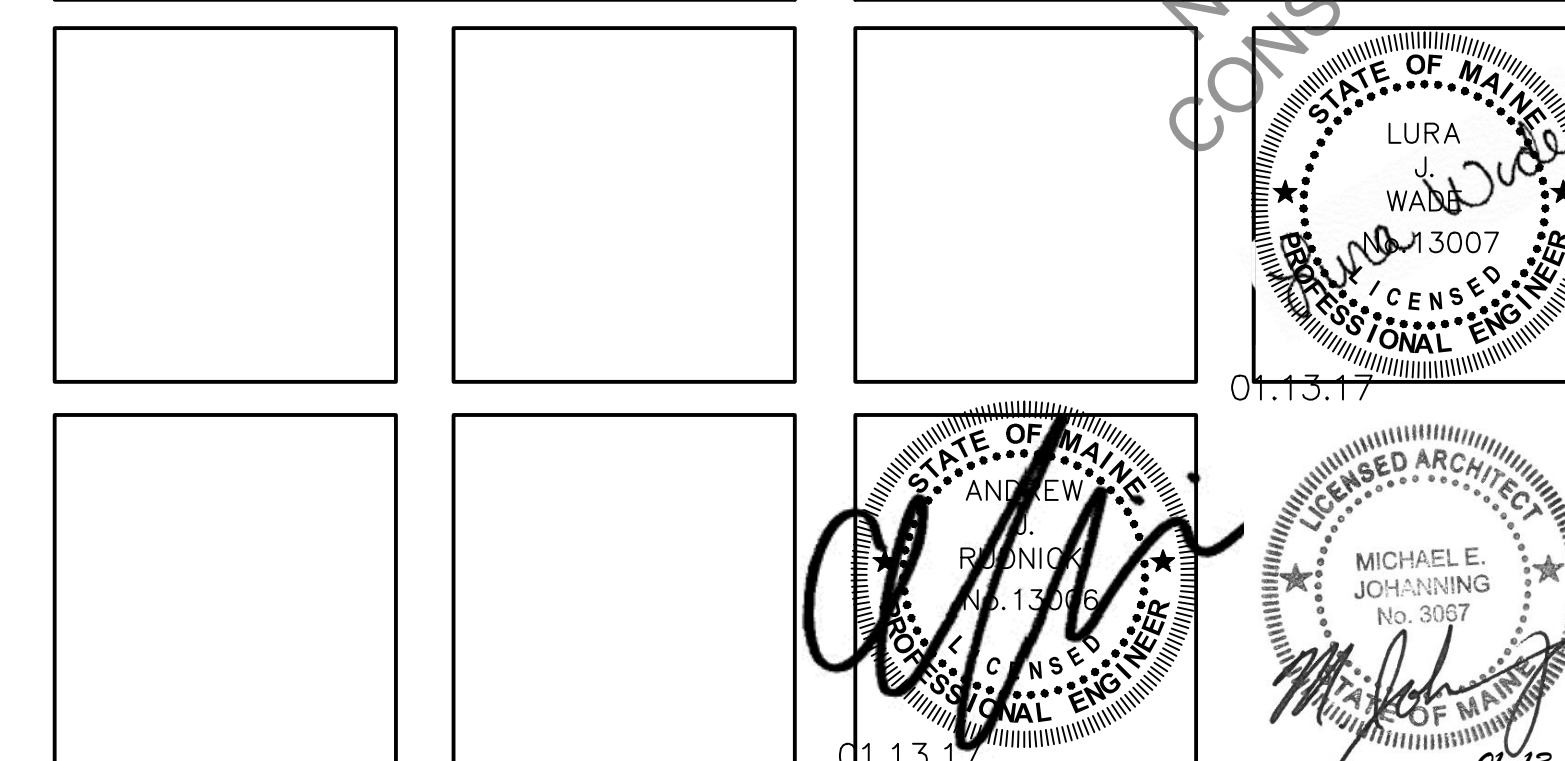

SHEET No.  
**G1001**

COMM. No.  
**4128.10**

# WBRC

ARCHITECTS • ENGINEERS

BANGOR, MAINE  
207-947-4511

PORTLAND, MAINE  
207-828-4511

SARASOTA, FLORIDA  
941-556-0757

www.wbrcae.com