

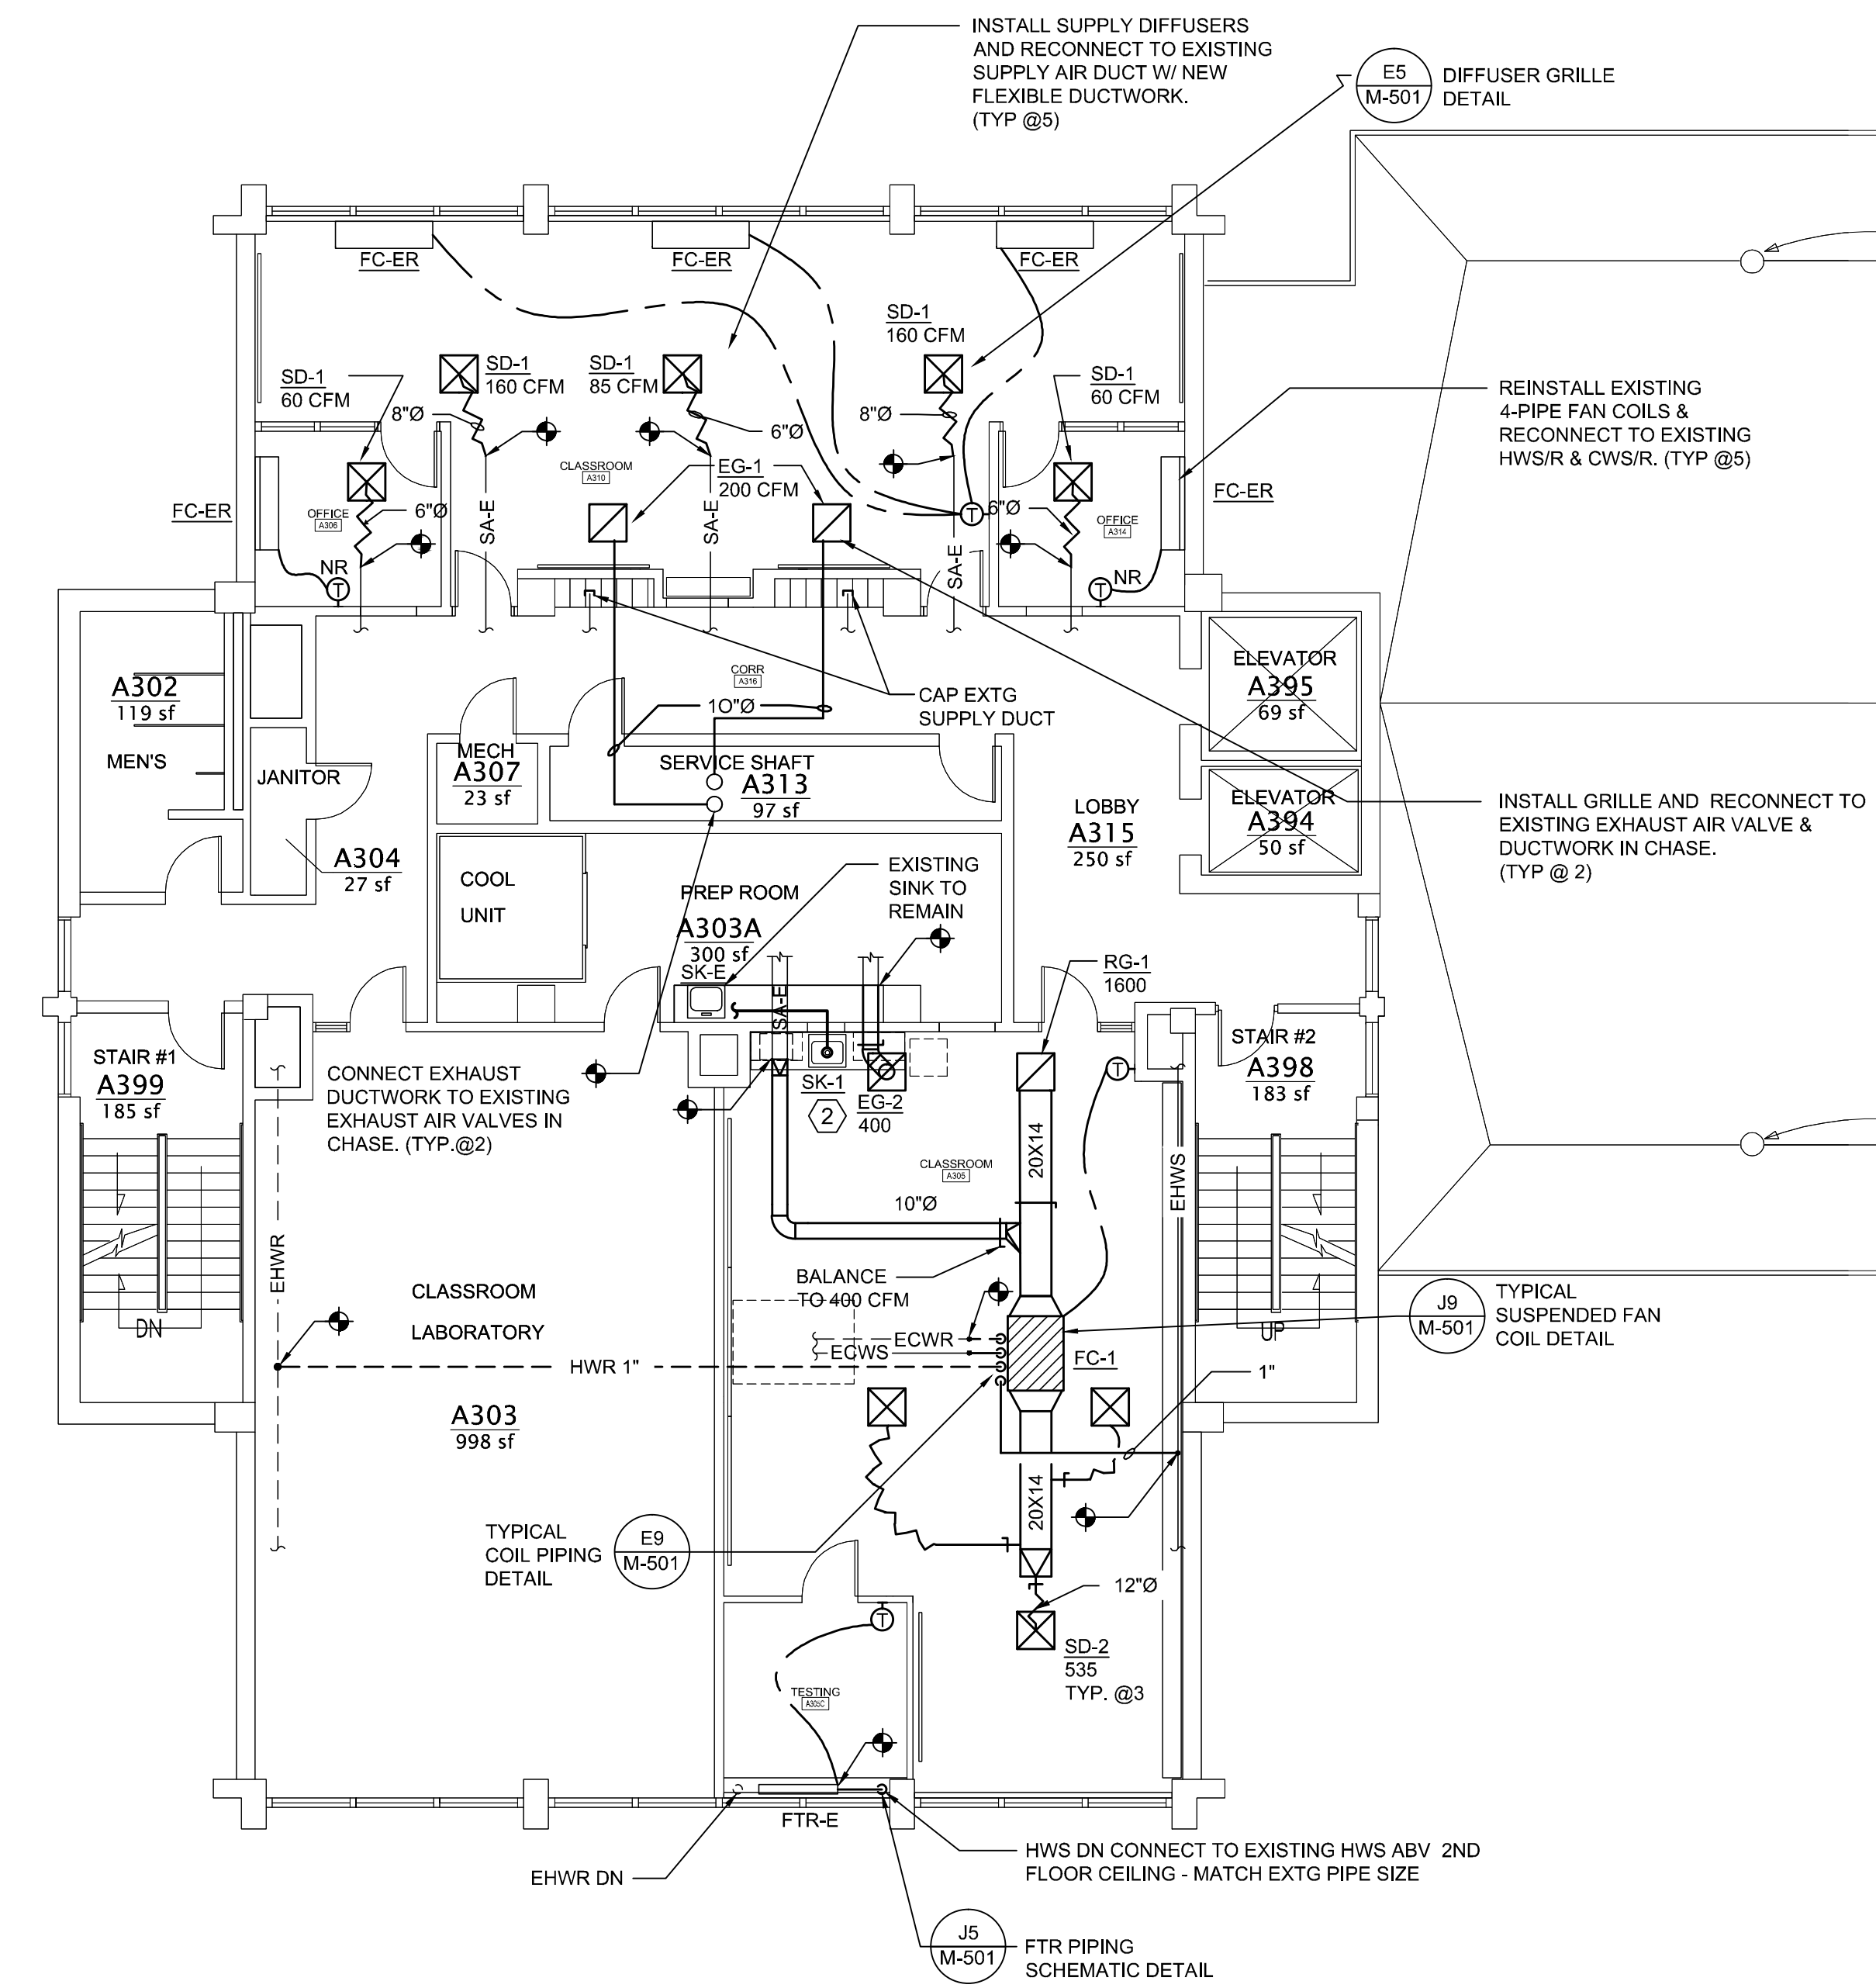



1/2/2017 9:45 PM T:\02 PROJECTS - MAINE\101-4200\11810 USM SCIENCE BLDG CONSULTATION\2 DESIGN\WORKS\B\03 USM SCIENCE BLDG CONSULTATION\11810-10-103 THIRD FLOOR MECHANICAL PLANS.DWG ANDREW RUBINICKI

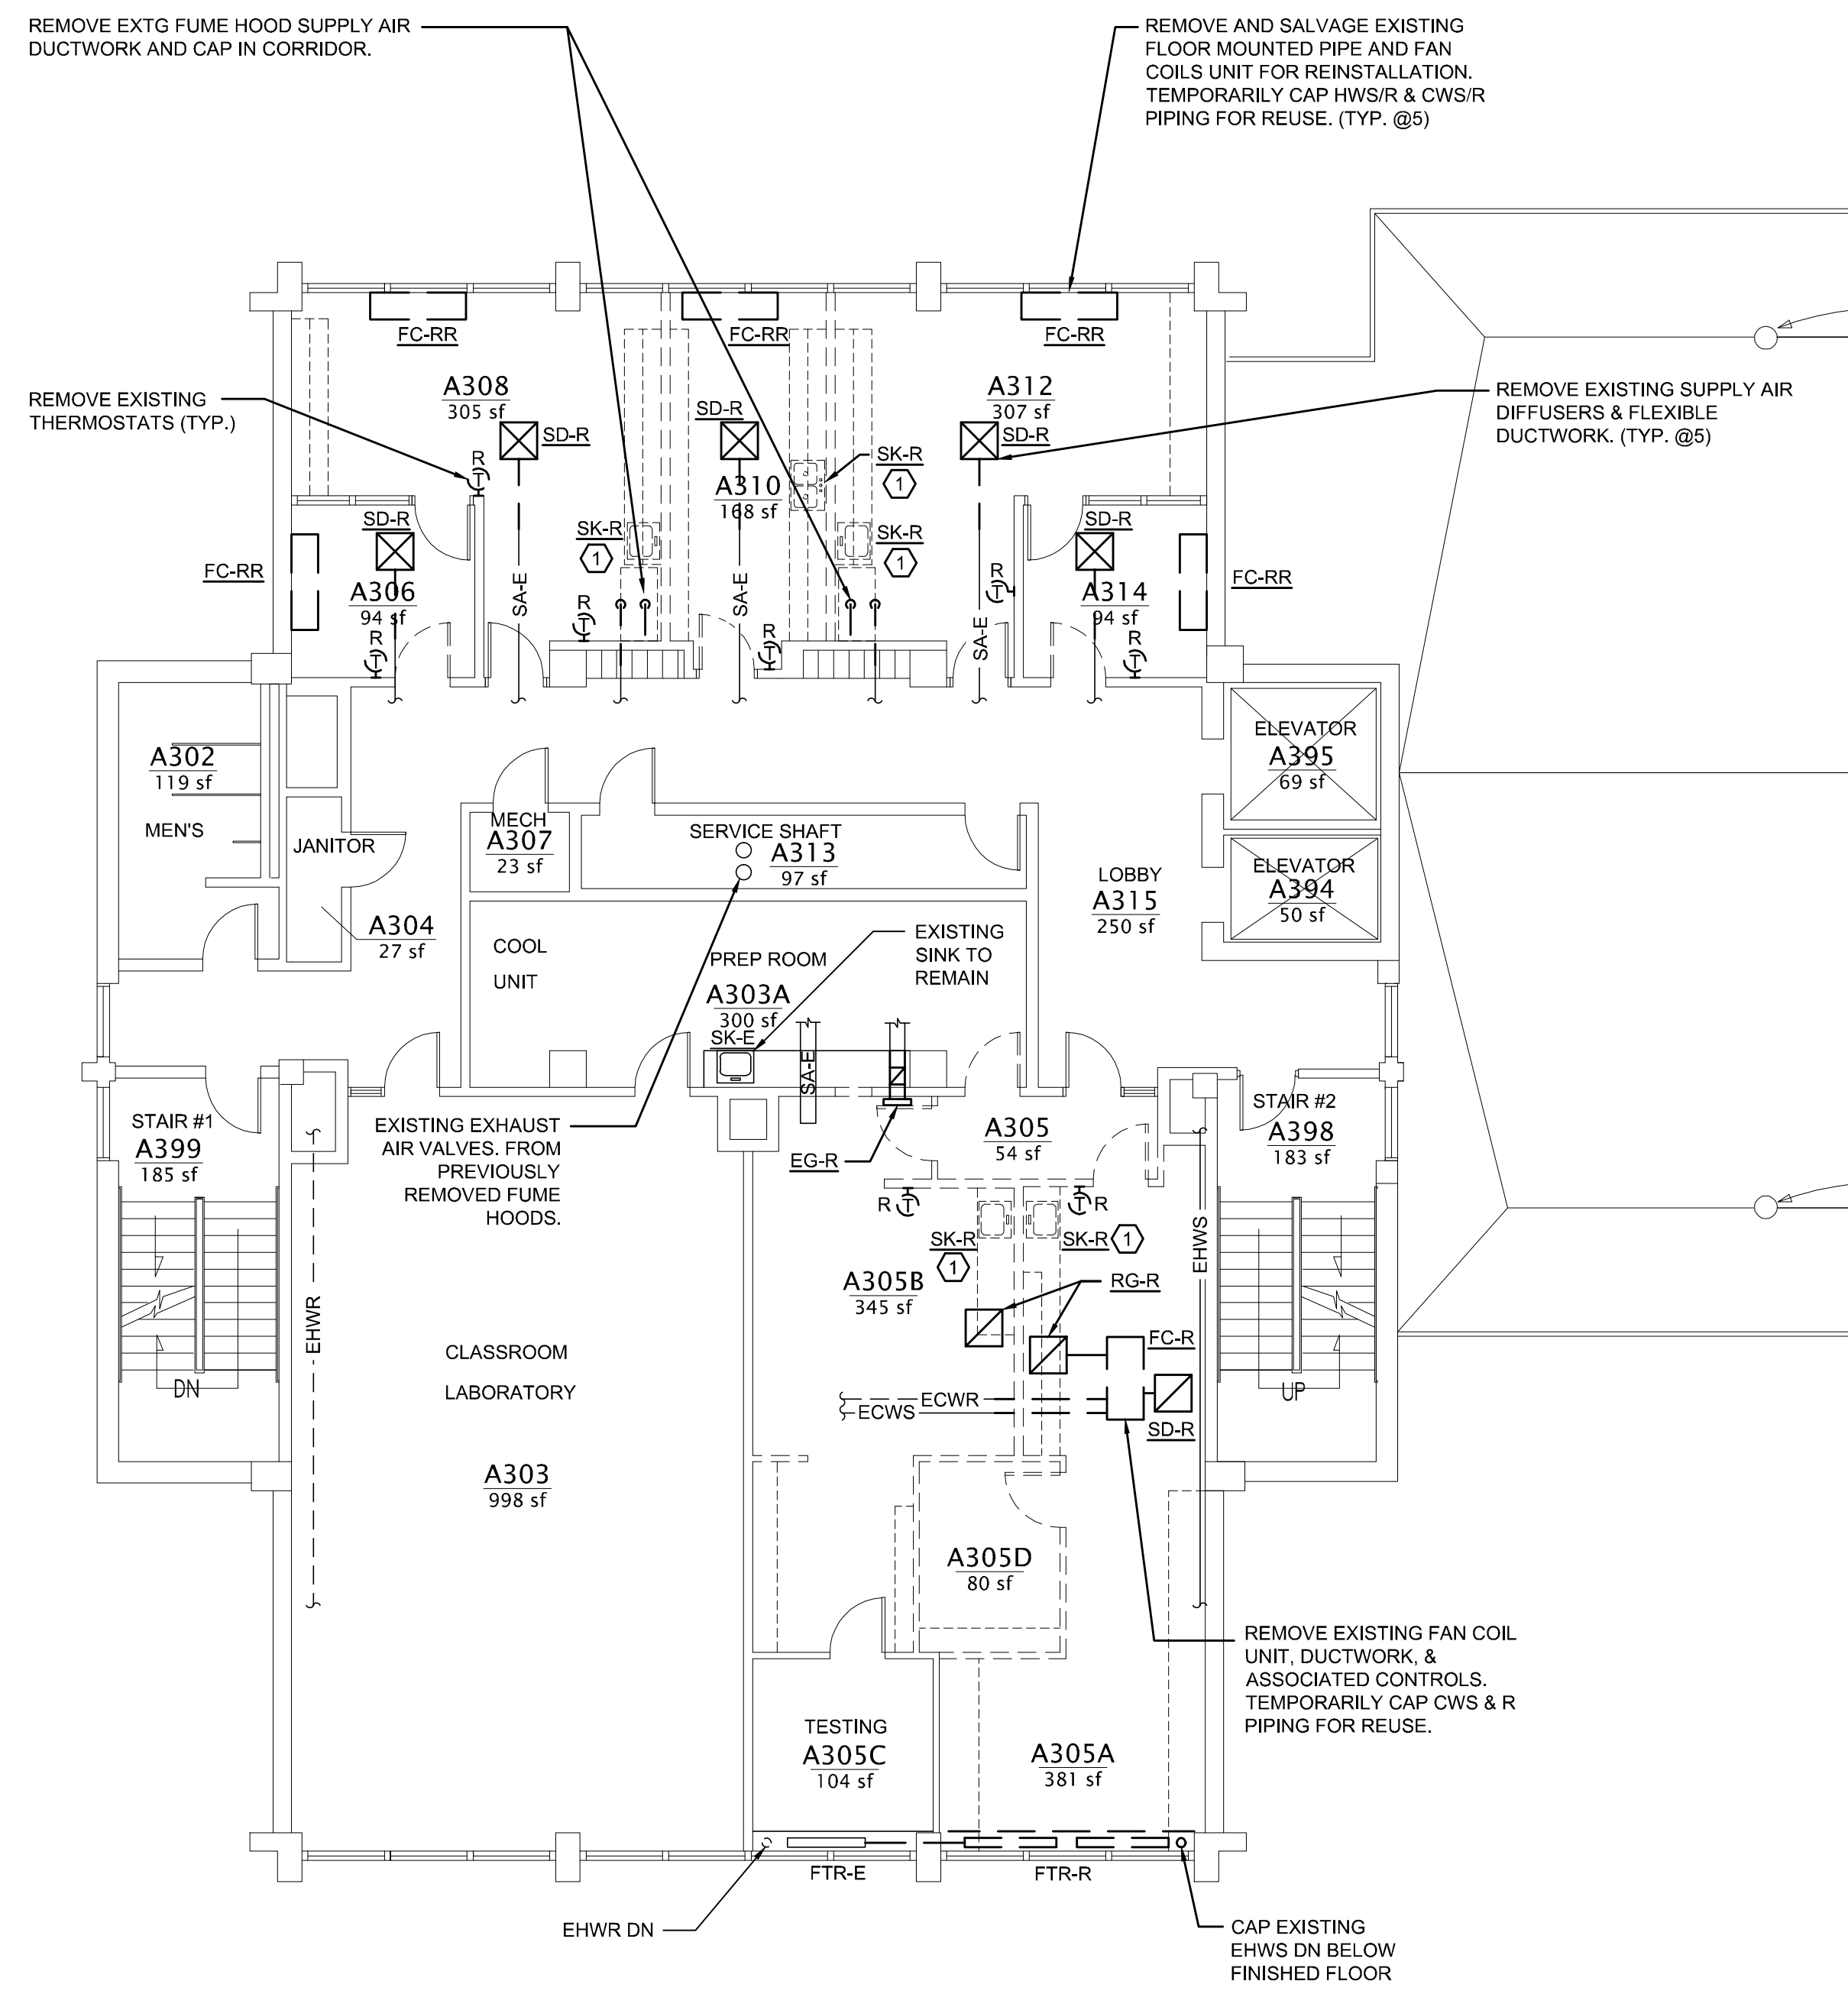

- TECHNICAL NOTES:**
- ① REMOVE EXISTING SINK AND FAUCET, CUT BACK PIPING AND CAP BEHIND FINISHED SURFACES.
  - ② CONNECT TO EXISTING DOMESTIC HOT WATER, COLD WATER, WASTE & VENT PIPING IN WALL & IN BASE CABINET OF SINK IN PREP ROOM.

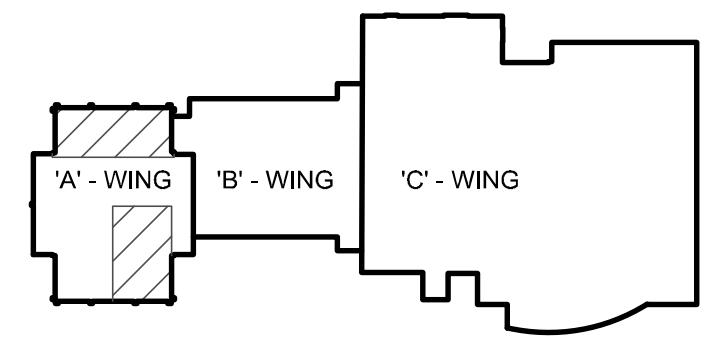

REV.	DESCRIPTION	DATE
0	BID DOCUMENTS	01-13-17

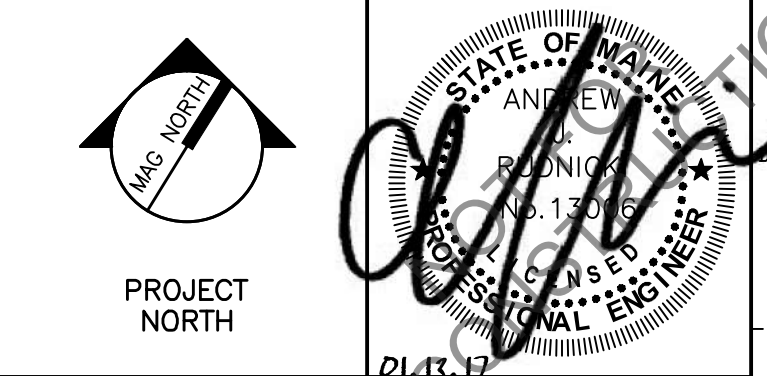

**WBRC**  
ARCHITECTS • ENGINEERS  
WWW.WBRC.COM  
BANGOR, MAINE 207-647-4511  
PORTLAND, MAINE 207-636-6911  
SAVANNAH, GEORGIA 404-556-0075

**USM SCIENCE BUILDING OFFICE RENOVATIONS**

PROJECT: PORTLAND, ME  
**THIRD FLOOR MECHANICAL PLANS**

SHEET TITLE:	4128.10 - M-103
WBRC CAD FILE:	4128.10
PROJECT No.:	GRAPHIC SCALE: 0"
SCALE:	AS NOTED
PROJECT MANAGER:	MEJ
DRAWN BY:	SMS
CHECKED BY:	AJR

**M-103**

**A1**    **THIRD FLOOR MECHANICAL REMOVALS PLAN**  
1/8" = 1'-0"

**A10**    **THIRD FLOOR MECHANICAL PLAN**  
1/8" = 1'-0"