



A1 FIFTH FLOOR MECHANICAL REMOVALS PLAN
 1/8" = 1'-0"

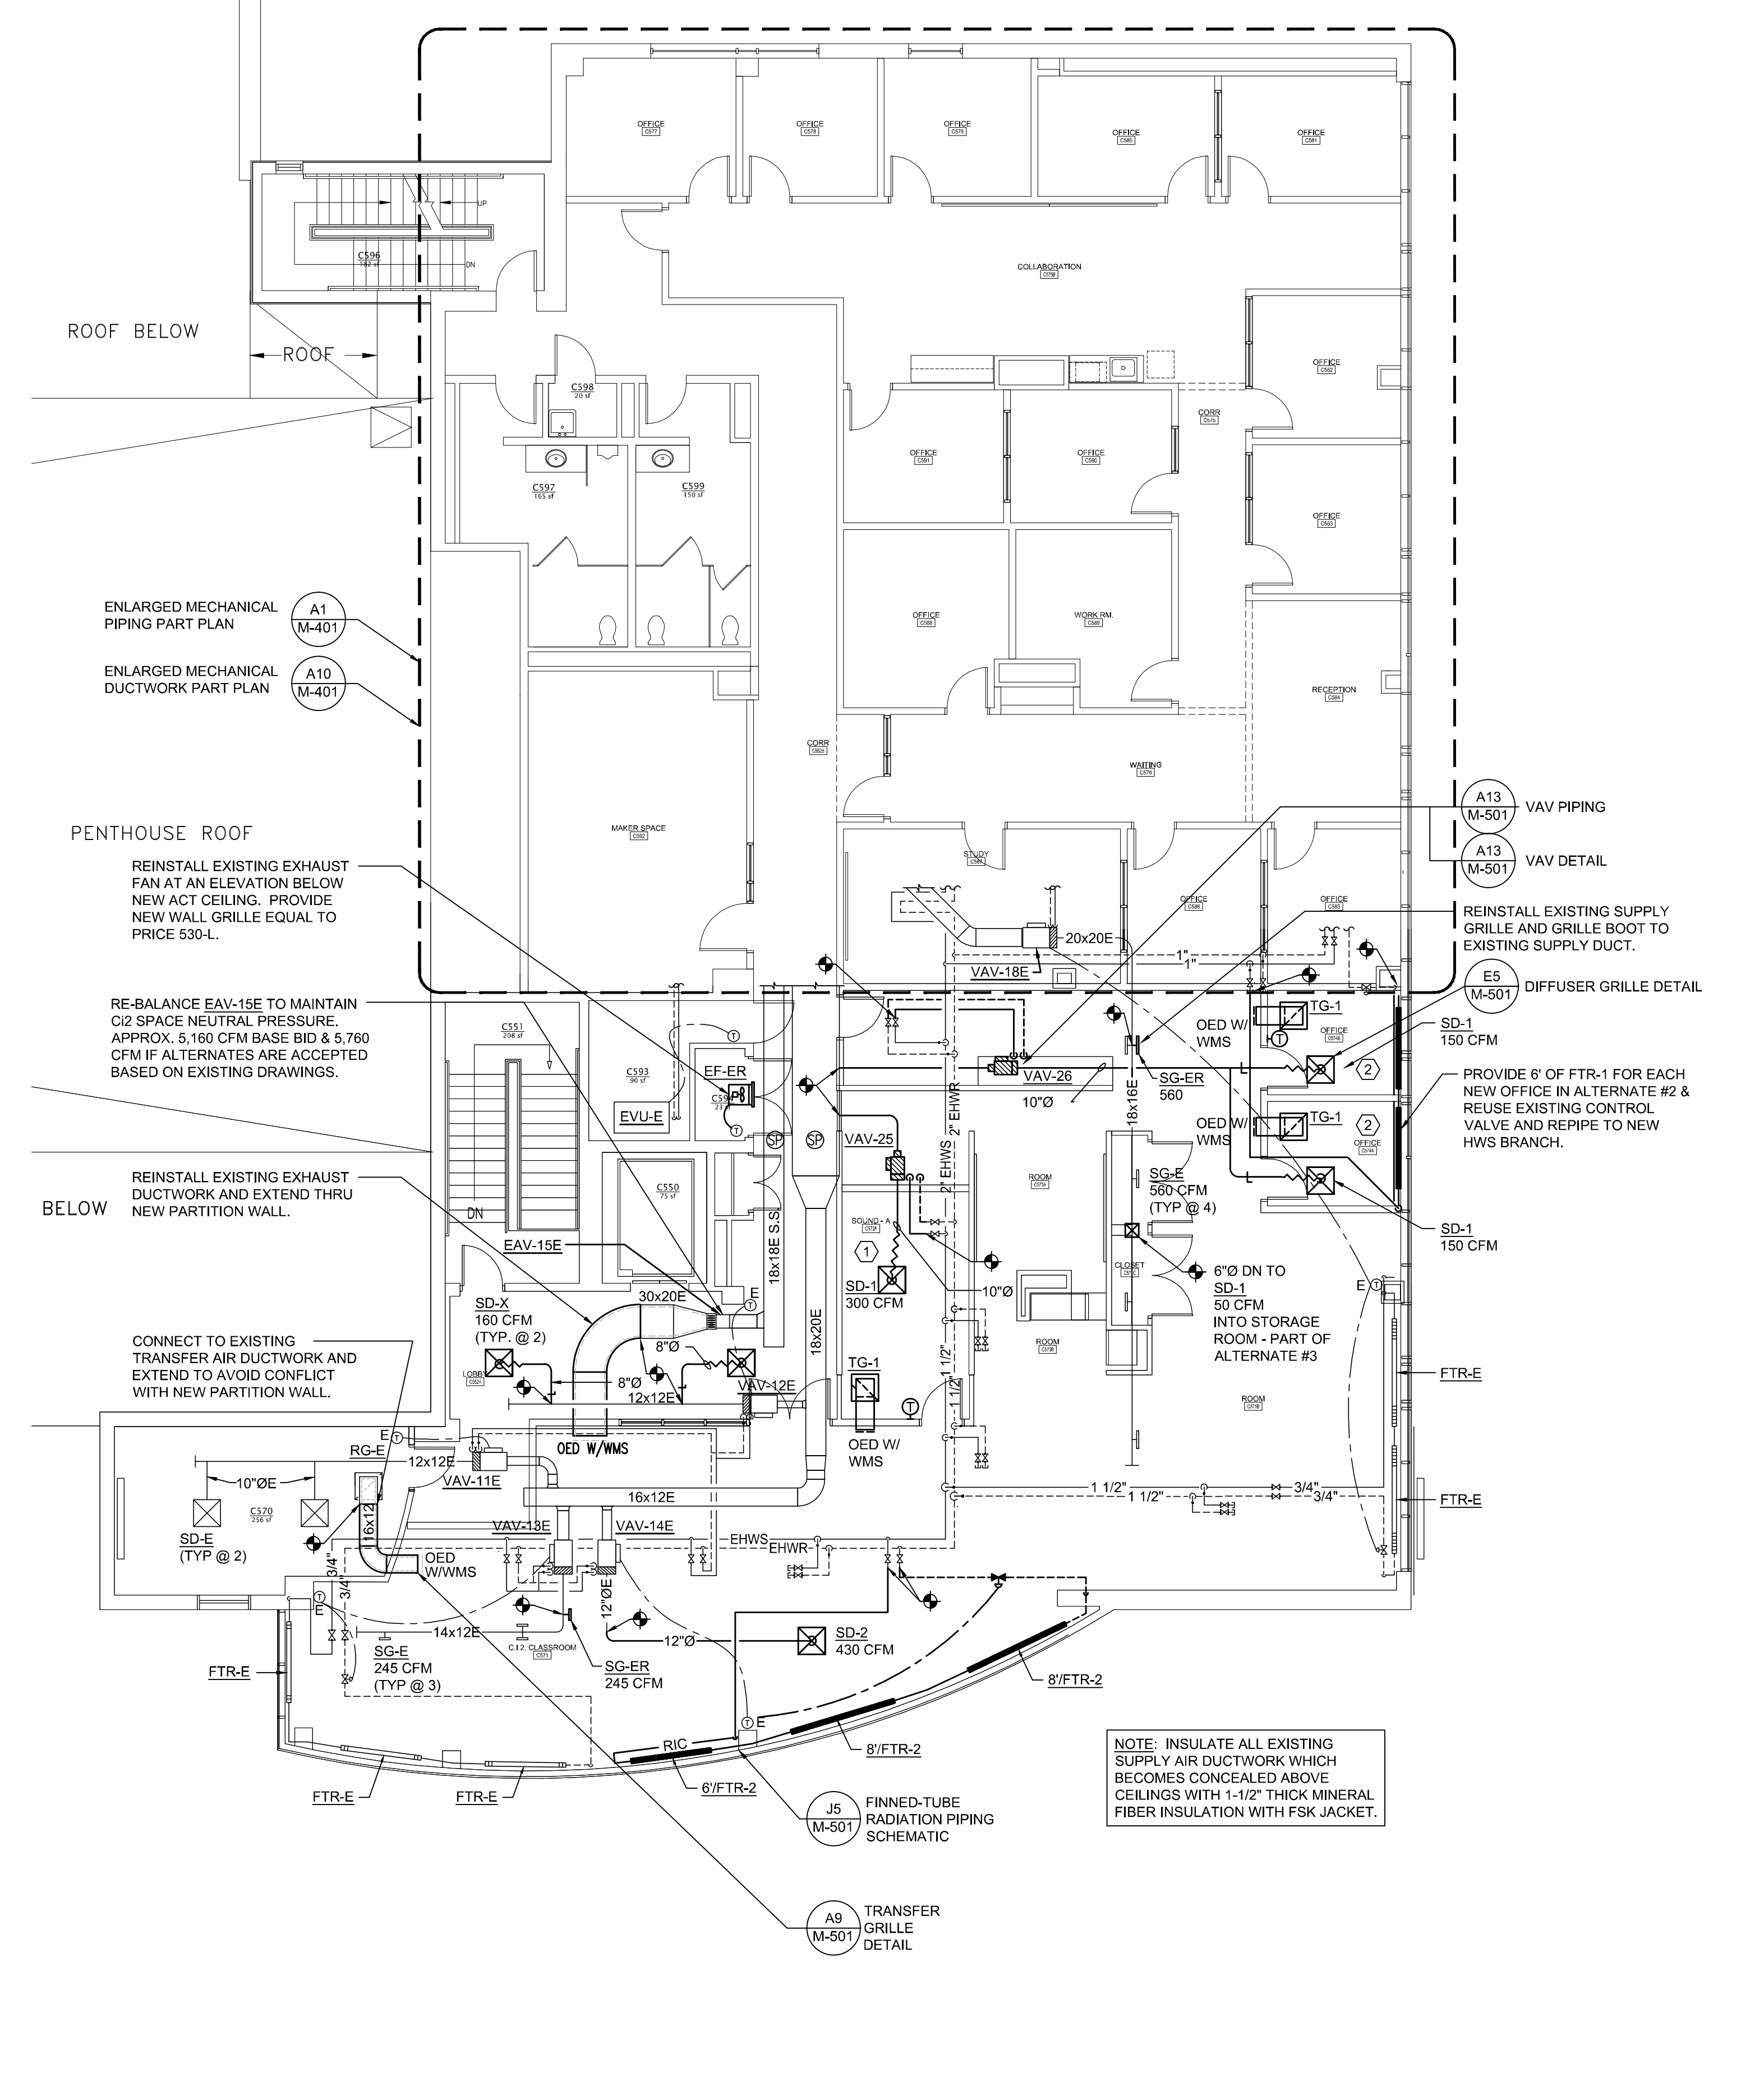

A1 FIFTH FLOOR MECHANICAL PLAN
 1/8" = 1'-0"

- TECHNICAL NOTES:**
- HVAC WORK SHOWN SERVING SOUND ROOM C572 IS PART OF ALTERNATE ITEM #1. ALL HVAC SYSTEMS REMAIN AS-IS IN THE BASE BID SCOPE.
 - HVAC WORK SHOWN SERVING OFFICE C574 IS PART OF ALTERNATE ITEM #2. IN ADDITION, EXISTING FINNED-TUBE RADIATION MUST BE RE-PIPED TO PROVIDE THE OFFICE WITH INDEPENDENT CONTROL. ALL HVAC SYSTEMS REMAIN AS-IS IN THE BASE BID SCOPE.
- GENERAL NOTES:**
- BRANCH VAV INLET DUCTWORK SHALL BE EQUAL TO VAV BOX INLET SIZE UNLESS NOTED OTHERWISE.
 - ALL HOT WATER SUPPLY & RETURN TO TERMINAL UNITS SHALL BE 3/4" UNLESS NOTED OTHERWISE.

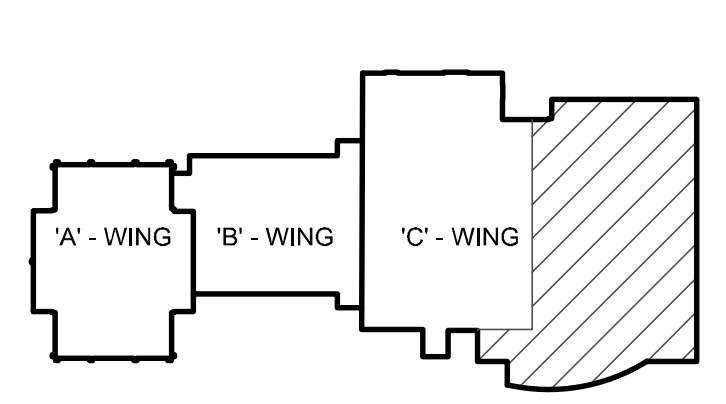

REV.	DESCRIPTION	DATE
0	BID DOCUMENTS	01-13-17

PROJECT NORTH

STATE OF MAINE ARCHITECTS & ENGINEERS
 2017-17

WBRC
 ARCHITECTS • ENGINEERS
 WWW.WBRC.COM
 BANGOR, MAINE 207-645-4511
 PORTLAND, MAINE 207-433-4511
 SALEM, MASSACHUSETTS 978-452-0757

USM SCIENCE BUILDING OFFICE RENOVATIONS
 PROJECT: PORTLAND, ME
FIFTH FLOOR MECHANICAL PLANS

SHEET TITLE: 4128.10 - M-105
 WBRC CAD FILE: 4128.10 GRAPHIC SCALE: 0"
 PROJECT No. AS NOTED
 SCALE: AS NOTED
 PROJECT MANAGER: MEJ SHEET No. 10
 DRAWN BY: AJR
 CHECKED BY: AJR
M-105
 © COPYRIGHT 2016 WBRC

1/12/2017 2:45 PM T:\20 PROJECTS - MAINE\101--4200\112810 USM SCIENCE BLDG CONSOLIDATION\2 DESIGN\WORKS\0500\112810-10-105 FIFTH FLOOR MECHANICAL PLANS.DWG ANDREW HODNICKI