

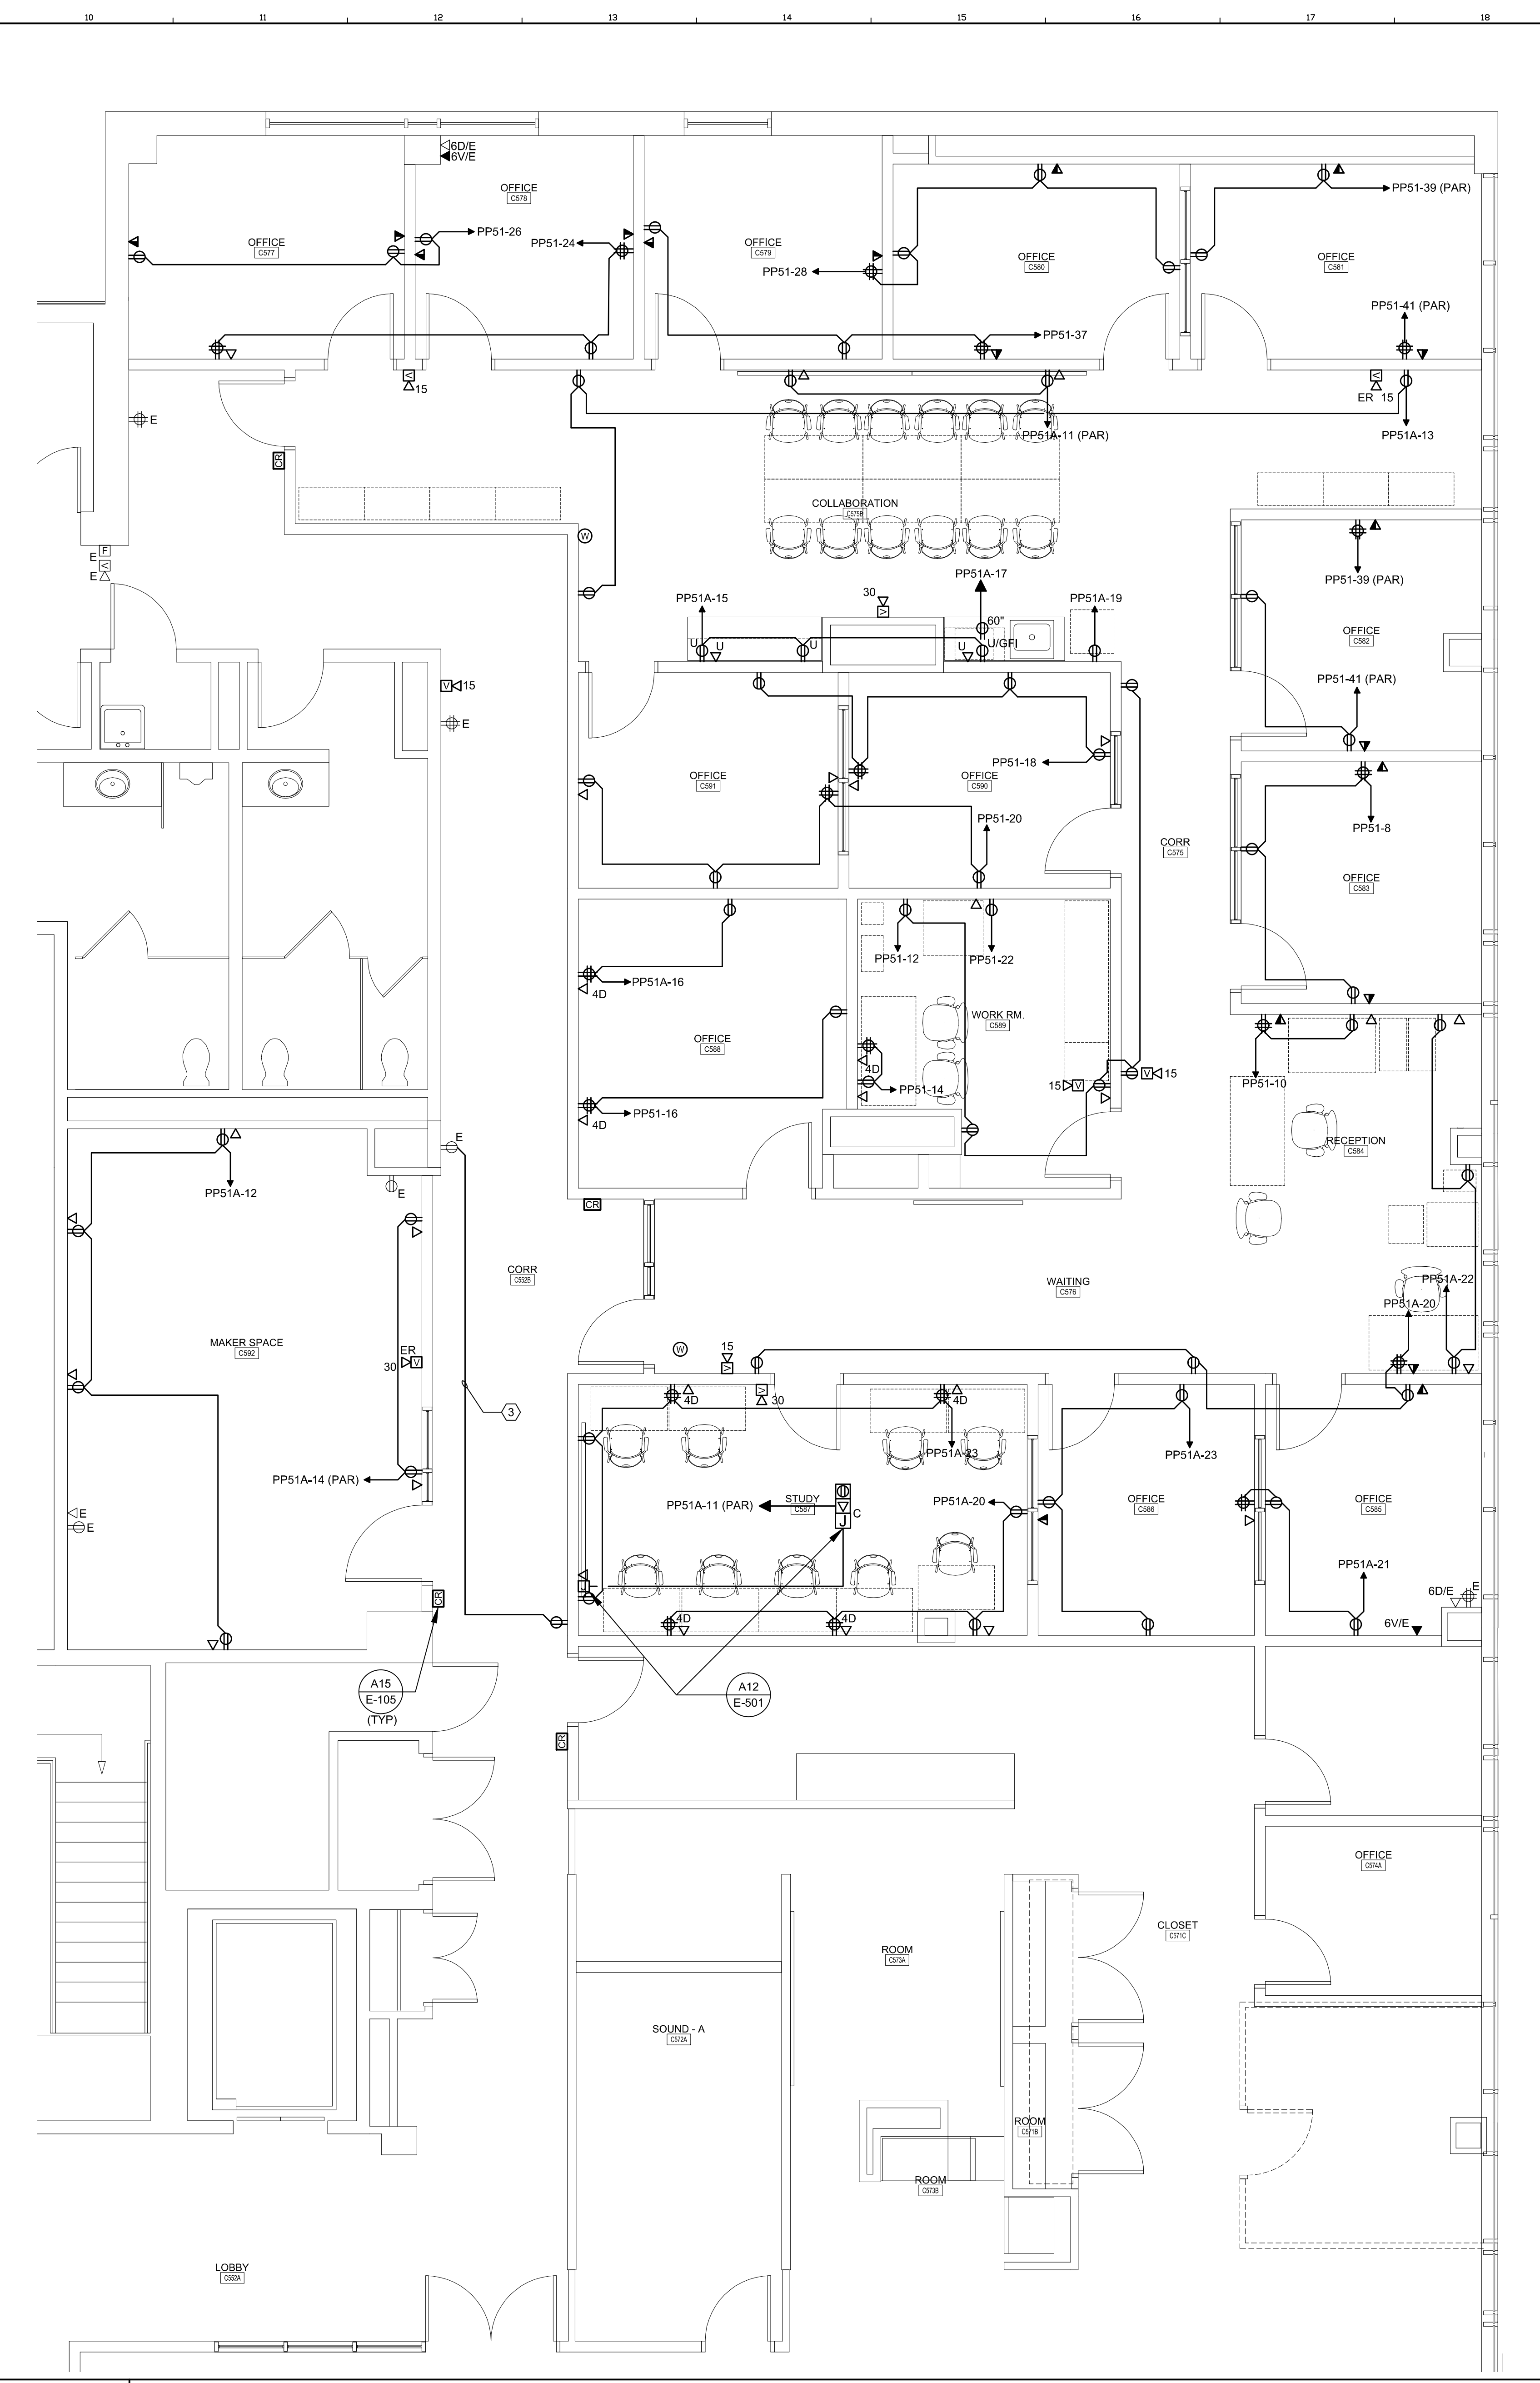


2/1/2017 7:49 AM T:\02 PROJECTS - MAINE\101-4200\1\2010 USM SCIENCE BLDG CONSULTATION 2 DESIGN\WORKS BLDG\USM SCIENCE BUILDING\WORKS\1\2010 E-401 ELECTRICAL ENLARGED PLANS.DWG DREW:HW/TE/SBERGHE

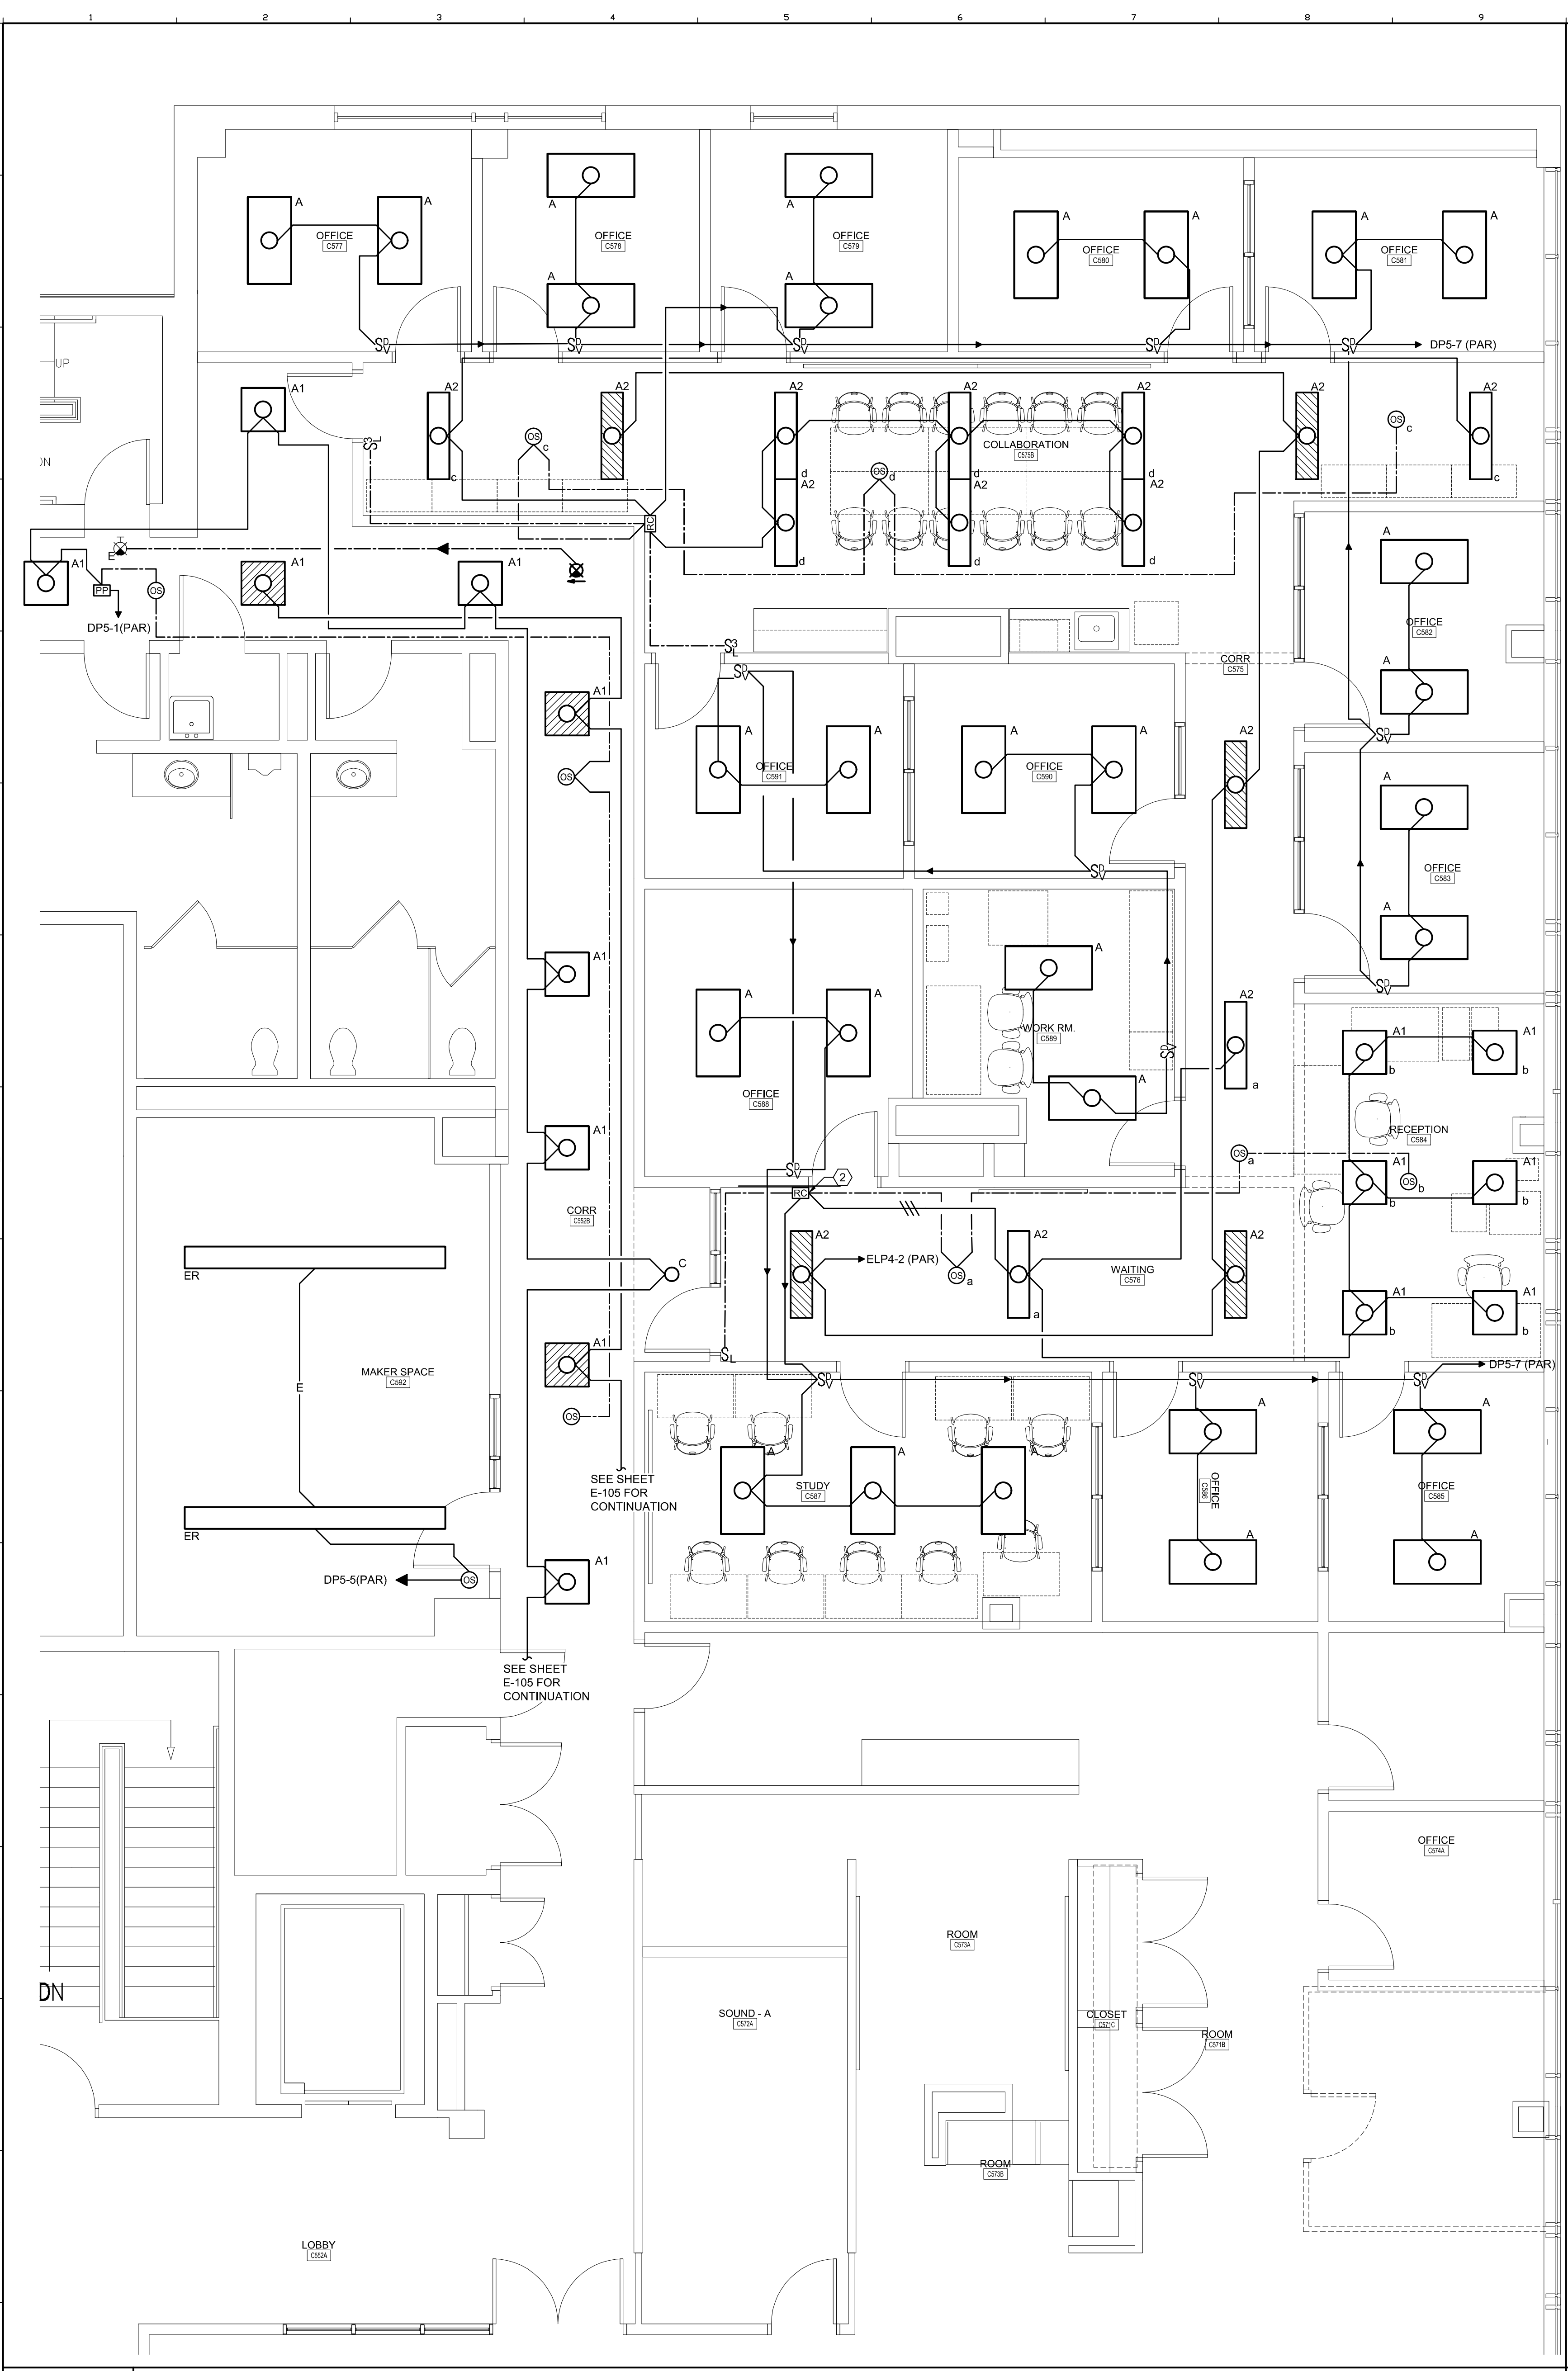


TECHNICAL NOTES:

- ① CONNECT EXISTING FIXTURES TO NEW CONTROL DEVICE.
- ② ROOM CONTROLLER NOTE FROM E-103.
- ③ CONNECT TO EXISTING POWER CIRCUIT.

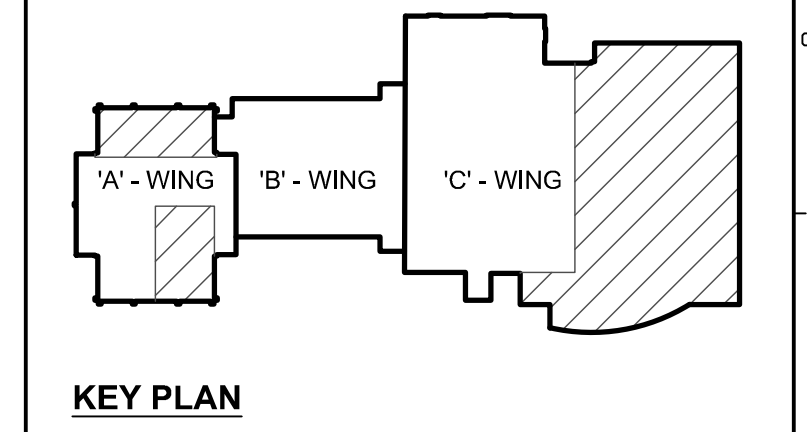

REV.	DESCRIPTION	DATE
0	BID DOCUMENTS	02-03-17

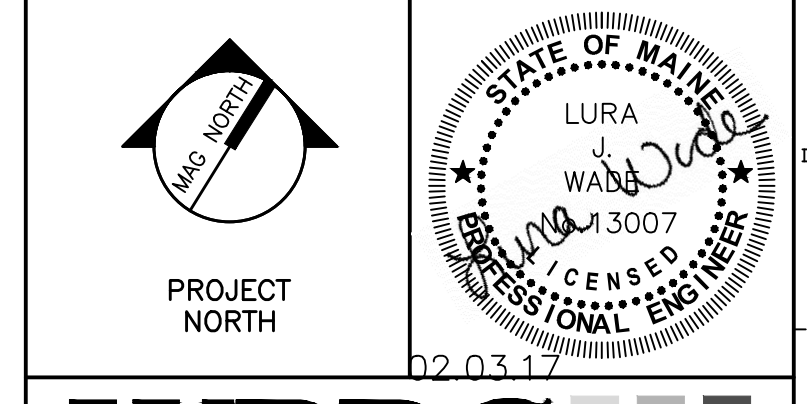

WBRC
ARCHITECTS • ENGINEERS
WWW.WBRC.AE.COM
BANGOR, MAINE 207-647-4511
PORTLAND, MAINE 207-428-4511
SAFETYVILLE, FLORIDA 941-556-0757

USM SCIENCE BUILDING OFFICE RENOVATIONS

PROJECT: PORTLAND, ME
ELECTRICAL ENLARGED PLANS

SHEET TITLE:	4128.10 - E-401
WBRC CAD FILE:	4128.10 GRAPHIC SCALE: 0"
PROJECT No.:	4128.10
SCALE:	AS NOTED
PROJECT MANAGER:	MEJ
DRAWN BY:	DVS
CHECKED BY:	LJW

A1 FIFTH FLOOR ENLARGED LIGHTING PLAN
1/4" = 1'-0"

A10 FIFTH FLOOR ENLARGED POWER PLAN
1/4" = 1'-0"