

PLUMBING FIXTURE SCHEDULE						
TAG	DESCRIPTION	FIXTURE	FAUCET/DRAIN	TRIM	SUPPORT	NOTES
WC-A	FLOOR MOUNTED ADA WATER CLOSET	AMERICAN STANDARD #2998.014, CADET ADA 16-1/2" H, VITREOUS CHINA, SIPHON JET TYPE, 1.6 GPF, WHITE	-	CHURCH #9500-SSC SEAT - WHITE	-	
LAV-A	WALL-HUNG LAVATORY - ADA	AMERICAN STANDARD #0355.012 "LUCERNE" VITREOUS CHINA, 20"x18", (2) HOLES ON 4" CENTERS.	CHICAGO #802-VXKCP FAUCET, McGUIRE #155WC DRAIN, OFFSET TAILPIECE, CHROME PLATED FINISHES	McGUIRE ANGLE STOPS, P-TRAP, ESCUTCHEONS AND RISERS-CHROME PLATED	JAY R. SMITH #0700	①

NOTES: ① INSULATE EXPOSED PIPING - TRUEBRO #102G.

PLUMBING FIXTURE CONNECTION SCHEDULE					
FIXTURE	CW	HW	WASTE	VENT	NOTES
FLUSH TANK WATER CLOSET	1/2"	-	3"	2"	
LAVATORY	1/2"	1/2"	1-1/2"	1-1/2"	
SINK	1/2"	1/2"	1-1/2"	1-1/2"	①

NOTES: ① ROUGH-IN CONNECTIONS; FIXTURE TO BE PROVIDED BY OWNER.

DOMESTIC WATER HEATER SCHEDULE										
TAG	FUEL	INPUT	RECOVERY RATE 65°F RISE	STORAGE TANK SIZE/GAL.	ELECTRICAL DATA		FLUE CONN. (in.)	OPERATING WEIGHT (lbs.)	TYPICAL UNIT MFR. & MODEL NO.	NOTES
					KW	VOLT/Ø				
HTR-1	ELEC	9.5 KW	1 GPM	N/A	9.5	240/1	N/A	3	EEMAX EX95	①



NOTES: ① MOUNT ON WALL BELOW LAV-A.

NOTES:


- SEE SHEET M-001 FOR LEGEND AND ABBREVIATIONS.
- EXISTING EQUIPMENT SHOWN IN APPROXIMATE LOCATIONS. FIELD VERIFY ACTUAL LOCATIONS.

KEYED NOTE:

① CONTRACTOR TO FIELD VERIFY LOCATIONS OF EXISTING PIPING.

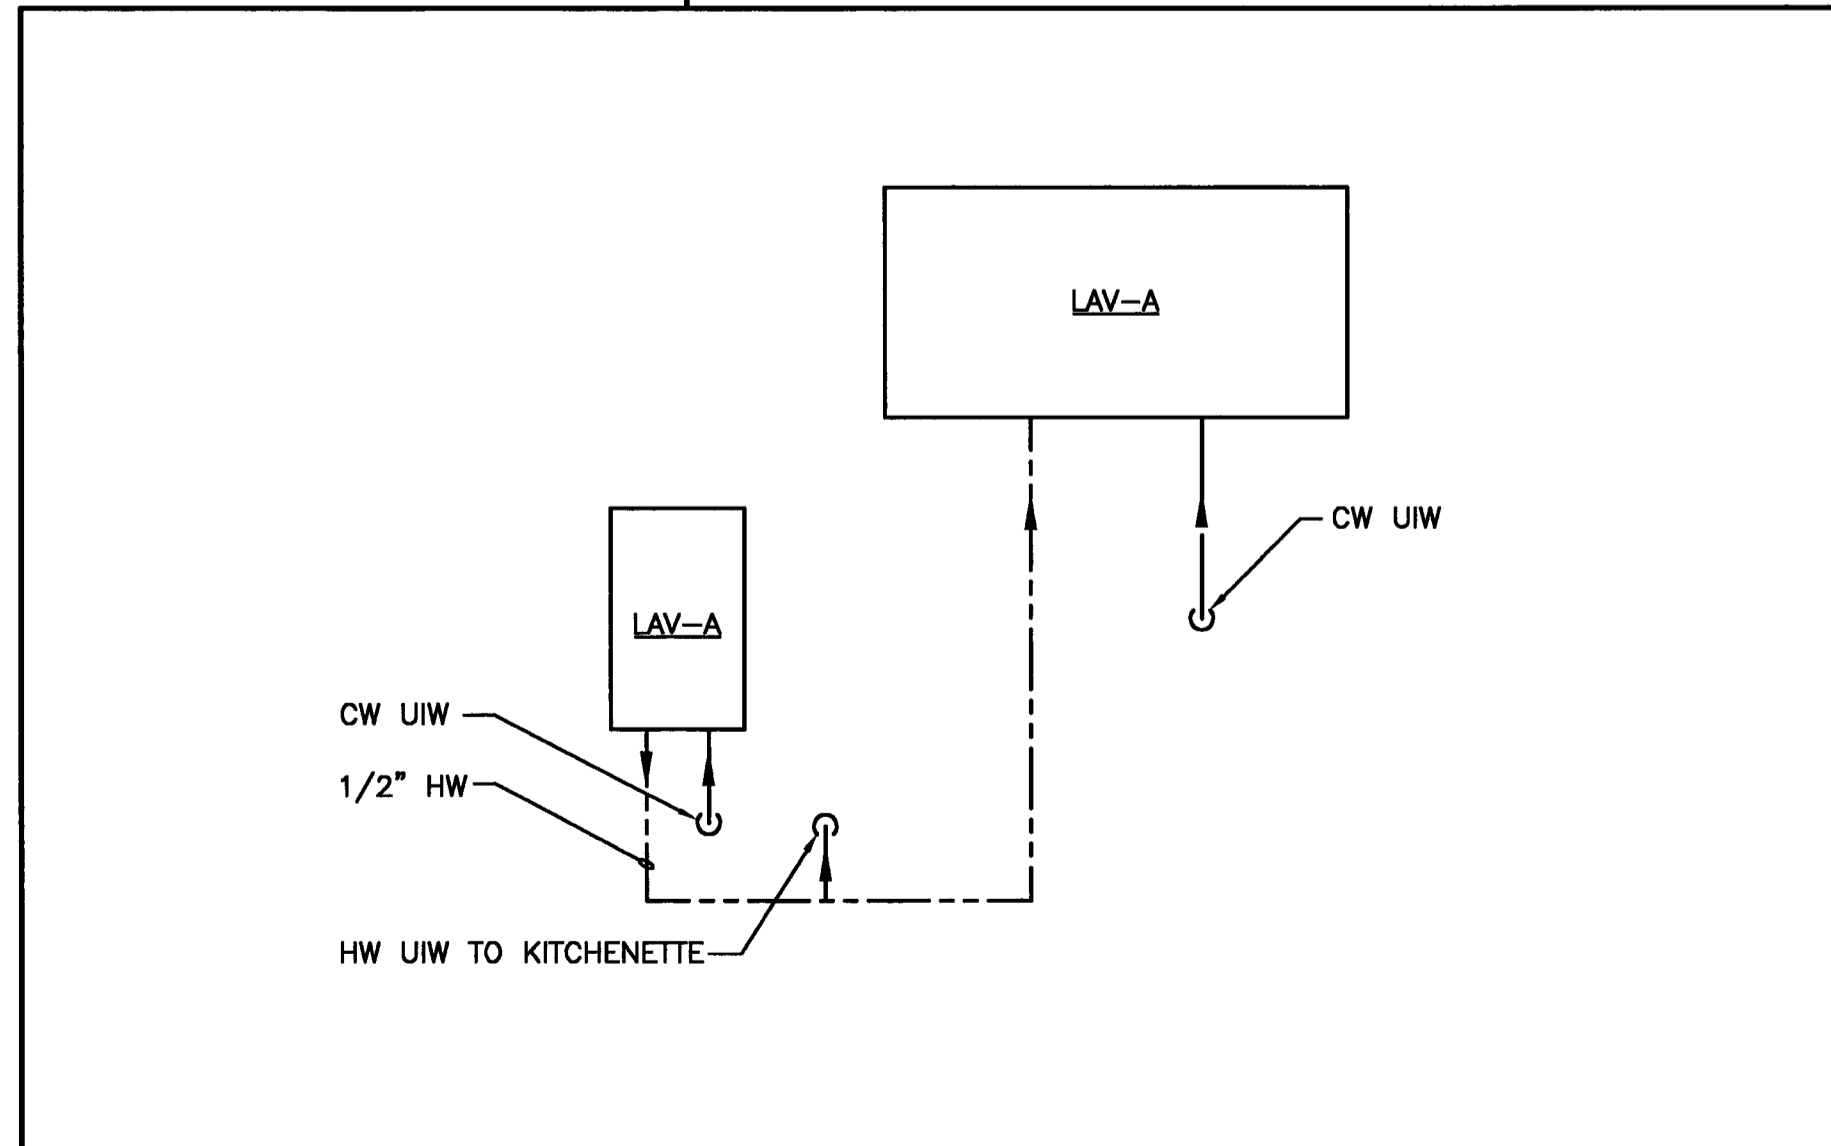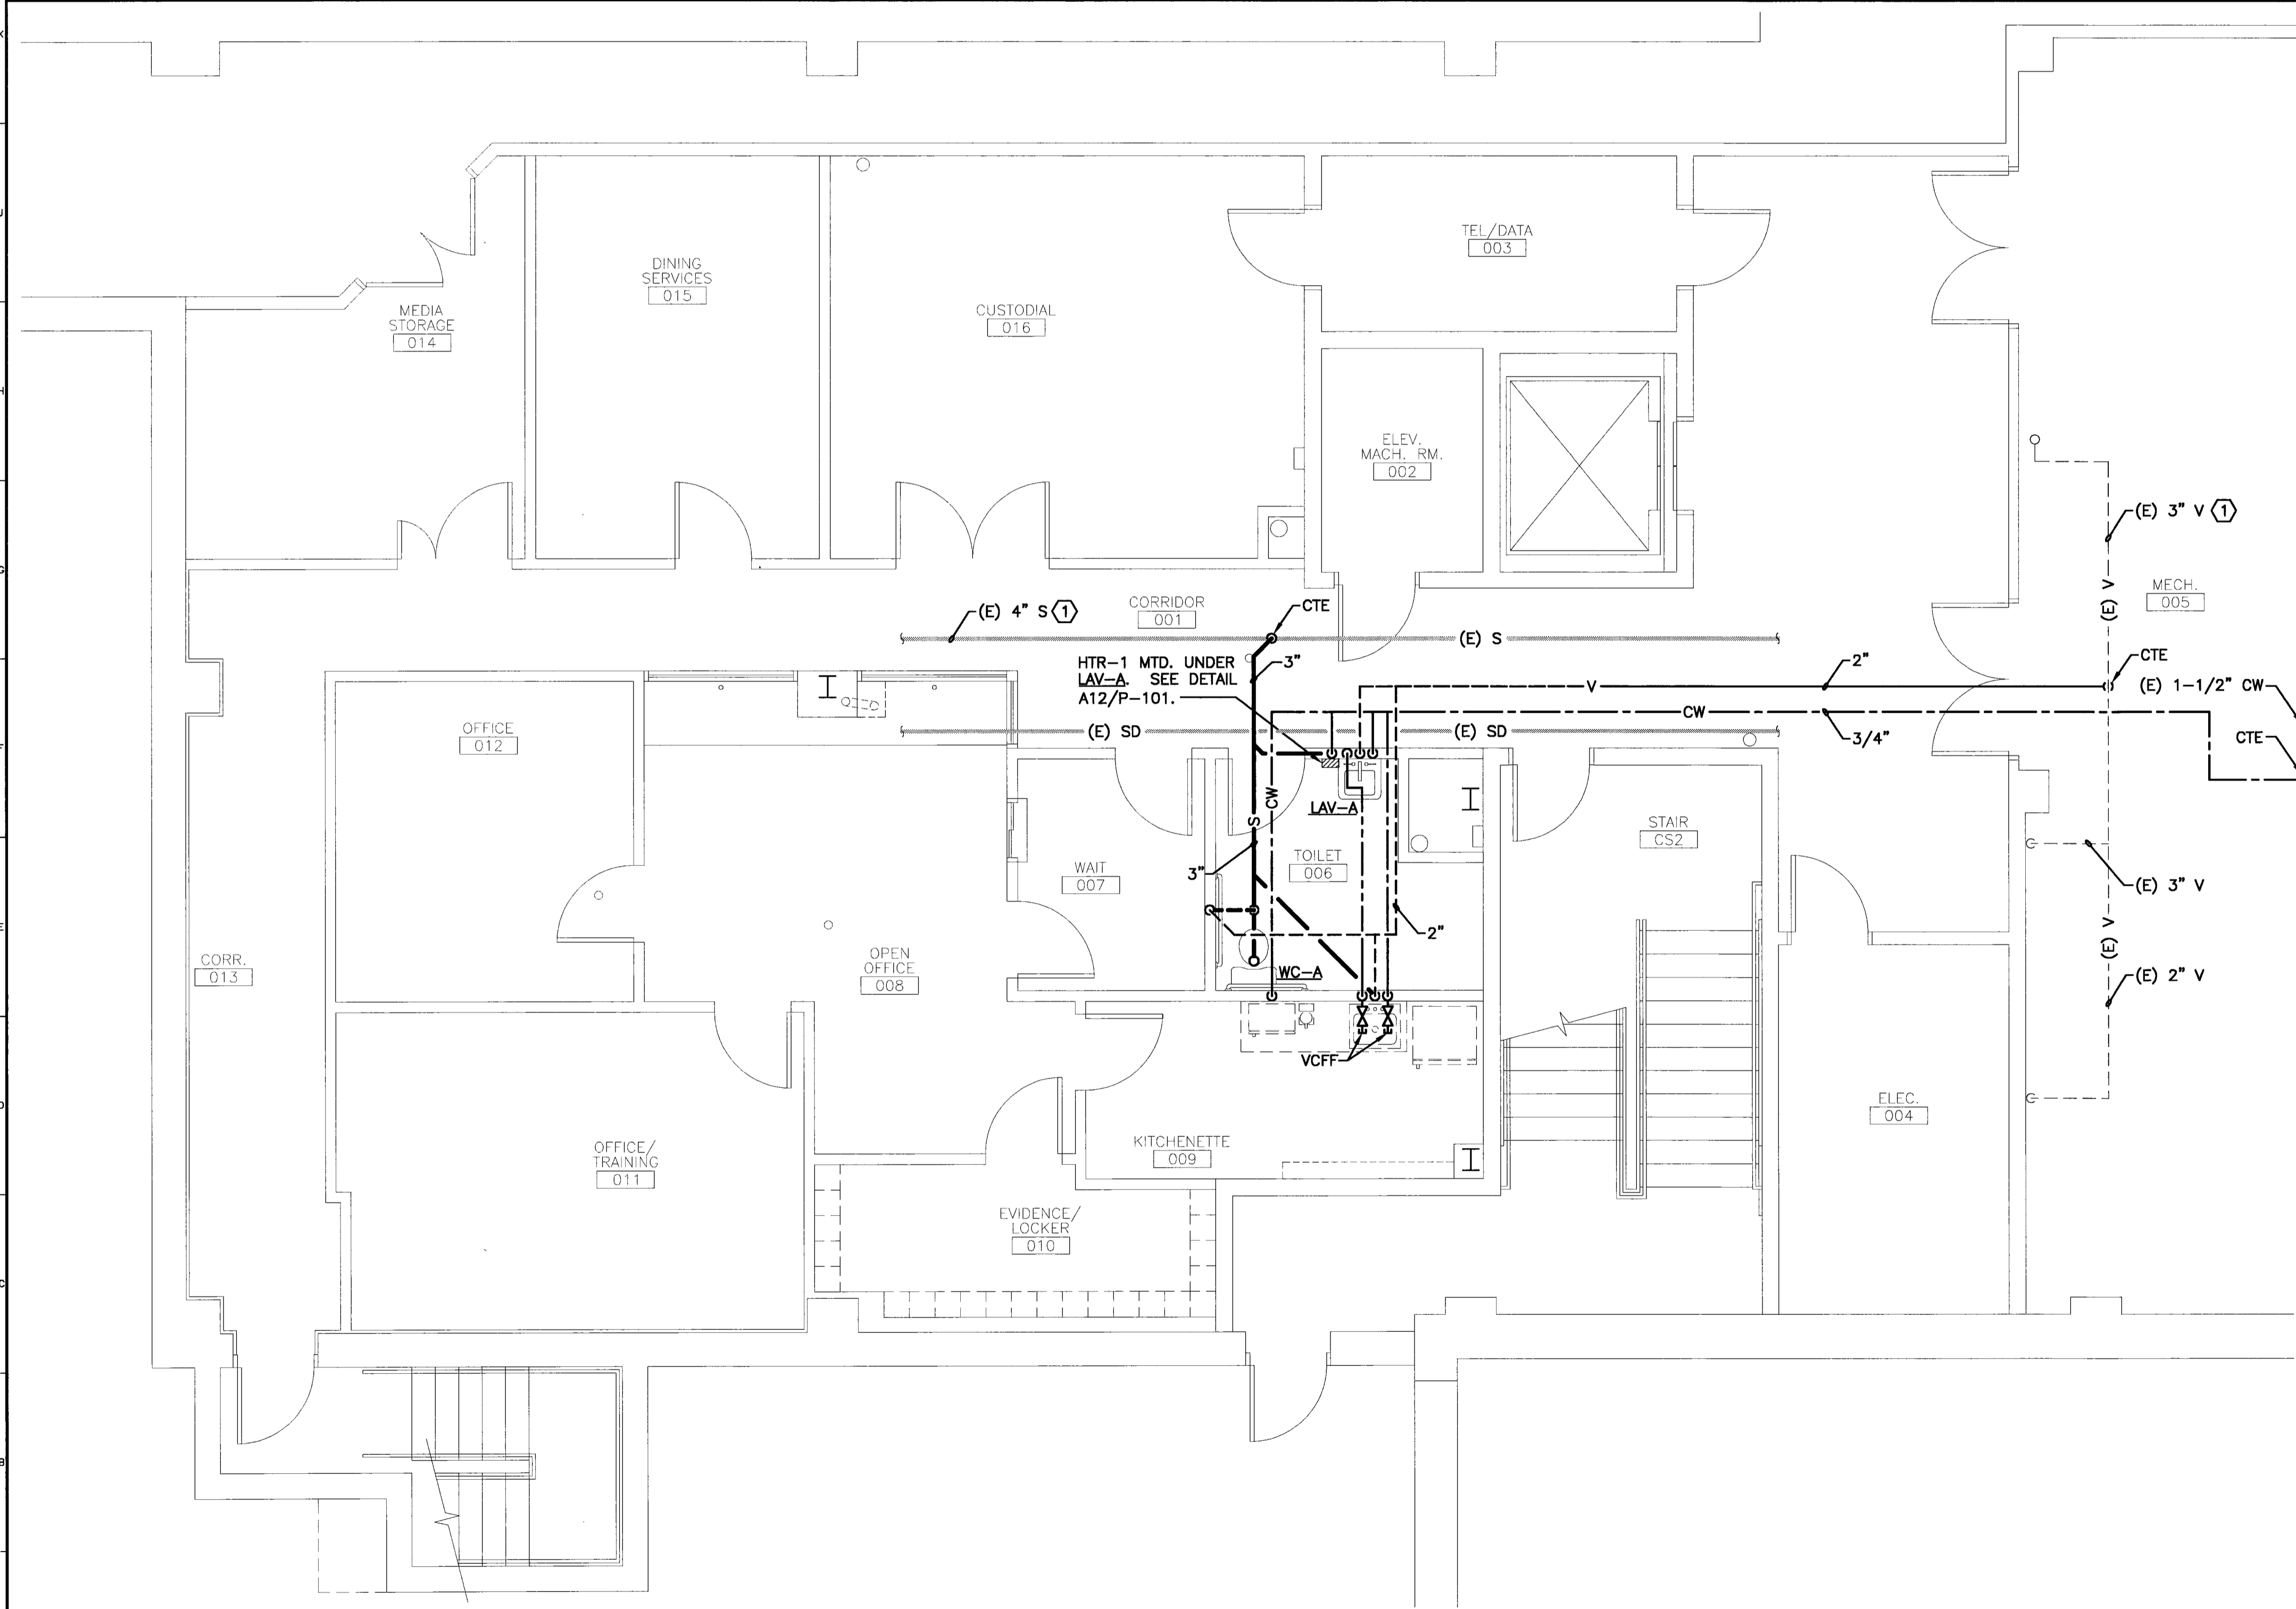

ARCHITECTURE ENGINEERING PLANNING
 SWRT
 144 Fore Street / P.O. Box 618
 Portland, Maine 04104
 tel. (207) 772-3846
 fax. (207) 772-1070

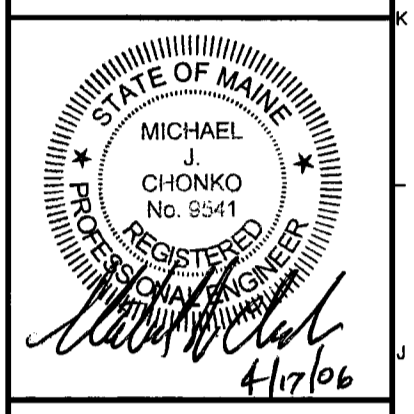

PROJECT TITLE:
**USM COMMUNITY EDUCATION CENTER
 LOWER LEVEL FIT-UP**
 PORTLAND, MAINE

CURRENT ISSUE STATUS:
**ISSUED FOR PRICING/PERMITTING
 4-18-06**

REV	DESCRIPTION	DATE
0	ISSUED FOR PRICING/PERMITTING	4-18-06

GRAPHIC SCALE:
 0" 1"

SCALE: 1/4"=1'-0"

PROJECT MANAGER: SLB
 JC/DRAWN BY: TCM/CAH
 A/E OF RECORD: MJC
 CAD FILE: P-101-06004
 PROJECT NO: 06004
 DATE: 4-18-06

SHEET TITLE:
**PLUMBING PLAN
 DETAIL &
 SCHEDULES**

SHEET No.
P-101

A1 BASEMENT PLAN
 1/4" = 1'-0"

A12 DOMESTIC HOT WATER SCHEMATIC
 1/4" = 1'-0"