


LIGHT FIXTURE SCHEDULE					
TYPE	DESCRIPTION	MFR.	LAMPS	MOUNTING	NOTES
A	2'x4', 3-LAMP PARABOLIC WITH 18 CELL 3" DEEP SEMI-SPECULAR LOUVER. 277V	COLUMBIA P424 SERIES	3-F32TB 3500K	RECESSED	
B	2x4 SPECIFICATION GRADE RECESSED TROFFER W/PATTERN A12 ACRYLIC LENS 277V	COLUMBIA 4PS SERIES	2-F32TB 3500K	RECESSED	

GENERAL NOTES:


- SEE SHEET E-001 FOR LEGEND AND GENERAL NOTES.
- LIGHTING BRANCH CIRCUIT LP1-42 IS INDICATED FOR DIAGRAMMATIC PURPOSES. COORDINATE ACTUAL CIRCUIT NUMBER WITH NEXT AVAILABLE BREAKER SPACE. PANELBOARD LP1 IS LOCATED IN ELECTRICAL 112. SEE POWER PLAN FOR LOCATION.

KEYED NOTE:

- EXISTING LIGHT FIXTURE TO REMAIN. RECONFIGURE SWITCHING FOR LOCAL CONTROL AS INDICATED.
- INSTALL EXISTING LIGHT FIXTURE REMOVED DURING DEMOLITION.
- NEW LOCATION OF LIGHT SWITCHES REMOVED DURING DEMOLITION. RECONFIGURE WIRING AS INDICATED.
- NEW LOCATION OF EXIT SIGN REMOVED DURING DEMOLITION. EXTEND EXISTING BRANCH CIRCUIT AS REQUIRED.
- FURNISH AND INSTALL NEW SINGLE POLE SWITCH TO REPLACE EXISTING 3-WAY SWITCH. RECONFIGURE WIRING AS INDICATED.

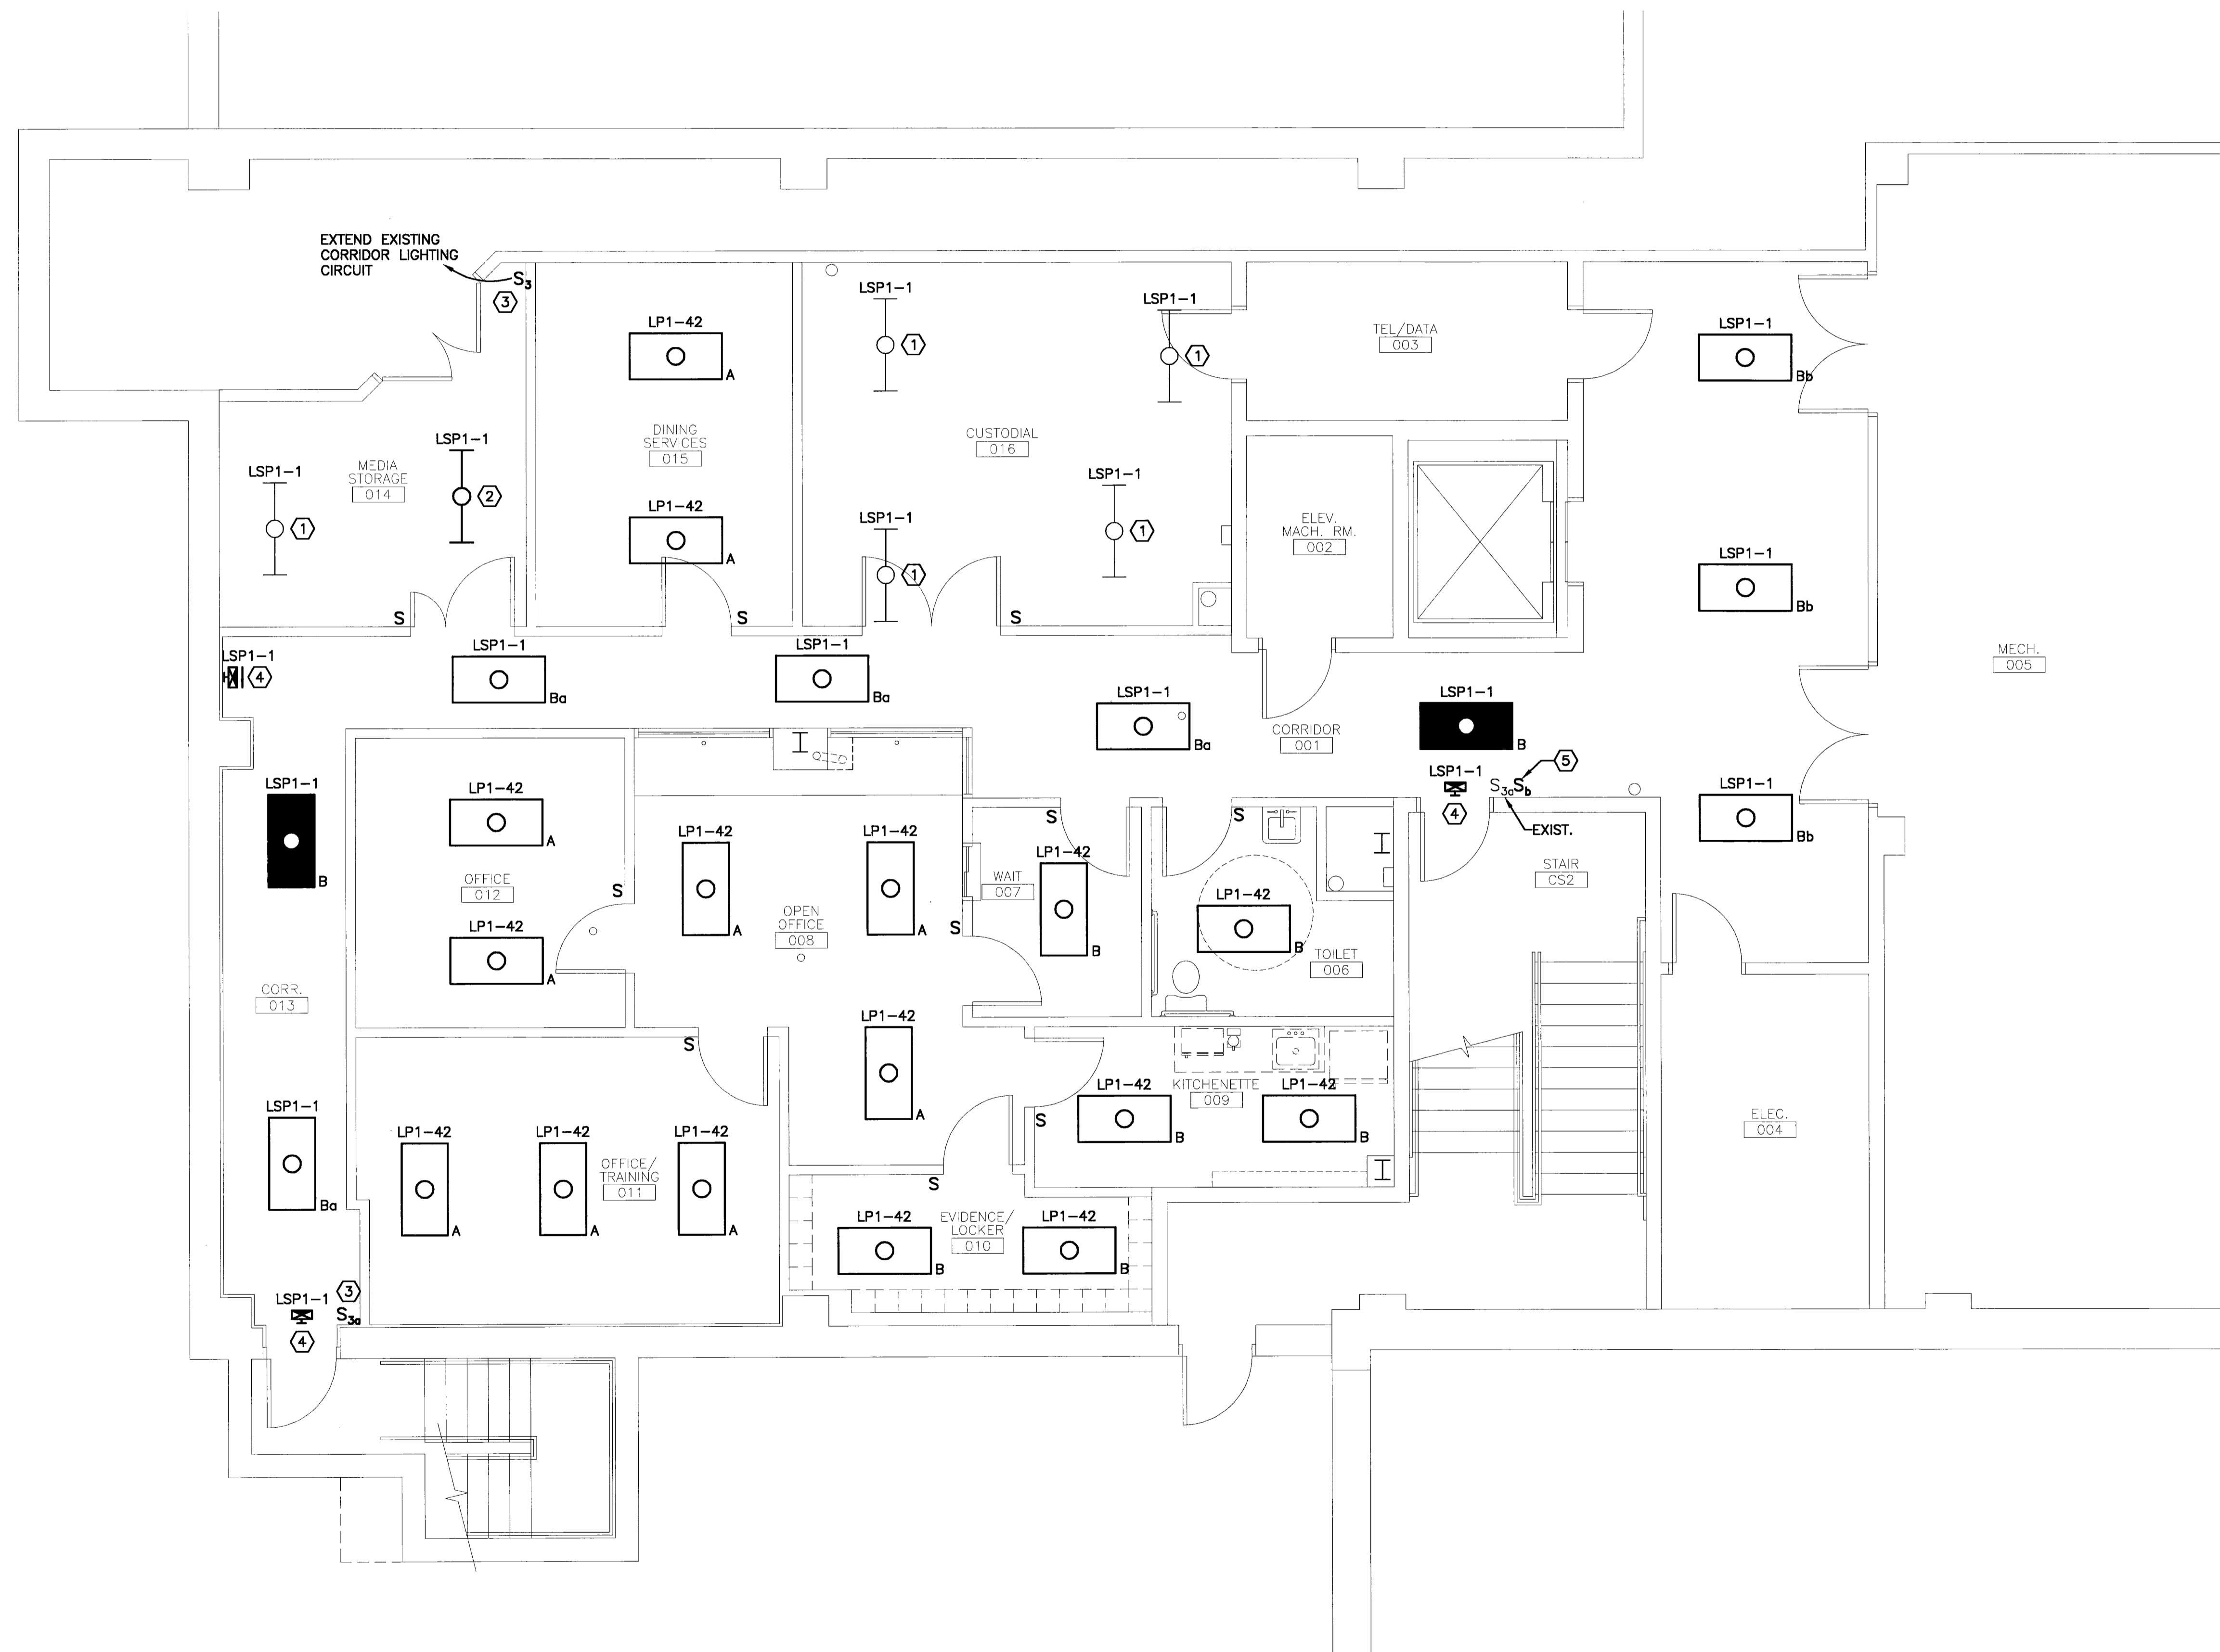

ARCHITECTURE ENGINEERING PLANNING
SMART
144 Fore Street/P.O. Box 618
Portland, Maine 04104
tel. (207) 772-3846
fax. (207) 772-1070

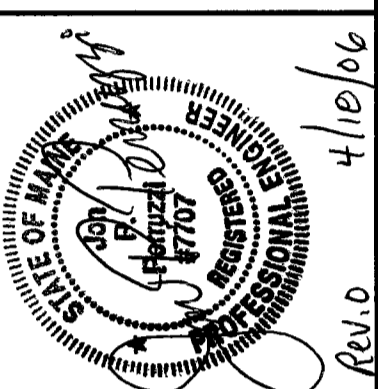

PROJECT TITLE: USM COMMUNITY EDUCATION CENTER LOWER LEVEL FIT-UP
PORTLAND, MAINE
CURRENT ISSUE STATUS: ISSUED FOR PRICING/PERMITTING
4-18-06

REV	DESCRIPTION	DATE
0	ISSUED FOR PRICING/PERMITTING	

GRAPHIC SCALE: 0" = 1"
SCALE: AS NOTED
PROJECT MANAGER: SLB
JC/DRAWN BY: MBD
A/E OF RECORD: JPP
CAD FILE: EL101-06004
PROJECT NO: 06004
DATE: 4-13-06
SHEET TITLE:

LIGHTING PLAN
SHEET No. EL101
© COPYRIGHT 2006 SMART INC.

A1 FLOOR PLAN

1/4" = 1'-0"