

GENERAL NOTES:

1. RE G1002 FOR GENERAL NOTES.

REFLECTED CEILING PLAN NOTES


1. RE RFS FOR CEILING HEIGHTS, TYPES, AND FINISHES, U.N.O.
2. FIRE SPRINKLERS SHALL BE LOCATED IN ALIGNMENT WITH OTHER CEILING ITEMS.
3. FIRE SPRINKLERS SHALL BE CENTERED IN CEILING TILE WHERE APPLICABLE.
4. FIRE SPRINKLERS SHALL BE PLACED TO COORDINATE WITH LIGHT FIXTURE POSITIONS INDICATED.
5. FIRE SPRINKLERS ARE SHOWN FOR COORDINATION ONLY. ADDITIONAL SPRINKLERS MAY BE REQUIRED FOR CODE COMPLIANCE, AS DETERMINED BY THE FIRE PROTECTION DESIGNER. SPRINKLERS MAY NOT BE SHOWN IN ALL AREAS WHERE REQUIRED. FIRE PROTECTION CONTRACTOR SHALL BE RESPONSIBLE FOR PROVIDING A COMPLETE AND FULLY CODE COMPLIANT SYSTEM, INCLUDING HEADS NOT INDICATED IN THIS DRAWING. RE: MECH.
7. EXCEPT WHERE INDICATED, CENTER CEILING GRIDS IN ROOMS. USE HALF TILES OR GREATER @ PERIMETERS AS POSSIBLE.
8. PROVIDE ACCESS PANELS AS REQUIRED IN GWB CEILINGS FOR ACCESS TO MECHANICAL VALVES/ CONTROLS. REFERENCE MECHANICAL.
9. RE: FLOOR PLANS FOR ADDITIONAL INFORMATION ON CEILING MOUNTED / RECESSED EQUIPMENT.
10. RELOCATE EXISTING LIGHT FIXTURES TO LOCATIONS SHOWN. NEW LAYOUT TO BE AS SHOWN. RE: ELEC.

RCP SYMBOL LEGEND

- 2x4 SUSPENDED CEILING PANEL AND GRID ASSEMBLY.
- 2x2 OPEN-CELL CEILING GRID ASSEMBLY WITH 1x1 PANELS.
- 2x4 SUSPENDED CEILING PANEL AND GRID ASSEMBLY.
- GWB CEILING.
- 2x2 LAY-IN LIGHT FIXTURE.
- 2x4 LAY-IN LIGHT FIXTURE.
- 1x4 LIGHT FIXTURE.
- FLOURESCENT STRIP FIXTURE.
- DOWN LIGHT.
- CEILING MOUNTED EXIT LIGHT.
- RETURN AIR GRILLE.
- SUPPLY AIR GRILLE.
- EXHAUST AIR GRILLE.
- SPRINKLER HEAD.
- CEILING MOUNTED SPEAKER.
- CEILING MOUNTED SMOKE DETECTOR.
- DISPLAY LIGHTING

REV.	DESCRIPTION	DATE
0	ISSUED FOR CONSTRUCTION	3-17-03

ISSUED FOR CONSTRUCTION
3-17-03
 CURRENT ISSUE STATUS:

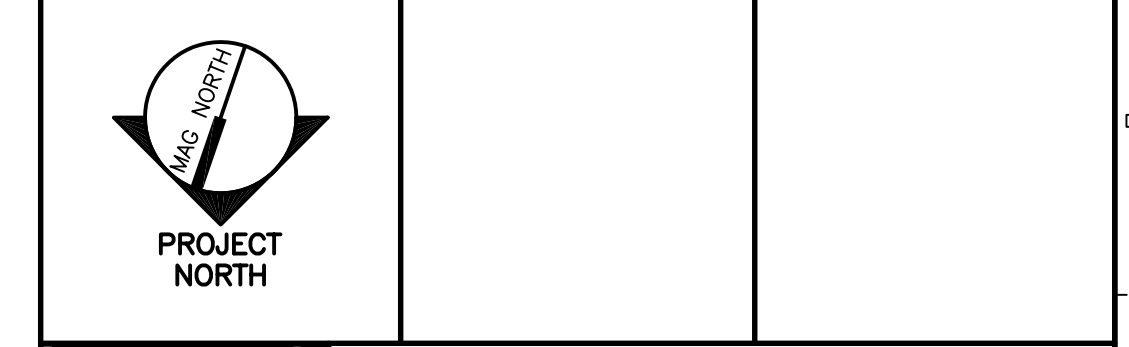

SMRT ARCHITECTURE ENGINEERING PLANNING
 SMRT
 144 Fore Street/P.O. Box 618
 Portland, Maine 04104
 tel. (207) 772-3846
 fax. (207) 772-1070

GLICKMAN LIBRARY
UNIVERSITY OF SOUTHERN MAINE
 PORTLAND, MAINE

PROJECT:
SIXTH FLOOR REFLECTED CEILING PLAN

SHEET TITLE:	SCALE: 1/8"=1'-0"	DATE: 3-17-03
PROJECT MANAGER: SLB	JOB CAP/DRAWN: CTB	GRAPHIC SCALE: 0" 1"
A/E OF RECORD: JLH	SMRT CAD FILE: AE113-99092	SHEET No.
PROJECT No. 99092		AE113