


**NOTE:**  
 1. SEE SHEET E-001 FOR LEGEND AND GENERAL NOTES.

**KEYED NOTE:**  
 ① MECHANICAL EQUIPMENT TO BE REMOVED BY OTHERS. REMOVE CONDUIT AND WIRE BACK TO PANELBOARD.

0	ISSUED FOR CONSTRUCTION	3-17-03
REV.	DESCRIPTION	DATE

**ISSUED FOR CONSTRUCTION**  
**3-17-03**

CURRENT ISSUE STATUS:

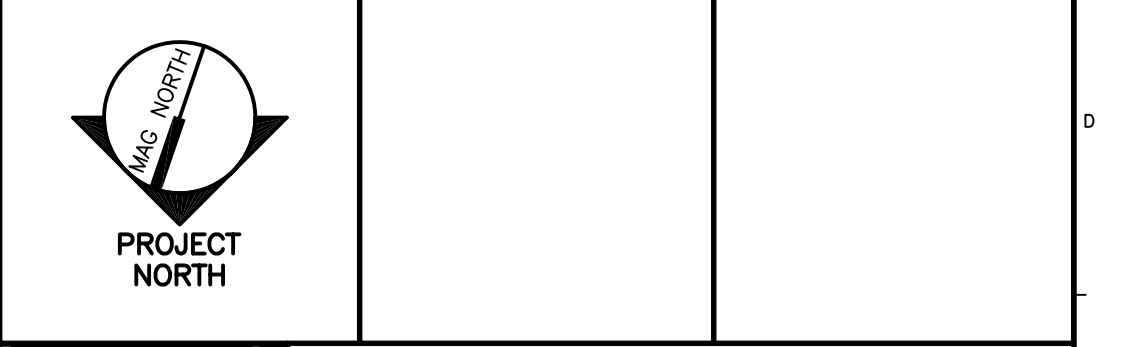

**SMRT** ARCHITECTURE ENGINEERING PLANNING  
 SMRT  
 144 Fore Street/P.O. Box 618  
 Portland, Maine 04104  
 tel. (207) 772-3846  
 fax. (207) 772-1070

**GLICKMAN LIBRARY**  
**UNIVERSITY OF SOUTHERN MAINE**  
 PORTLAND, MAINE

PROJECT:  
**SEVENTH FLOOR**  
**POWER DEMOLITION PLAN**

SHEET TITLE:	SCALE: 1/8"=1'-0"	DATE:
PROJECT MANAGER: SLB	JOB CAP/DRAWN: CTB/JAC	GRAPHIC SCALE: 0" 1"
A/E OF RECORD: JPP	SMRT CAD FILE: ED117-99092	SHEET No.
PROJECT No. 99092		<b>ED117</b>

**A1** SEVENTH FLOOR PLAN  
 1/8"=1'-0"