

**NOTES:**

1. SEE SHEET E-001 FOR LEGEND AND GENERAL NOTES.
2. LIGHTS SHOWN ON DEMO PLANS CAN BE RE-USED WHERE NEW LIGHTS OF THE SAME TYPE ARE SHOWN.
3. PROVIDE KEY SWITCH SKc. IT WILL CONTROL SOME EMERGENCY LIGHTS THAT WERE PREVIOUSLY CONTROLLED BY MOTION SENSOR. ALL WORK ASSOCIATED WITH THE ADDITION OF THIS KEY SWITCH, INCLUDING ALL WIRING, SHALL BE PRICED AS ALTERNATE #3.


**KEYED NOTES:**

- ① EXISTING FIXTURE TO BE CONTROLLED FROM NEW KEYED SWITCH SKc AND CIRCUIT EP3-5. DISCONNECT FROM EXISTING CIRCUIT AND MOTION CONTROL.
- ② CIRCUIT HV3A-2.
- ③ RELOCATED CONTROL UNIT.

0	ISSUED FOR CONSTRUCTION	3-17-03
REV.	DESCRIPTION	DATE

**ISSUED FOR CONSTRUCTION**  
**3-17-03**

CURRENT ISSUE STATUS:

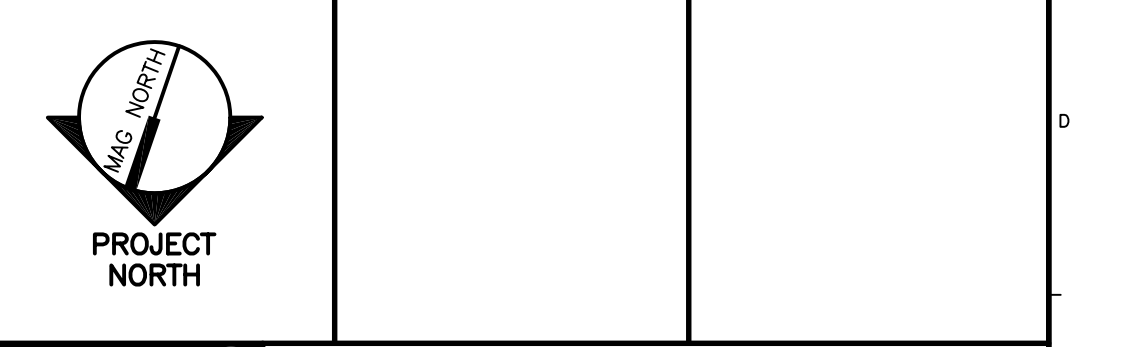

**SMRT** ARCHITECTURE ENGINEERING PLANNING  
 144 Fore Street/P.O. Box 618  
 Portland, Maine 04104  
 tel. (207) 773-3846  
 fax. (207) 772-1070

**GLICKMAN LIBRARY**  
**UNIVERSITY OF SOUTHERN MAINE**  
 PORTLAND, MAINE

**THIRD FLOOR**  
**LIGHTING PLAN**

SHEET TITLE:	SCALE: 1/8"=1'-0"	DATE:
PROJECT MANAGER: SLB	JOB CAP/DRAWN: CTB/JAC	GRAPHIC SCALE: 0" 1"
A/E OF RECORD: JPP	SMRT CAD FILE: EL103-99092	SHEET No.
PROJECT No. 99092		<b>EL103</b>

**A1** THIRD FLOOR PLAN  
 1/8"=1'-0"