

**NOTES:**

1. SEE SHEET E-001 FOR LEGEND AND GENERAL NOTES.
2. CONTRACTOR TO PROVIDE 50A, 3 POLE BREAKER FOR CIRCUITS 25, 27 & 29 IN PANEL HV2A.


**KEYED NOTE:**

- 1 PROVIDE CONDUIT BETWEEN CEILING MOUNTED JUNCTION BOX AND PANEL LV2B FOR FUTURE WIRELESS TRANSCEIVER.

0	ISSUED FOR CONSTRUCTION	3-17-03
REV.	DESCRIPTION	DATE

**ISSUED FOR CONSTRUCTION**  
**3-17-03**

CURRENT ISSUE STATUS:

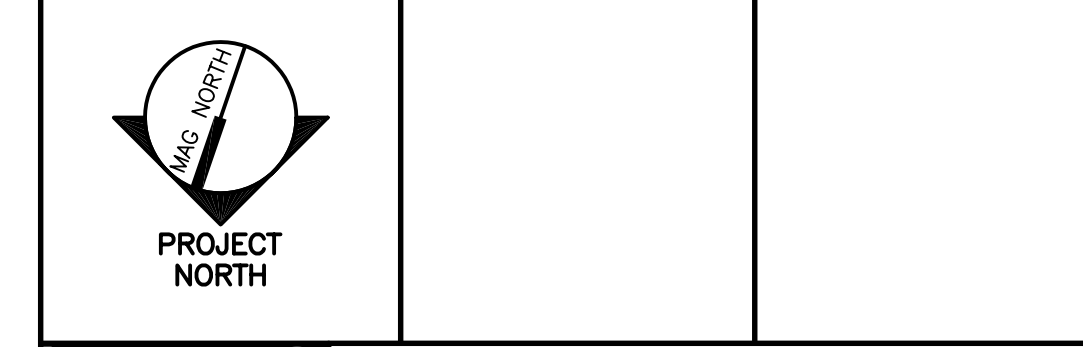

**SMRT** ARCHITECTURE ENGINEERING PLANNING  
 SMRT  
 144 Fore Street/P.O. Box 618  
 Portland, Maine 04104  
 tel. (207) 772-3846  
 fax. (207) 772-1070

**GLICKMAN LIBRARY**  
**UNIVERSITY OF SOUTHERN MAINE**  
 PORTLAND, MAINE

PROJECT:  
**SECOND FLOOR**  
**POWER PLAN**

SHEET TITLE:	SCALE: 1/8"=1'-0"	DATE:
PROJECT MANAGER: SLB	GRAPHIC SCALE: 0" 1"	
JOB CAP/DRAWN: CTB/JAC		
A/E OF RECORD: JPP	SHEET No.	
SMRT CAD FILE: EP102-99092		
PROJECT No. 99092		<b>EP102</b>