

NOTES:

1. SEE SHEET E-001 FOR LEGEND AND GENERAL NOTES.
2. CONTRACTOR TO PROVIDE 50A, 3 POLE BREAKER FOR CIRCUITS 25, 27 & 29 IN PANEL HV3A.


KEYED NOTE:

- ① PROVIDE CONDUIT BETWEEN CEILING MOUNTED JUNCTION BOX AND PANEL LV3B FOR FUTURE WIRELESS TRANSCEIVER.

0	ISSUED FOR CONSTRUCTION	3-17-03
REV.	DESCRIPTION	DATE

ISSUED FOR CONSTRUCTION
3-17-03

CURRENT ISSUE STATUS:

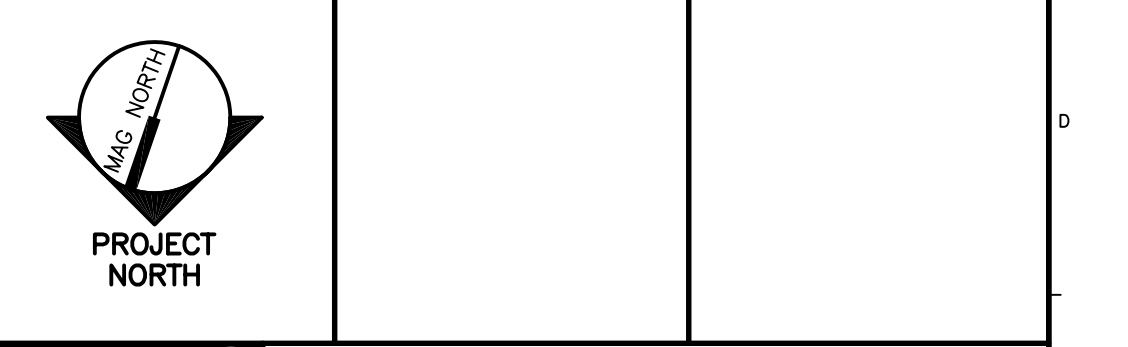

SMRT ARCHITECTURE ENGINEERING PLANNING
 SMRT
 144 Fore Street/P.O. Box 618
 Portland, Maine 04104
 tel. (207) 772-3846
 fax. (207) 772-1070

GLICKMAN LIBRARY
UNIVERSITY OF SOUTHERN MAINE
 PORTLAND, MAINE

THIRD FLOOR
POWER PLAN

SHEET TITLE:	1/8"=1'-0"	DATE:
PROJECT MANAGER:	SLB	GRAPHIC SCALE:
JOB CAP/DRAWN:	CTB/JAC	1"
A/E OF RECORD:	JPP	SHEET No.
SMRT CAD FILE:	EP103-99092	EP103
PROJECT No.	99092	