


- NOTES:**
- SEE E-001 FOR LEGEND AND GENERAL NOTES.
 - ALL WORK ASSOCIATED WITH BOILER B-4, ASSOCIATED INJECTION PUMP F-14 AND PUMPS P-9 & P-10 ASSOCIATED WITH CHILLER ACCH-4 SHOULD BE PRICED AS ALTERNATE #4.
 - VAV BOXES VAV-710 THROUGH VAV-715 EACH REQUIRE 120V POWER. CIRCUIT NUMBER LV7A-36.
 - ALL WORK ASSOCIATED WITH FIBEROPTIC CASE LIGHTING AT CORRIDOR 713 TO BE PRICED AS ALTERNATE #5.

- KEYED NOTES:**
- MOUNT RECEPTACLES 6" ABOVE COUNTER TOP.
 - PROVIDE POWER TO TOILET/URINAL ELECTRONIC SENSOR.
 - PROVIDE POWER TO HAND DRYER.
 - MOUNT RECEPTACLE 48" AFF FOR REFRIGERATOR.
 - PROVIDE CONDUIT BETWEEN CEILING MOUNTED JUNCTION BOX AND PANEL LV7B FOR FUTURE WIRELESS TRANSCEIVER.
 - 3 KVA 277-120/240V TRANSFORMER ABOVE. 30A FUSED SWITCH WITH 20 AMP FUSES BELOW. FOR BOILER #4.
 - EP7A-8 (VIA TRANSFORMER)
 - PROVIDE POWER TO MOTORIZED SCREEN. CIRCUIT LV7A-13.
 - ILLUMINATOR TO BE MOUNTED IN THE BOTTOM OF THE DISPLAY CASE FOR FIBEROPTIC LIGHTING. REFER TO ARCHITECTURAL PLANS FOR FIBER ROUTING AND FIXTURE PLACEMENT.
 - SWITCH FOR DISPLAY CASE LIGHTING.
 - PROVIDE POWER TO OWNER SUPPLIED SOUND SYSTEM AMPLIFIER.
 - WINDOW SHADE & CONTROL SYSTEM COMPONENTS (WINDOW SHADES, GROUP CONTROL SYSTEM AND MOMENTARY CONTACT SWITCHES) FURNISHED BY OTHERS. (REFER TO DIVISION 12 SPECIFICATION). ELECTRICAL CONTRACTOR TO SUPPLY 120V POWER TO SHADE MOTORS. TEN SHADE UNITS. TWO MOTORS/SHADES PER UNIT. SIX GROUP CONTROLLERS TO BE INSTALLED IN CHAIR/TABLE STORAGE. PROVIDE LOW VOLTAGE WIRING BETWEEN GROUP CONTROLLERS, SWITCHES AND SHADES. ONE SWITCH TO CONTROL ALL ROOM MESH SHADES AND ONE SWITCH TO CONTROL ALL ROOM DARKENING SHADES. MESH SHADES CIRCUIT # LV7B-4. ROOM DARKENING SHADES CIRCUIT # LV7B-6. GROUP CONTROL CIRCUIT # LV7B-2.

0	ISSUED FOR CONSTRUCTION	3-17-03
REV.	DESCRIPTION	DATE

ISSUED FOR CONSTRUCTION
3-17-03

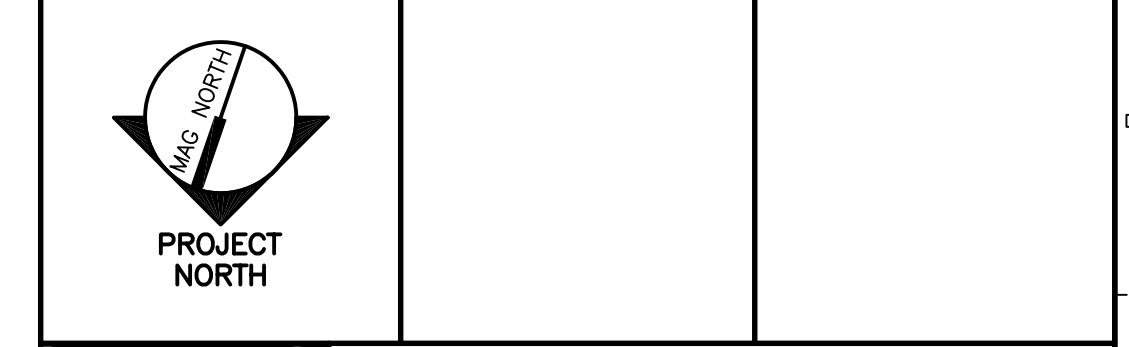

SMRT ARCHITECTURE ENGINEERING PLANNING
 SMRT
 144 Fore Street, P.O. Box 618
 Portland, Maine 04104
 tel. (207) 773-3846
 fax. (207) 772-1070

GLICKMAN LIBRARY
UNIVERSITY OF SOUTHERN MAINE
 PORTLAND, MAINE

SEVENTH FLOOR PLAN

SHEET TITLE:	SCALE: 1/8"=1'-0"	DATE:
PROJECT MANAGER: SLB	JOB CAP/DRAWN: CTB/JAC	GRAPHIC SCALE: 0" 1"
A/E OF RECORD: JPP	SMRT CAD FILE: EP107-99092	SHEET No.
PROJECT No. 99092		EP107