

**NOTES:**

1. SEE SHEET E-001 FOR LEGEND AND GENERAL NOTES.
2. ELEVATOR LOBBY 406 SMOKE DETECTOR NEEDS TO BE WIRED TO THE ELEVATOR RECALL OF THE 2 NEW ELEVATORS. WIRING ASSOCIATED WITH ELEVATOR #3 TO BE PRICED AS ALTERNATE #6.


**KEYED NOTE:**

- ① PROVIDE CONDUIT BETWEEN CEILING MOUNTED VOICE/DATA OUTLET BOX AND CABLE TRAY FOR FUTURE WIRELESS TRANSCEIVER.

0	ISSUED FOR CONSTRUCTION	3-17-03
REV.	DESCRIPTION	DATE

**ISSUED FOR CONSTRUCTION**  
**3-17-03**

CURRENT ISSUE STATUS:

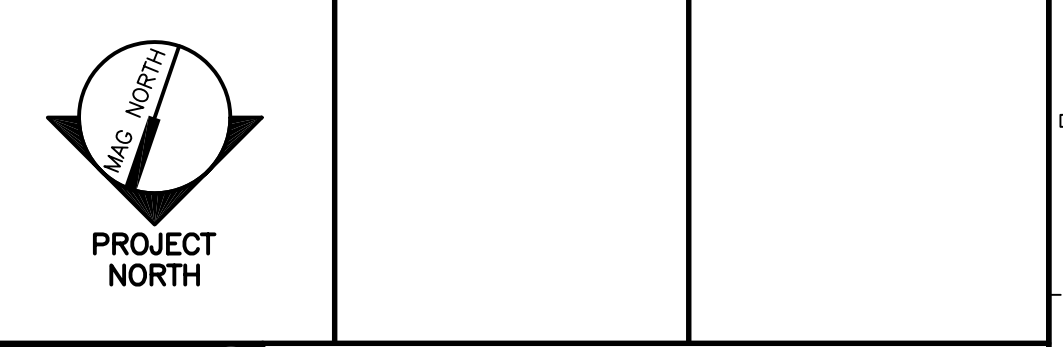

**SMRT** ARCHITECTURE ENGINEERING PLANNING  
 SMRT  
 144 Fore Street/P.O. Box 618  
 Portland, Maine 04104  
 tel. (207) 772-3846  
 fax. (207) 772-1070

**GLICKMAN LIBRARY**  
**UNIVERSITY OF SOUTHERN MAINE**  
 PORTLAND, MAINE

**PROJECT:**  
**FOURTH FLOOR**  
**SYSTEMS PLAN**

SHEET TITLE:	SCALE:	DATE:
PROJECT MANAGER: SLB	1/8"=1'-0"	
JOB CAP/DRAWN: CTB/JAC	GRAPHIC SCALE: 0" 1"	
A/E OF RECORD: JPP	SHEET No.	
SMRT CAD FILE: EY104-99092		<b>EY104</b>
PROJECT No. 99092		

**A1** **FOURTH FLOOR PLAN**  
 1/8"=1'-0"