

**NOTE:**  
1. SEE M-001 FOR LEGEND AND ABBREVIATIONS.


**KEYED NOTE:**  
① AS PART OF ADD. ALT #2, ON-OFF HEADS WILL BE REMOVED AND REPLACED WITH A STANDARD 165°F PENDANT HEAD. IF THE ON-OFF HEAD HAS THE CHROME ESCUTCHEON THE REPLACEMENT HEAD WILL HAVE A CHROME ESCUTCHEON.

- LEGEND**
- STANDARD 165°F PENDANT HEAD - CHROME
  - ⊙ 165°F ON-OFF HEAD CHROME. (SEE KEYED NOTE 1 ABOVE)
  - ⊗ RECESSED 165°F CHROME PENDANT
  - 165°F ON-OFF HEAD - CHROME WITH ESCUTCHEON (SEE KEYED NOTE 1 ABOVE)
  - ∴ HEAD TO BE REMOVED
  - NEW HEAD IN NEW LOCATION

| REV. | DESCRIPTION             | DATE    |
|------|-------------------------|---------|
| 0    | ISSUED FOR CONSTRUCTION | 3-17-03 |

**ISSUED FOR CONSTRUCTION**  
**3-17-03**

CURRENT ISSUE STATUS:

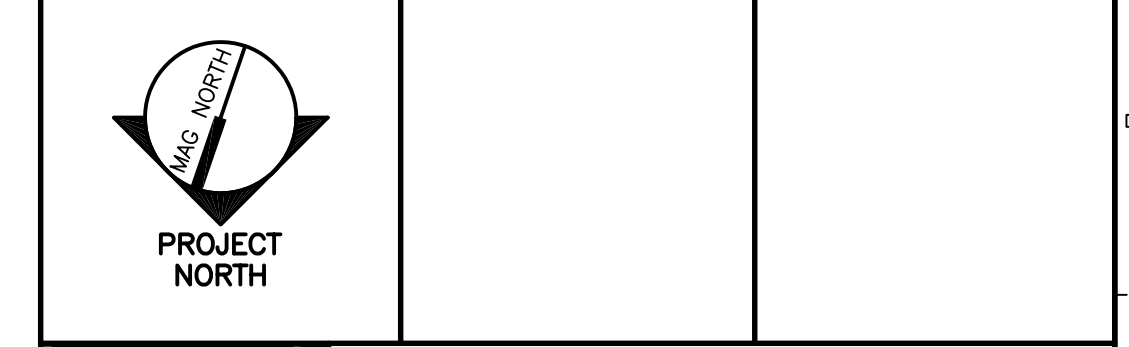

**SMRT** ARCHITECTURE ENGINEERING PLANNING  
144 Fore Street/P.O. Box 618  
Portland, Maine 04104  
tel. (207) 772-3846  
fax. (207) 772-1070

**GLICKMAN LIBRARY**  
**UNIVERSITY OF SOUTHERN MAINE**  
PORTLAND, MAINE

**BASEMENT**  
**SPRINKLER PLAN**

|                  |             |                |         |
|------------------|-------------|----------------|---------|
| SHEET TITLE:     | 1/8"=1'-0"  | DATE:          | 3-17-03 |
| PROJECT MANAGER: | SLB         | GRAPHIC SCALE: | 0" 1"   |
| JOB CAP/DRAWN:   | CTB/LAC     | A/E OF RECORD: | DBR     |
| SMRT CAD FILE:   | FP100-99092 | SHEET No.      | FP100   |
| PROJECT No.      | 99092       |                |         |