

NOTE:

1. SEE M-001 FOR LEGEND AND ABBREVIATIONS.

KEYED NOTE:

① AS PART OF ADD. ALT. #2, ON-OFF HEADS WILL BE REMOVED AND REPLACED WITH A STANDARD 165'F PENDANT HEAD. IF THE ON-OFF HEAD HAS THE CHROME ESCUTCHEON THE REPLACEMENT HEAD WILL HAVE A CHROME ESCUTCHEON.


LEGEND

- STANDARD 165'F PENDANT HEAD - CHROME
- ⊙ 165'F ON-OFF HEAD CHROME. (SEE KEYED NOTE 1 ABOVE)
- ⊗ RECESSED 165'F CHROME PENDANT
- 165'F ON-OFF HEAD - CHROME WITH ESCUTCHEON (SEE KEYED NOTE 1 ABOVE)
- HEAD TO BE REMOVED
- NEW HEAD IN NEW LOCATION

0	ISSUED FOR CONSTRUCTION	3-17-03
REV.	DESCRIPTION	DATE

ISSUED FOR CONSTRUCTION
3-17-03

CURRENT ISSUE STATUS:

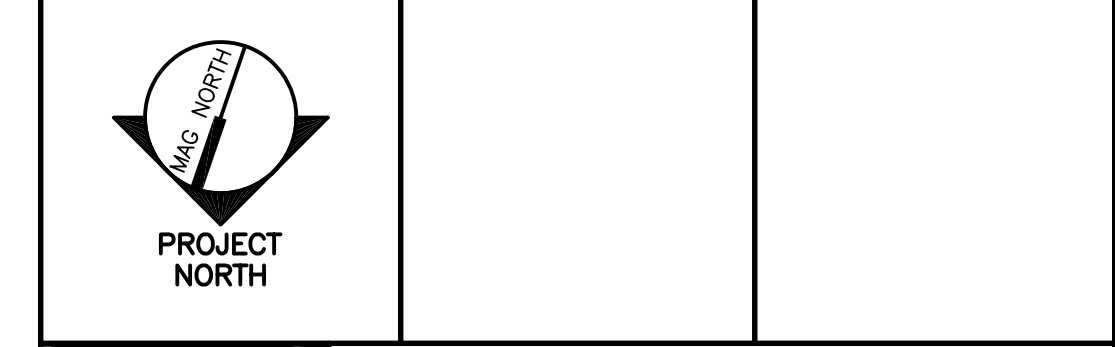

SMRT ARCHITECTURE ENGINEERING PLANNING
 SMRT
 144 Fore Street/P.O. Box 618
 Portland, Maine 04104
 tel. (207) 772-3846
 fax. (207) 772-1070

GLICKMAN LIBRARY
UNIVERSITY OF SOUTHERN MAINE
 PORTLAND, MAINE

PROJECT: **SECOND FLOOR SPRINKLER PLAN**

SHEET TITLE: **SECOND FLOOR SPRINKLER PLAN**

SCALE: 1/8"=1'-0"	DATE: 3-17-03
PROJECT MANAGER: SLB	GRAPHIC SCALE: 0" 1"
JOB CAP/DRAWN: CTB/LAC	
A/E OF RECORD: DBR	SHEET No.
SMRT CAD FILE: FP102-99092	FP102
PROJECT No. 99092	