


NOTE:
 1. SEE M-001 FOR LEGEND AND ABBREVIATIONS.

KEYED NOTE:
 ① AS PART OF ADD. ALT. #2, ON-OFF HEADS WILL BE REMOVED AND REPLACED WITH A STANDARD 165°F PENDANT HEAD. IF THE ON-OFF HEAD HAS THE CHROME ESCUTCHEON THE REPLACEMENT HEAD WILL HAVE A CHROME ESCUTCHEON.

- LEGEND**
- STANDARD 165°F PENDANT HEAD - CHROME
 - ⊙ 165°F ON-OFF HEAD CHROME. (SEE KEYED NOTE 1 ABOVE)
 - ⊗ RECESSED 165°F CHROME PENDANT
 - 165°F ON-OFF HEAD - CHROME WITH ESCUTCHEON (SEE KEYED NOTE 1 ABOVE)
 - HEAD TO BE REMOVED
 - NEW HEAD IN NEW LOCATION

REV.	DESCRIPTION	DATE
0	ISSUED FOR CONSTRUCTION	3-17-03

ISSUED FOR CONSTRUCTION
3-17-03

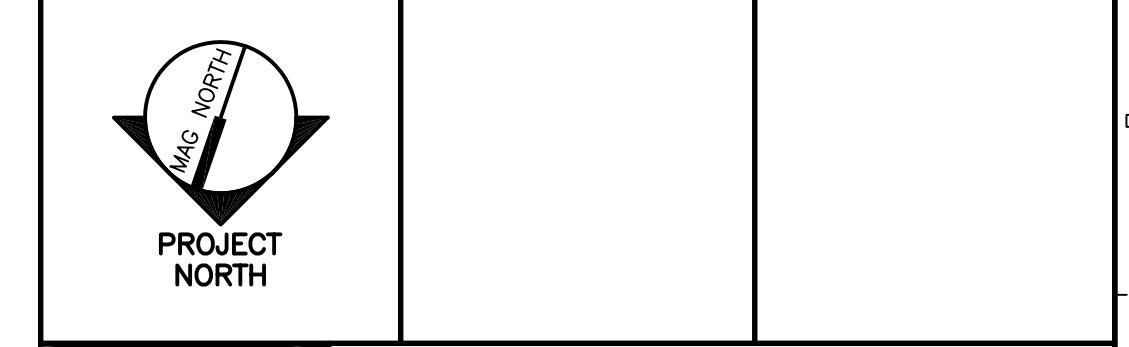

SMRT ARCHITECTURE ENGINEERING PLANNING
 144 Fore Street/P.O. Box 618
 Portland, Maine 04104
 tel. (207) 772-3846
 fax. (207) 772-1070

GLICKMAN LIBRARY
 UNIVERSITY OF SOUTHERN MAINE
 PORTLAND, MAINE

PROJECT: **FOURTH FLOOR SPRINKLER PLAN**

SHEET TITLE:	SCALE: 1/8"=1'-0"	DATE: 3-17-03
PROJECT MANAGER: SLB	JOB CAP/DRAWN: CTB/LAC	GRAPHIC SCALE: 0" 1"
A/E OF RECORD: DBR	SMRT CAD FILE: FP104-99092	SHEET No.
PROJECT No. 99092		FP104

A1 FOURTH FLOOR PLAN
 1/8"=1'-0"