


NOTE:
 1. SEE SHEET M-001 FOR LEGEND AND ABBREVIATIONS.

KEYED NOTE:
 ① SEE DETAIL A5 ON SHEET M-501.

0	ISSUED FOR CONSTRUCTION	3-17-03
REV.	DESCRIPTION	DATE

ISSUED FOR CONSTRUCTION
3-17-03
 CURRENT ISSUE STATUS:

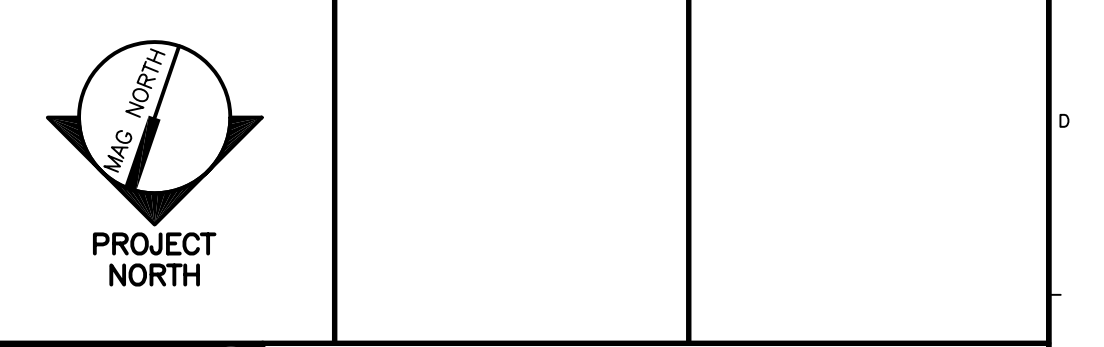

SMRT ARCHITECTURE ENGINEERING PLANNING
 SMRT
 144 Fore Street/P.O. Box 618
 Portland, Maine 04104
 tel. (207) 772-3846
 fax. (207) 772-1070

GLICKMAN LIBRARY
UNIVERSITY OF SOUTHERN MAINE
 PORTLAND, MAINE

PROJECT:
FIRST FLOOR
DUCTWORK PLAN

SHEET TITLE:	1/8"=1'-0"	DATE:	3-17-03
PROJECT MANAGER:	SLB	GRAPHIC SCALE:	0" 1"
JOB CAP/DRAWN:	CTB/LAC	A/E OF RECORD:	DBR
SMRT CAD FILE:	MH101-99092	SHEET No.	MH101
PROJECT No.	99092		

A1 FIRST FLOOR PLAN
 1/8"=1'-0"