


NOTE:

1. SEE SHEET E-001 FOR LEGEND AND ABBREVIATIONS.

KEYED NOTE:

① SEE DETAIL A5 ON SHEET M-501.

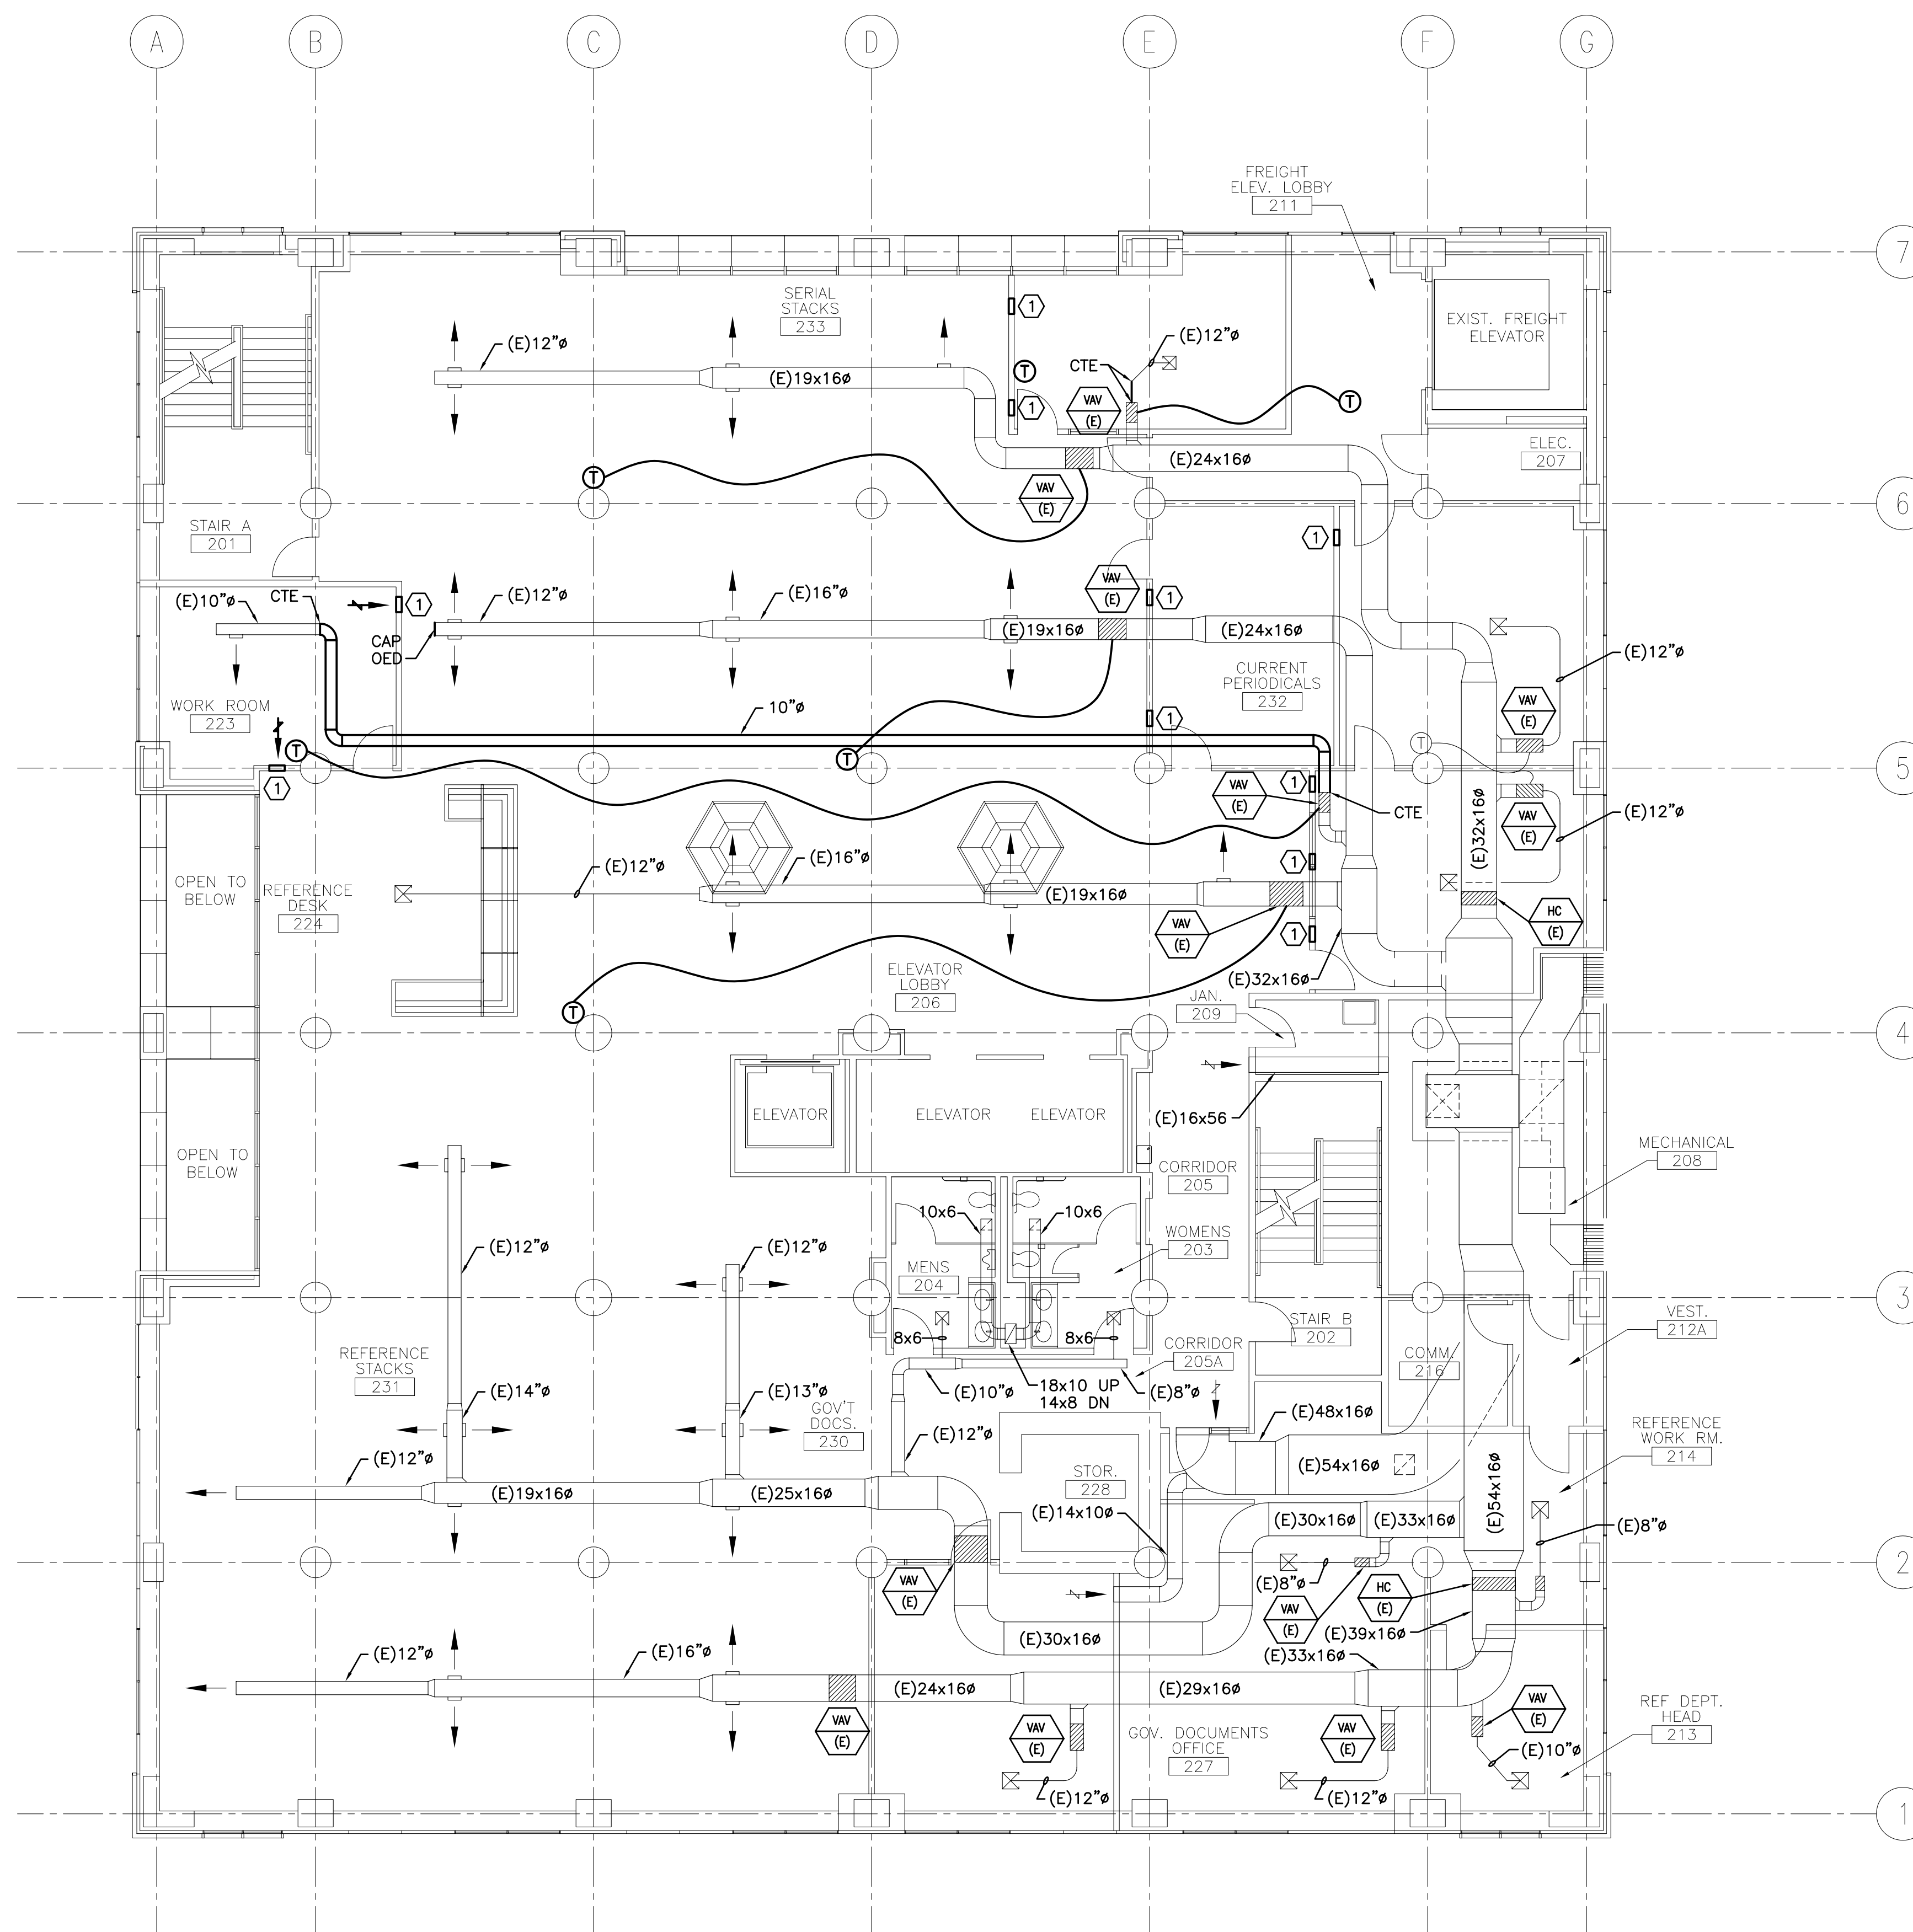

0	ISSUED FOR CONSTRUCTION	3-17-03
REV.	DESCRIPTION	DATE

ISSUED FOR CONSTRUCTION
3-17-03



SMRT ARCHITECTURE ENGINEERING PLANNING
 SMRT
 144 Fore Street/P.O. Box 618
 Portland, Maine 04104
 tel. (207) 772-3846
 fax. (207) 772-1070

GLICKMAN LIBRARY
UNIVERSITY OF SOUTHERN MAINE
 PORTLAND, MAINE

PROJECT:
SECOND FLOOR
DUCTWORK PLAN

SHEET TITLE:	SCALE: 1/8"=1'-0"	DATE: 3-17-03
PROJECT MANAGER: SLB	JOB CAP/DRAWN: CTB/LAC	GRAPHIC SCALE: 0" 1"
A/E OF RECORD: DBR	SMRT CAD FILE: MH102-99092	SHEET No.
PROJECT No. 99092		MH102

A1 SECOND FLOOR PLAN

1/8"=1'-0"