


NOTE:
 1. SEE M-001 FOR LEGEND AND ABBREVIATIONS.

KEYED NOTES:
 ① SEE DETAIL A5 ON SHEET M-501.
 ② TWO GRILLS AT EACH OPENING.

| | | |
|------|-------------------------|---------|
| 0 | ISSUED FOR CONSTRUCTION | 3-17-03 |
| REV. | DESCRIPTION | DATE |

ISSUED FOR CONSTRUCTION
3-17-03
 CURRENT ISSUE STATUS:

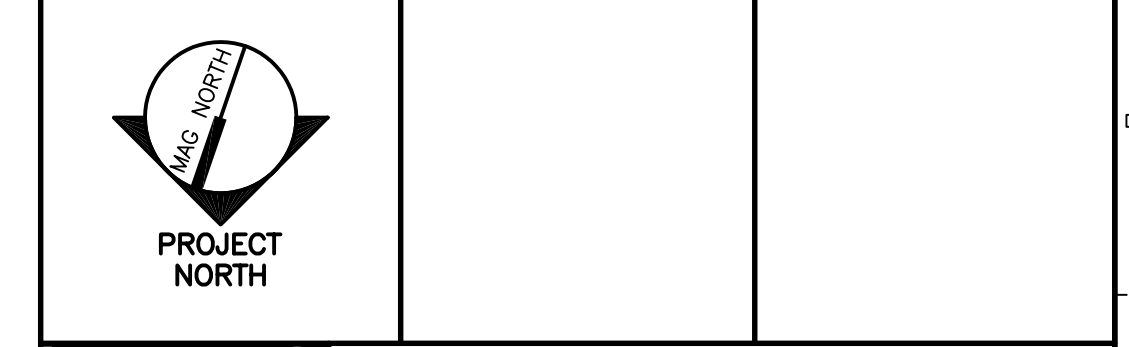

SMRT ARCHITECTURE ENGINEERING PLANNING
 SMRT
 144 Fore Street/P.O. Box 618
 Portland, Maine 04104
 tel. (207) 772-3846
 fax. (207) 772-1070

GLICKMAN LIBRARY
UNIVERSITY OF SOUTHERN MAINE
 PORTLAND, MAINE

PROJECT:
FIFTH FLOOR
DUCTWORK PLAN

| | | |
|----------------------|----------------------------|----------------------|
| SHEET TITLE: | SCALE: 1/8" = 1'-0" | DATE: 3-17-03 |
| PROJECT MANAGER: SLB | JOB CAP/DRAWN: CTB/LAC | GRAPHIC SCALE: 0" 1" |
| A/E OF RECORD: DBR | SMRT CAD FILE: MH105-99092 | SHEET No. |
| PROJECT No. 99092 | | MH105 |

A1 FIFTH FLOOR PLAN
 1/8"=1'-0"