


NOTE:
1. SEE M-001 FOR LEGEND AND ABBREVIATIONS.

KEYED NOTES:
 ① SEE DETAIL A5 ON SHEET M-501.
 ② TWO GRILLES AT EACH OPENING.
 ③ COORDINATE WITH LIGHTING CONTRACTOR TO AVOID LIGHTING.

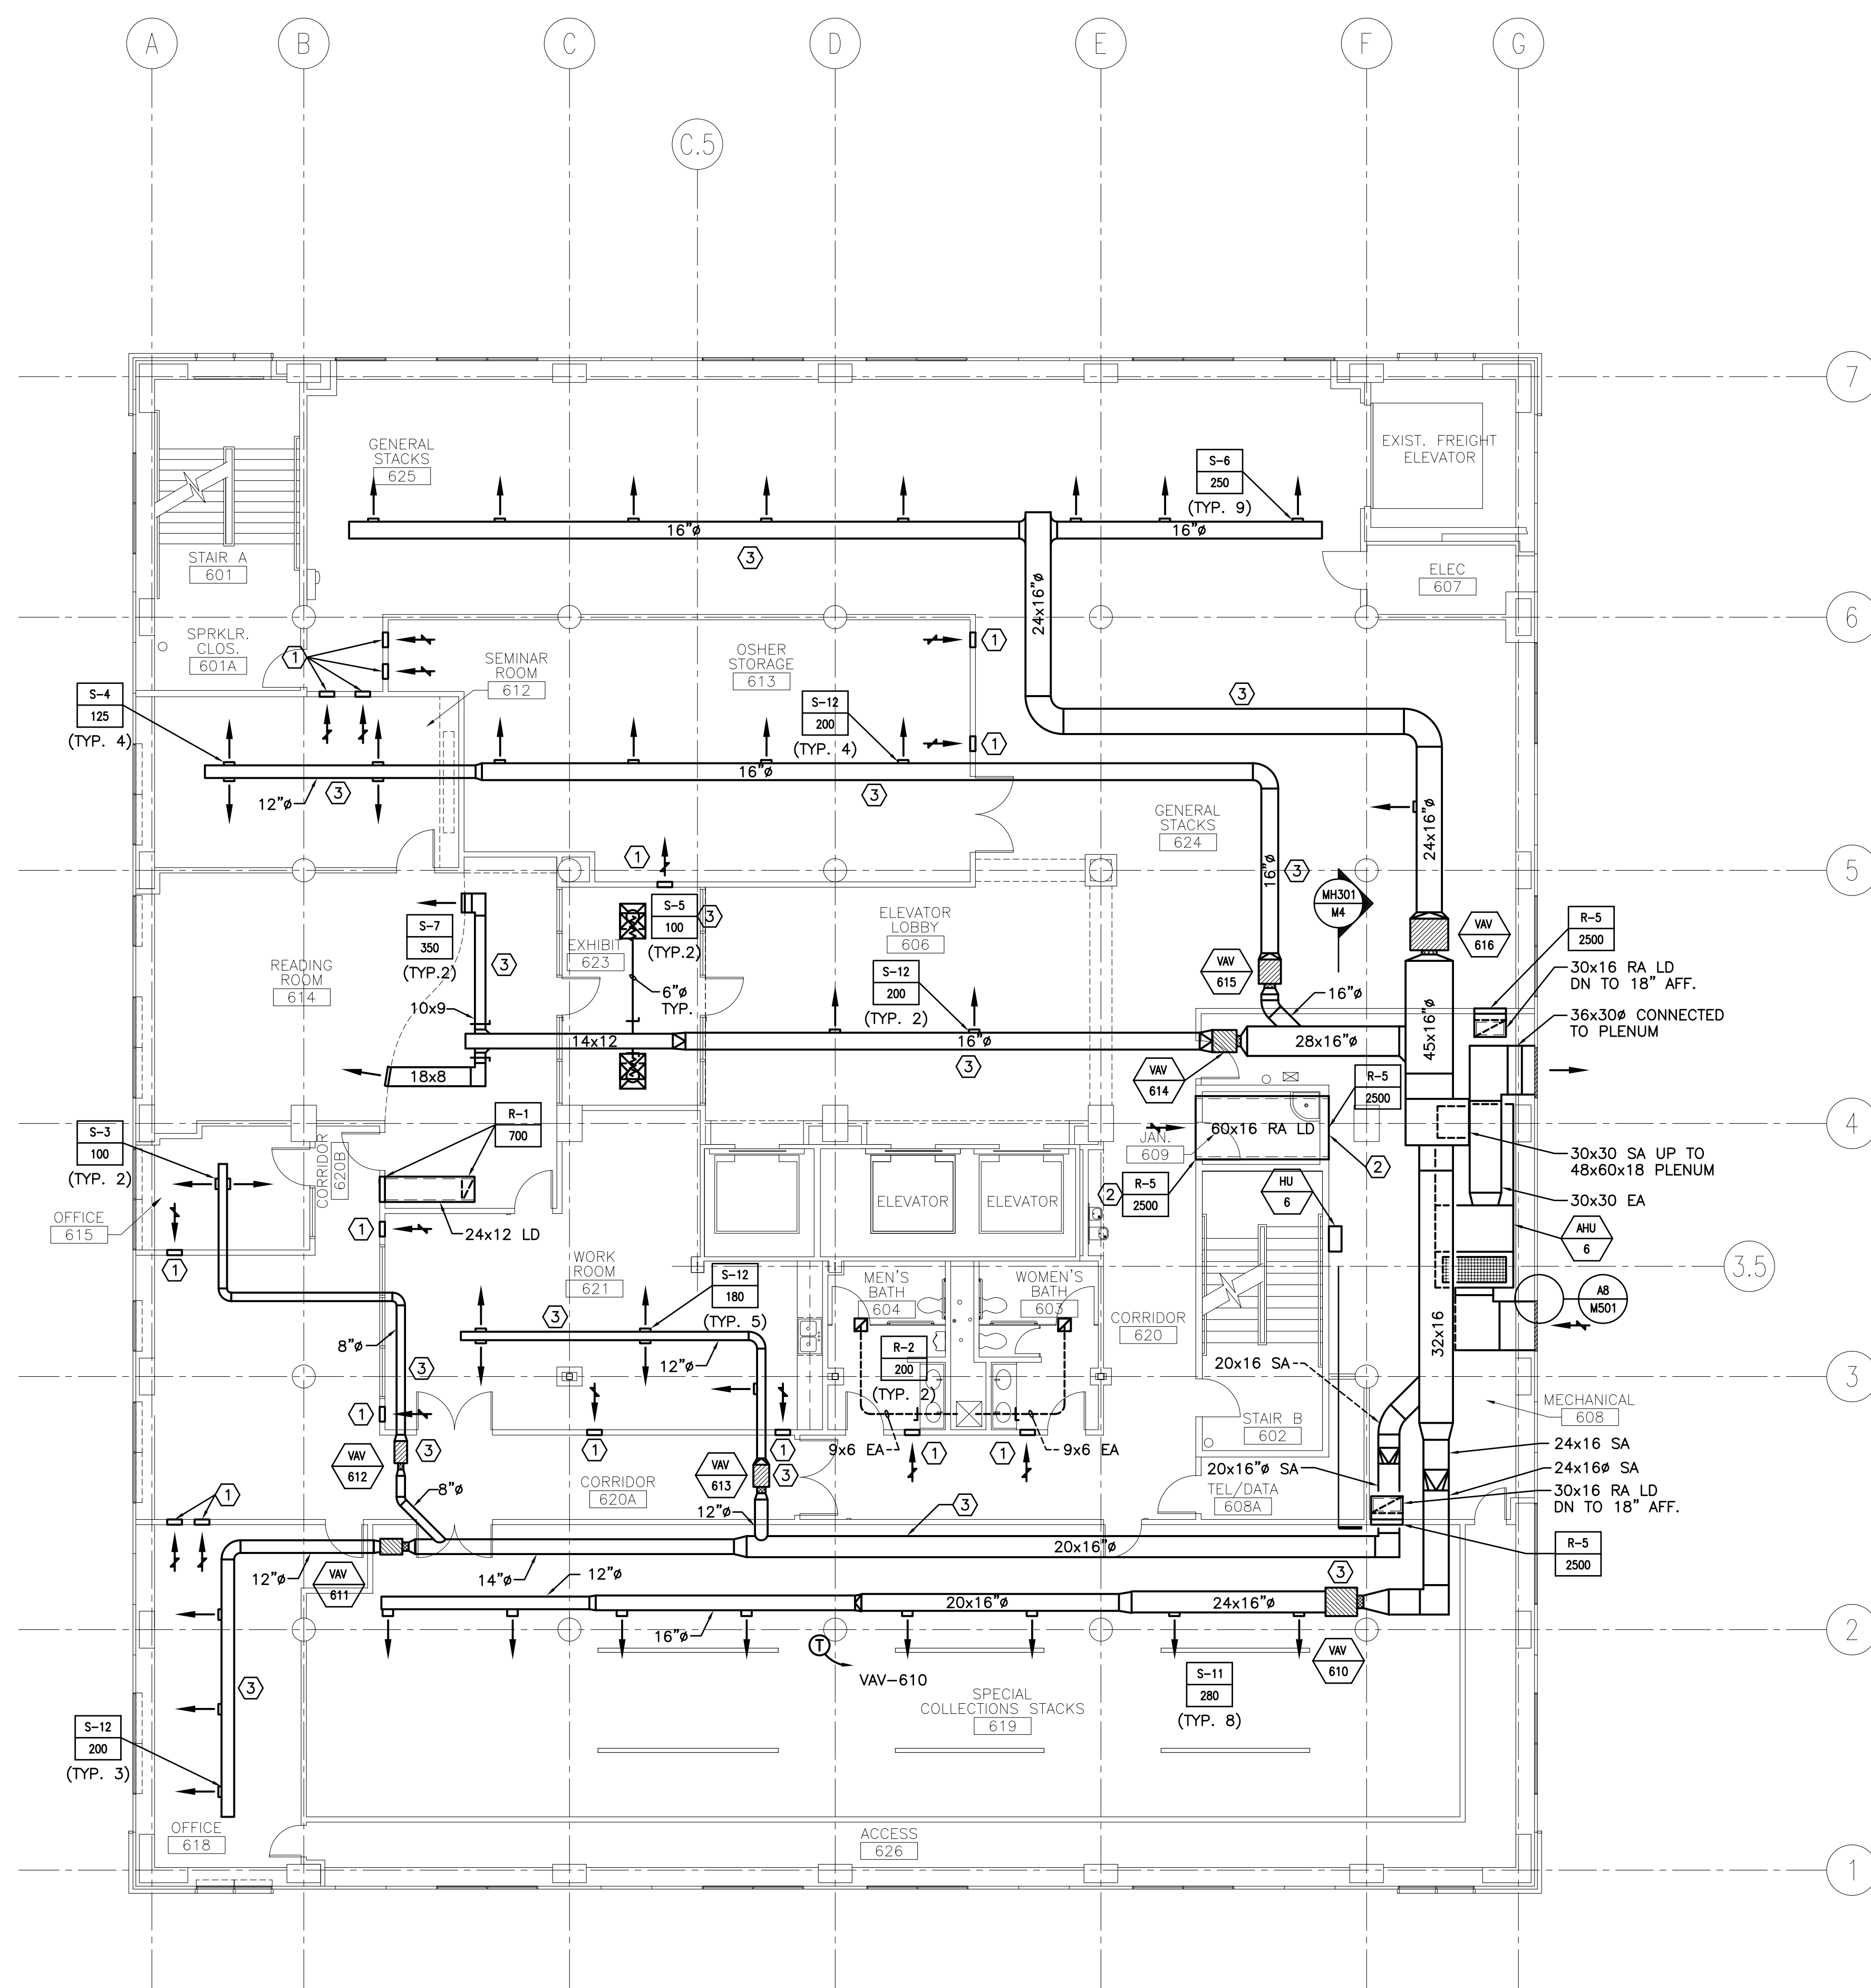

0	ISSUED FOR CONSTRUCTION	3-17-03
REV.	DESCRIPTION	DATE

ISSUED FOR CONSTRUCTION
3-17-03

CURRENT ISSUE STATUS:

PROJECT NORTH

SMRT ARCHITECTURE ENGINEERING PLANNING
 SMRT
 144 Fore Street/P.O. Box 618
 Portland, Maine 04104
 tel. (207) 772-3846
 fax. (207) 772-1070

GLICKMAN LIBRARY
 UNIVERSITY OF SOUTHERN MAINE
 PORTLAND, MAINE

PROJECT:
SIXTH FLOOR
DUCTWORK PLAN

SHEET TITLE:	SCALE:	DATE:
PROJECT MANAGER:	1/8"=1'-0"	3-17-03
JOB CAP/DRAWN:	SLB	GRAPHIC SCALE: 0" 1"
A/E OF RECORD:	CTB/BGG	
SMRT CAD FILE:	DBR	SHEET No.
PROJECT No.	MH106-99092	MH106
	99092	