


NOTE:
1. SEE M-001 FOR LEGEND AND ABBREVIATIONS.

KEYED NOTES:
① COORDINATE WITH LIGHTING CONTRACTOR TO AVOID LIGHTING.
② SEE DETAIL A5 ON SHEET M-501.

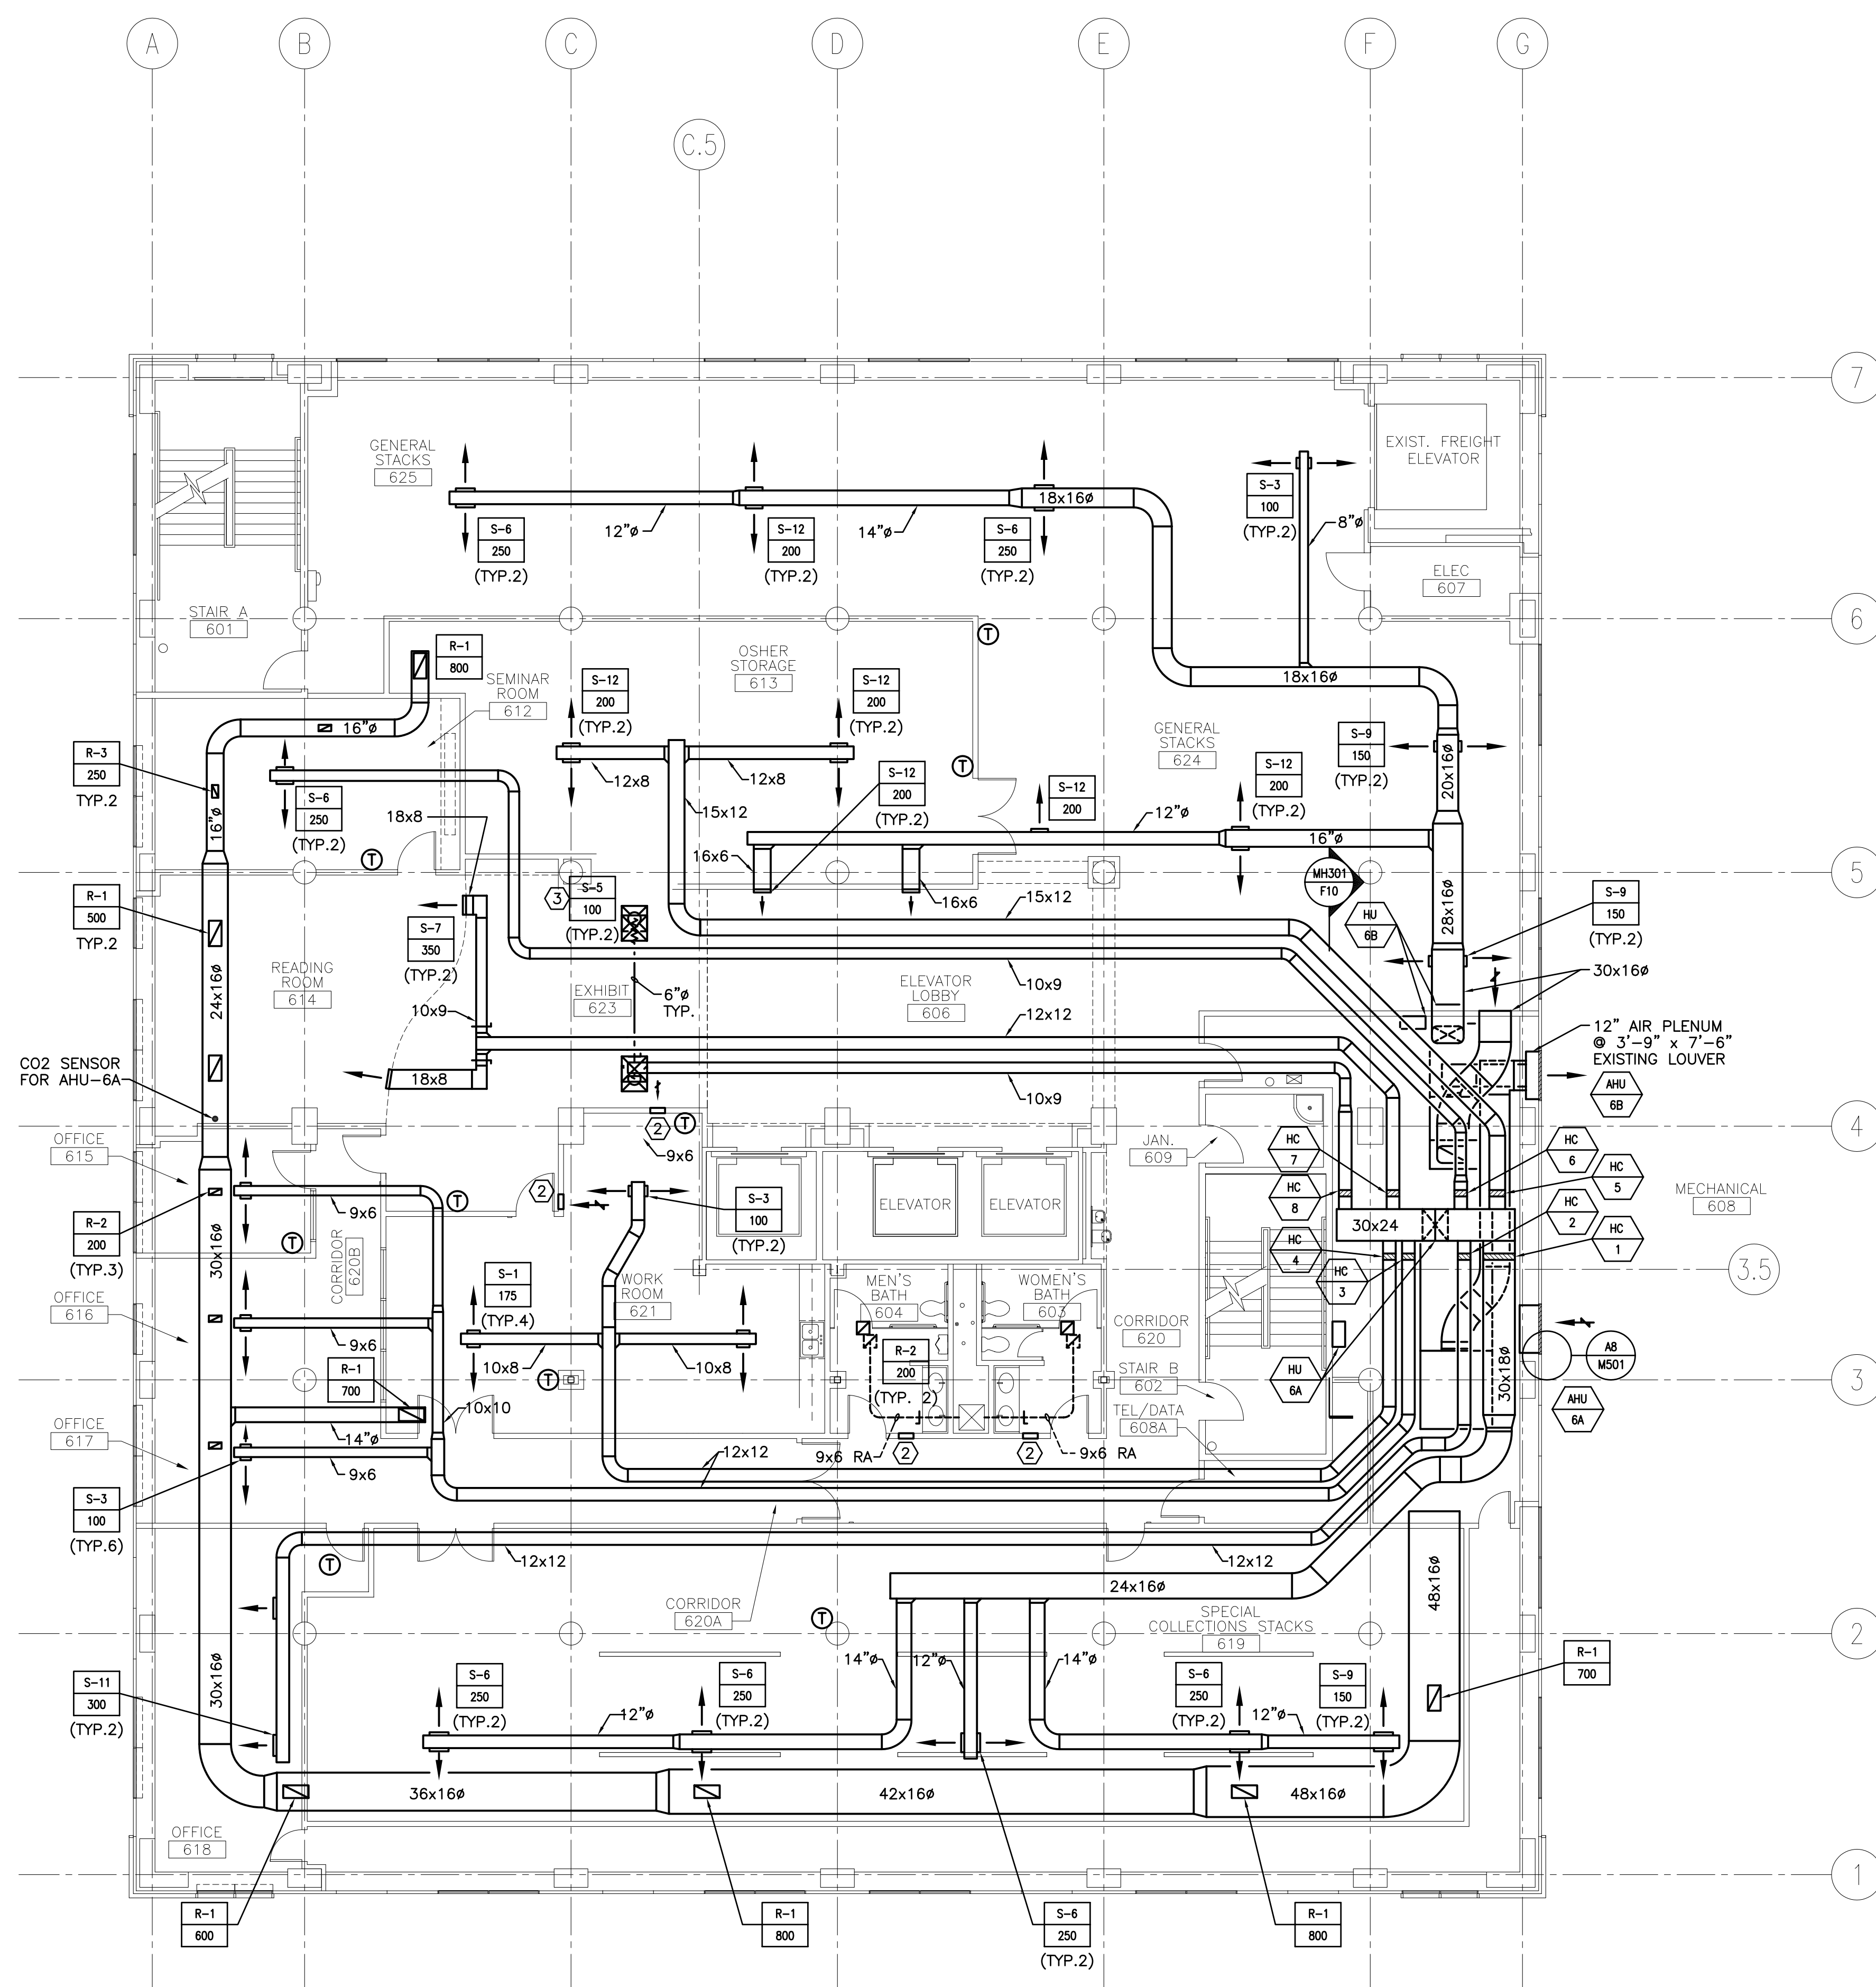

0	ISSUED FOR CONSTRUCTION	3-17-03
REV.	DESCRIPTION	DATE

ISSUED FOR CONSTRUCTION
3-17-03



ARCHITECTURE ENGINEERING PLANNING
SMRT
144 Fore Street/P.O. Box 618
Portland, Maine 04104
tel. (207) 772-3846
fax. (207) 772-1070

GLICKMAN LIBRARY
UNIVERSITY OF SOUTHERN MAINE
PORTLAND, MAINE

SIXTH FLOOR DUCTWORK PLAN
ADD ALT. #4

SHEET TITLE:	SCALE: 1/8"=1'-0"	DATE: 3-17-03
PROJECT MANAGER: SLB	GRAPHIC SCALE: 0" 1"	
JOB CAP/DRAWN: CTB/LAC	A/E OF RECORD: DBR	SHEET No.
SMRT CAD FILE: MH126-99092	PROJECT No. 99092	MH126