


**NOTE:**  
1. SEE M-001 FOR LEGEND AND ABBREVIATIONS.

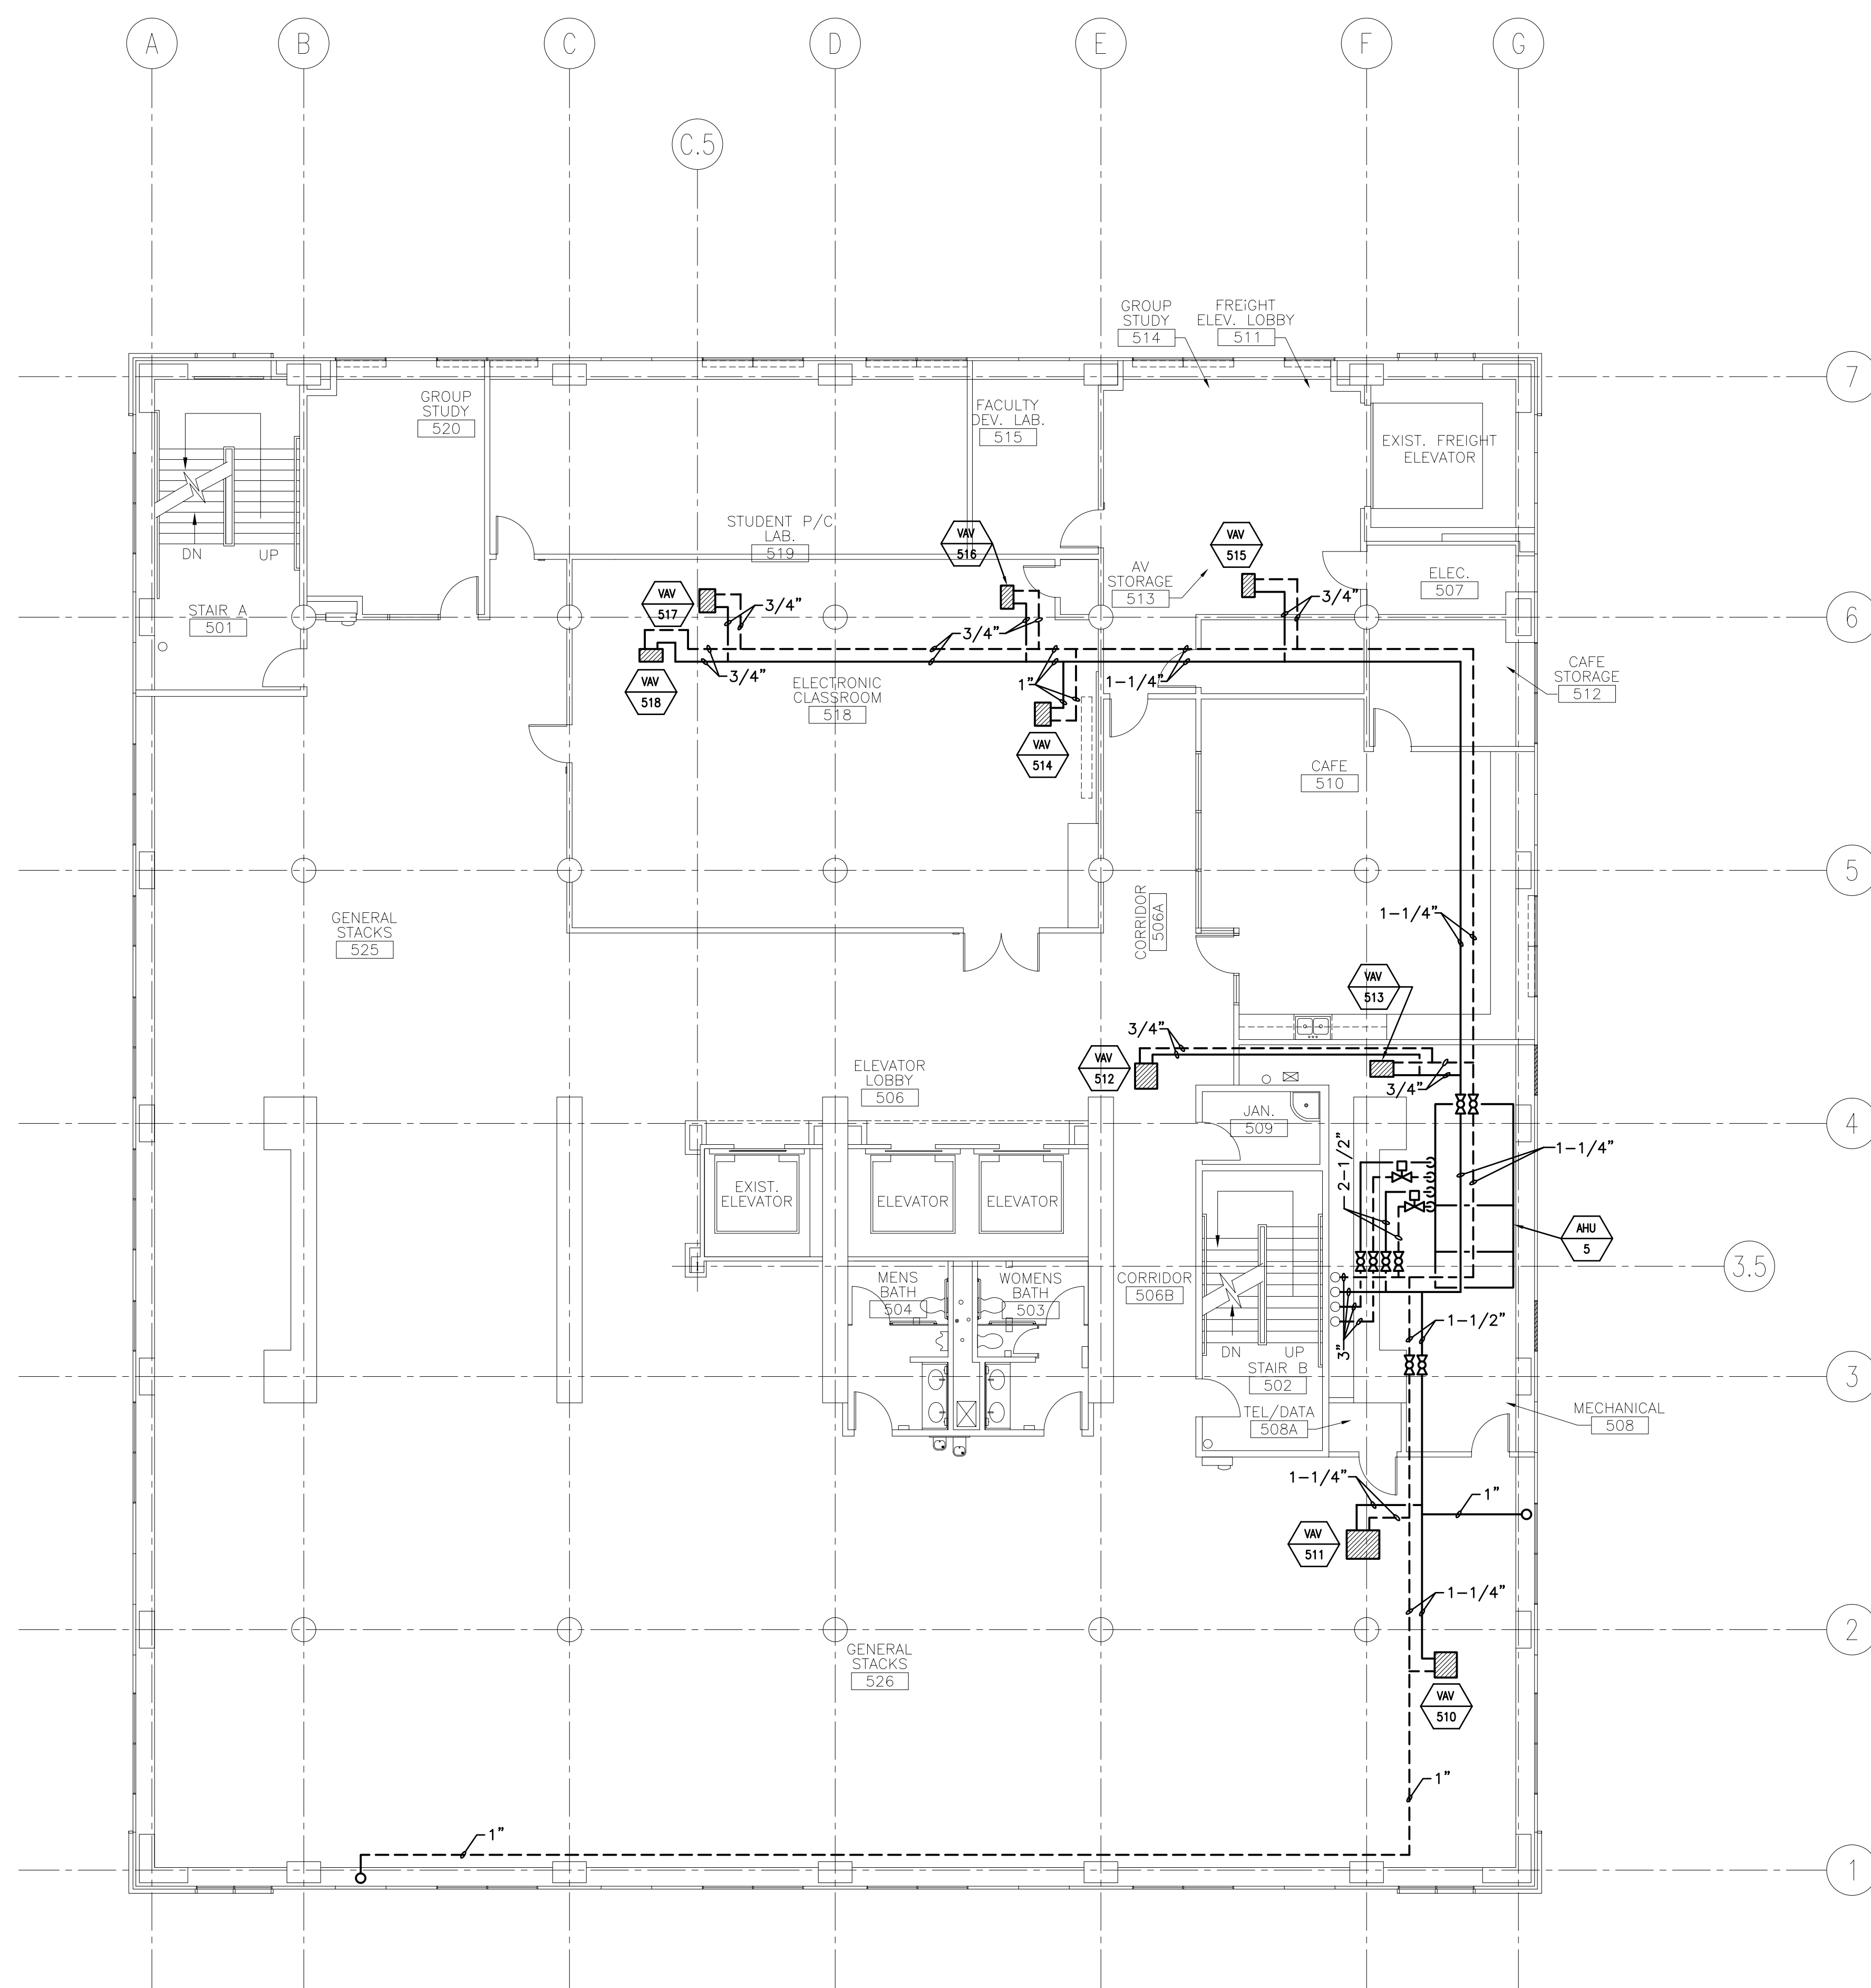

0	ISSUED FOR CONSTRUCTION	3-17-03
REV.	DESCRIPTION	DATE

**ISSUED FOR CONSTRUCTION**  
**3-17-03**



ARCHITECTURE ENGINEERING PLANNING  
SMRT  
144 Fore Street/P.O. Box 618  
Portland, Maine 04104  
tel. (207) 772-3846  
fax. (207) 772-1070

**GLICKMAN LIBRARY**  
**UNIVERSITY OF SOUTHERN MAINE**  
PORTLAND, MAINE

**FIFTH FLOOR**  
**PIPING PLAN**

SHEET TITLE:		DATE:	3-17-03
SCALE:	1/8" = 1'-0"	GRAPHIC SCALE:	0" 1"
PROJECT MANAGER:	SLB		
JOB CAP/DRAWN:	LAC		
A/E OF RECORD:	DBR	SHEET No.	
SMRT CAD FILE:	MP105-99092		
PROJECT No.	99092		

**MP105**

**A1** FIFTH FLOOR PLAN

1/8"=1'-0"