


**NOTE:**  
1. SEE M-001 FOR LEGEND AND ABBREVIATIONS.

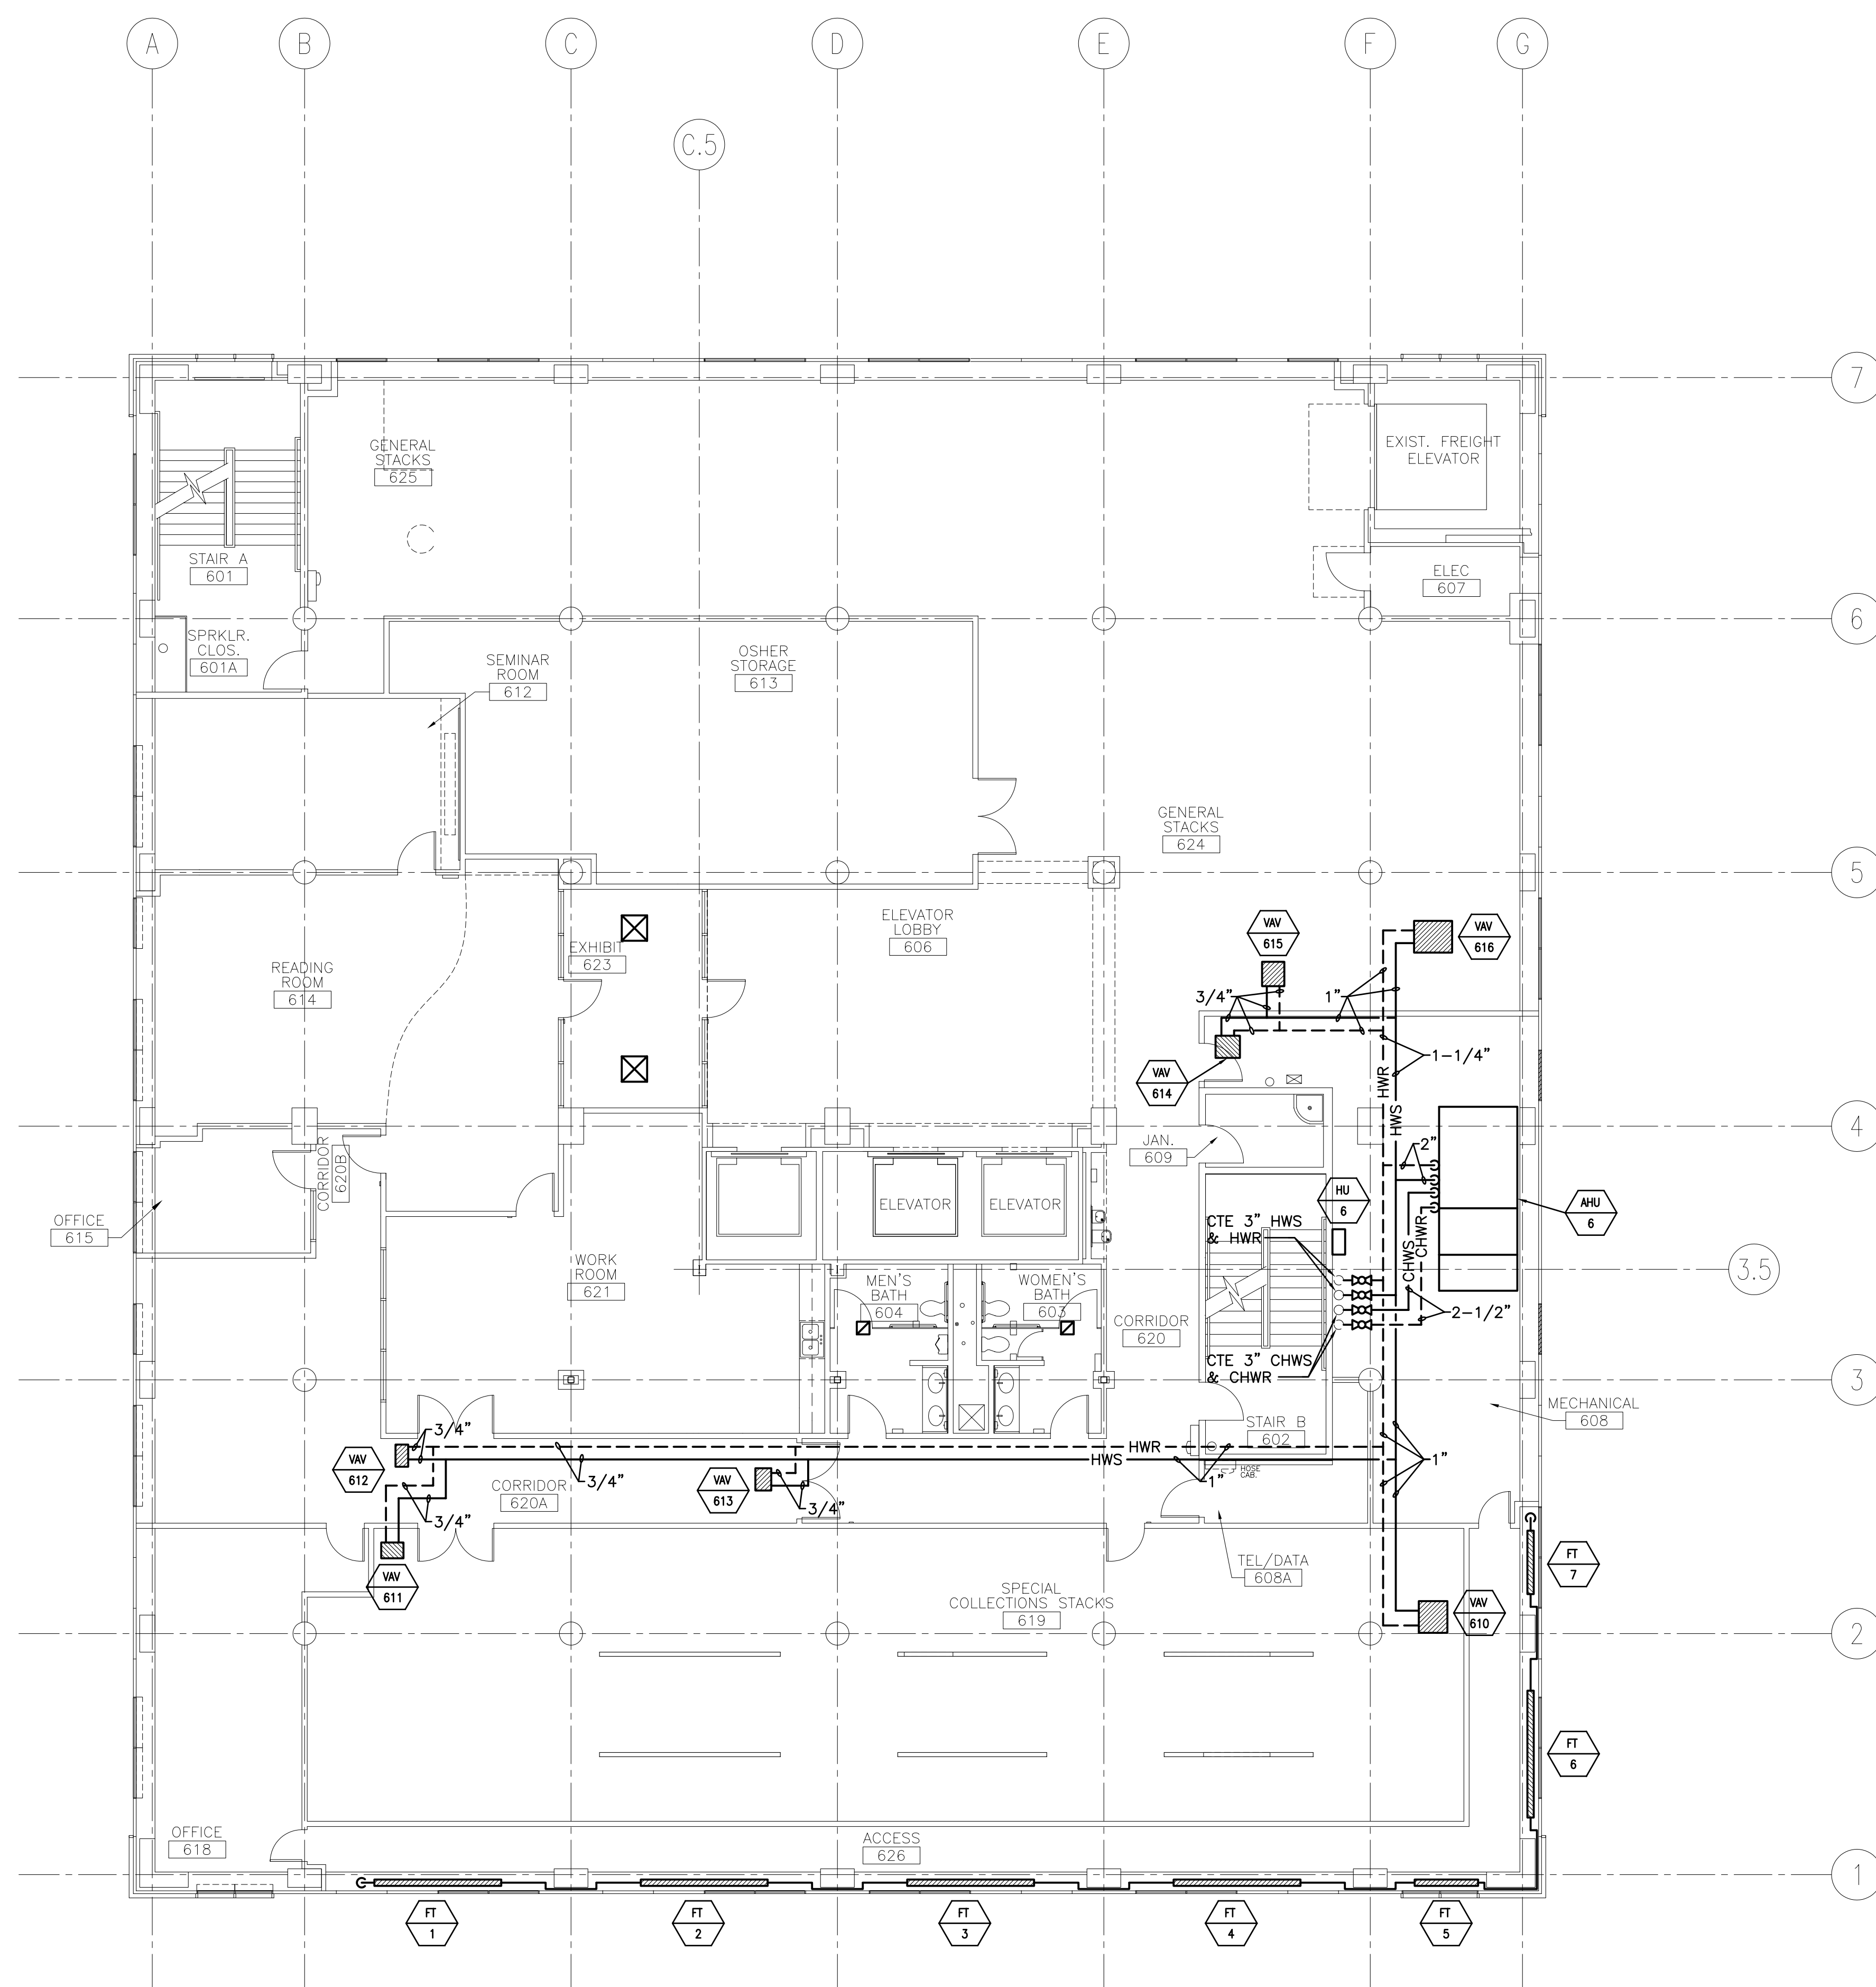

0	ISSUED FOR CONSTRUCTION	3-17-03
REV.	DESCRIPTION	DATE

**ISSUED FOR CONSTRUCTION**  
**3-17-03**



ARCHITECTURE ENGINEERING PLANNING  
SMRT  
144 Fore Street/P.O. Box 618  
Portland, Maine 04104  
tel. (207) 772-3846  
fax. (207) 772-1070

**GLICKMAN LIBRARY**  
**UNIVERSITY OF SOUTHERN MAINE**  
PORTLAND, MAINE

**SIXTH FLOOR PLAN**  
**PIPING PLAN**

SHEET TITLE:	SCALE: 1/8"=1'-0"	DATE: 3-17-03
PROJECT MANAGER: SLB	JOB CAP/DRAWN: CTB/BGG	GRAPHIC SCALE: 0" 1"
A/E OF RECORD: DBR	SMRT CAD FILE: MP106-99092	SHEET No.
PROJECT No. 99092		<b>MP106</b>

**A1** SIXTH FLOOR PLAN  
1/8"=1'-0"