



NOTE:
1. SEE M-001 FOR LEGEND AND ABBREVIATIONS.

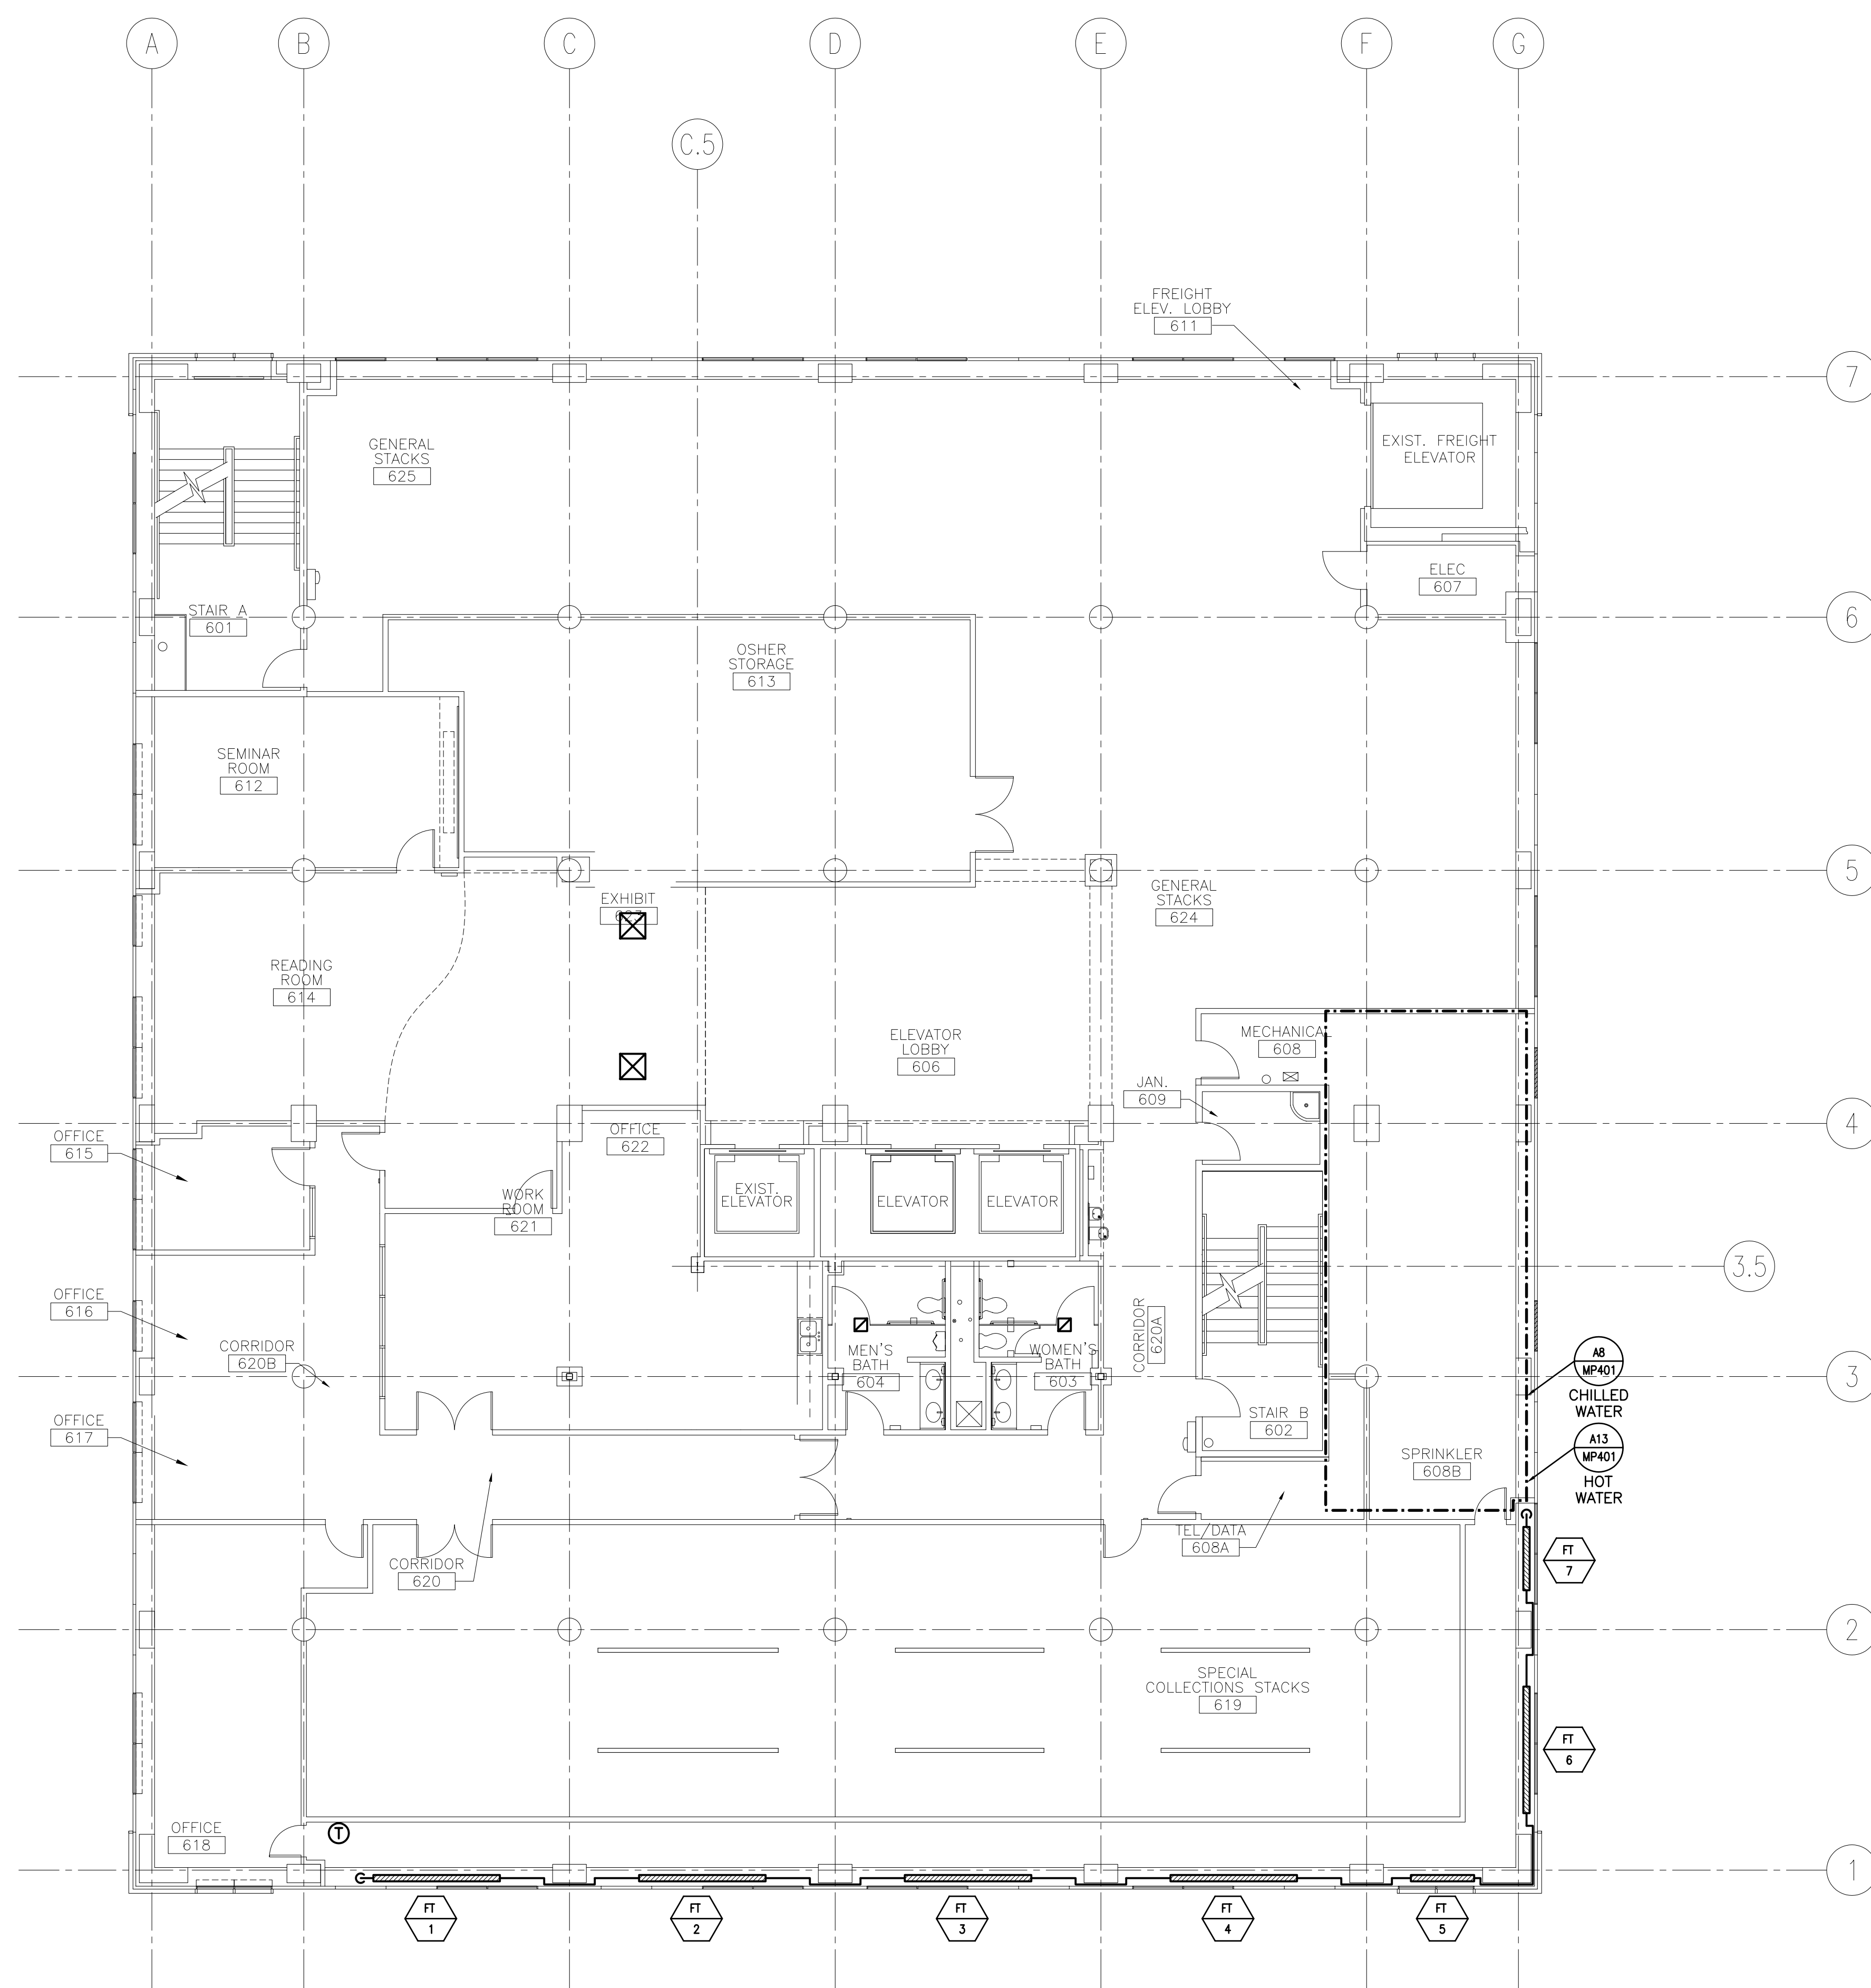

0	ISSUED FOR CONSTRUCTION	3-17-03
REV.	DESCRIPTION	DATE

ISSUED FOR CONSTRUCTION
3-17-03

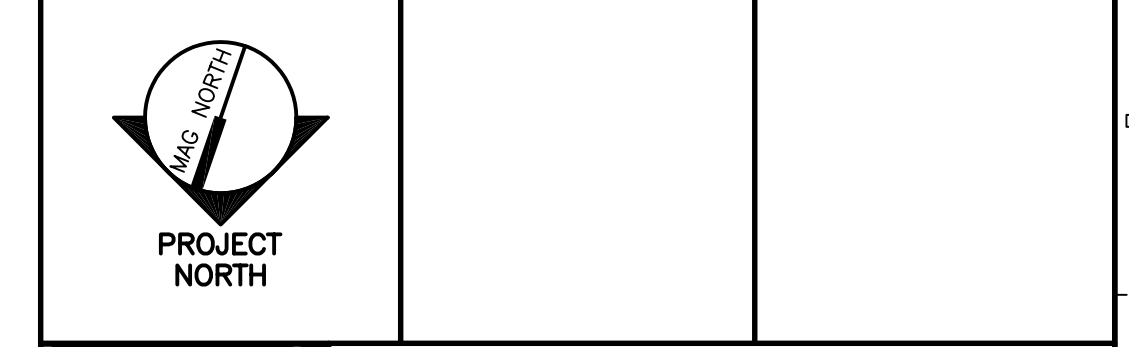

SMRT ARCHITECTURE ENGINEERING PLANNING
144 Fore Street, P.O. Box 618
Portland, Maine 04104
tel. (207) 772-3846
fax. (207) 772-1070

GLICKMAN LIBRARY
UNIVERSITY OF SOUTHERN MAINE
PORTLAND, MAINE

SIXTH FLOOR PIPING PLAN
ADD ALT. #4

SHEET TITLE:		DATE:
SCALE:	1/8"=1'-0"	3-17-03
PROJECT MANAGER:	SLB	GRAPHIC SCALE:
JOB CAP/DRAWN:	CTB/LAC	0" 1"
A/E OF RECORD:	DBR	SHEET No.
SMRT CAD FILE:	MP126-99092	MP126
PROJECT No.	99092	