


DOMESTIC WATER HEATER SCHEDULE										
TAG	FUEL	INPUT MBH	RECOVERY RATE GPH 40°-120°F	STORAGE TANK SIZE/GAL.	ELECTRICAL DATA HP	VOLT/#	FLUE SIZE (in.)	OPERATING WEIGHT (lbs.)	TYPICAL UNIT MFR. & MODEL NO.	NOTES
EWH-1	ELEC	-	10	6	-	277/1	N/A	90	RHEEM EGSP-6-2	
EWH-1	ELEC	-	16	20	-	277/1	N/A	240	RHEEM EGSP-20-3	

NOTES:


PLUMBING FIXTURE SCHEDULE						
TAG	FIXTURE	CW	HW	WASTE	VENT	REMARKS:
P-1	WALL-HUNG WATER CLOSET	1"	-	3"	2"	CRANE MODEL 3446 W/SLOAN MODEL 111-ES-S FLUSH VALVE
P-2	WALL-HUNG URINAL	3/4"	-	2"	1-1/2"	CRANE MODEL 7309 W/SLOAN MODEL 186.1-ES-S FLUSH VALVE
P-3	① LAVATORY COUNTER	1/2"	1/2"	1-1/2"	1-1/2"	AMER STD MODEL 0476.028 W/ CHICAGO FAUCET MODEL 802A-665
P-4	WATER-COOLER WALL HUNG-ADA	1/2"	-	1-1/2"	1-1/2"	HALSEY-TAYLOR MODEL HRFSEBD W/ REMOTE CHILLER MODEL SJ8-Q
P-5	JANITOR SERVICE SINK	1/2"	1/2"	3"	1-1/2"	AMER STD MODEL 7741.000 SINK W/ CHICAGO FAUCET MODEL 897-RCF
P-6	② DOUBLE-BOWL SS SINK	1/2"	1/2"	2"	1-1/2"	ELKAY SINK MODEL GEOR-3321 W/ CHICAGO FAUCET MODEL 200A-L9-E3-320

NOTES: ① UNDER EACH COUNTER MOUNT A HOSE BIBB - CHICAGO MODEL 293
② SINK TO BE FURNISHED WITH DRAINS LOCATED IN THE BACK-CENTER POSITION FOR ADA COMPLIANCE.


NOTE:
1. SEE SHEET M-001 FOR LEGEND AND ABBREVIATIONS.

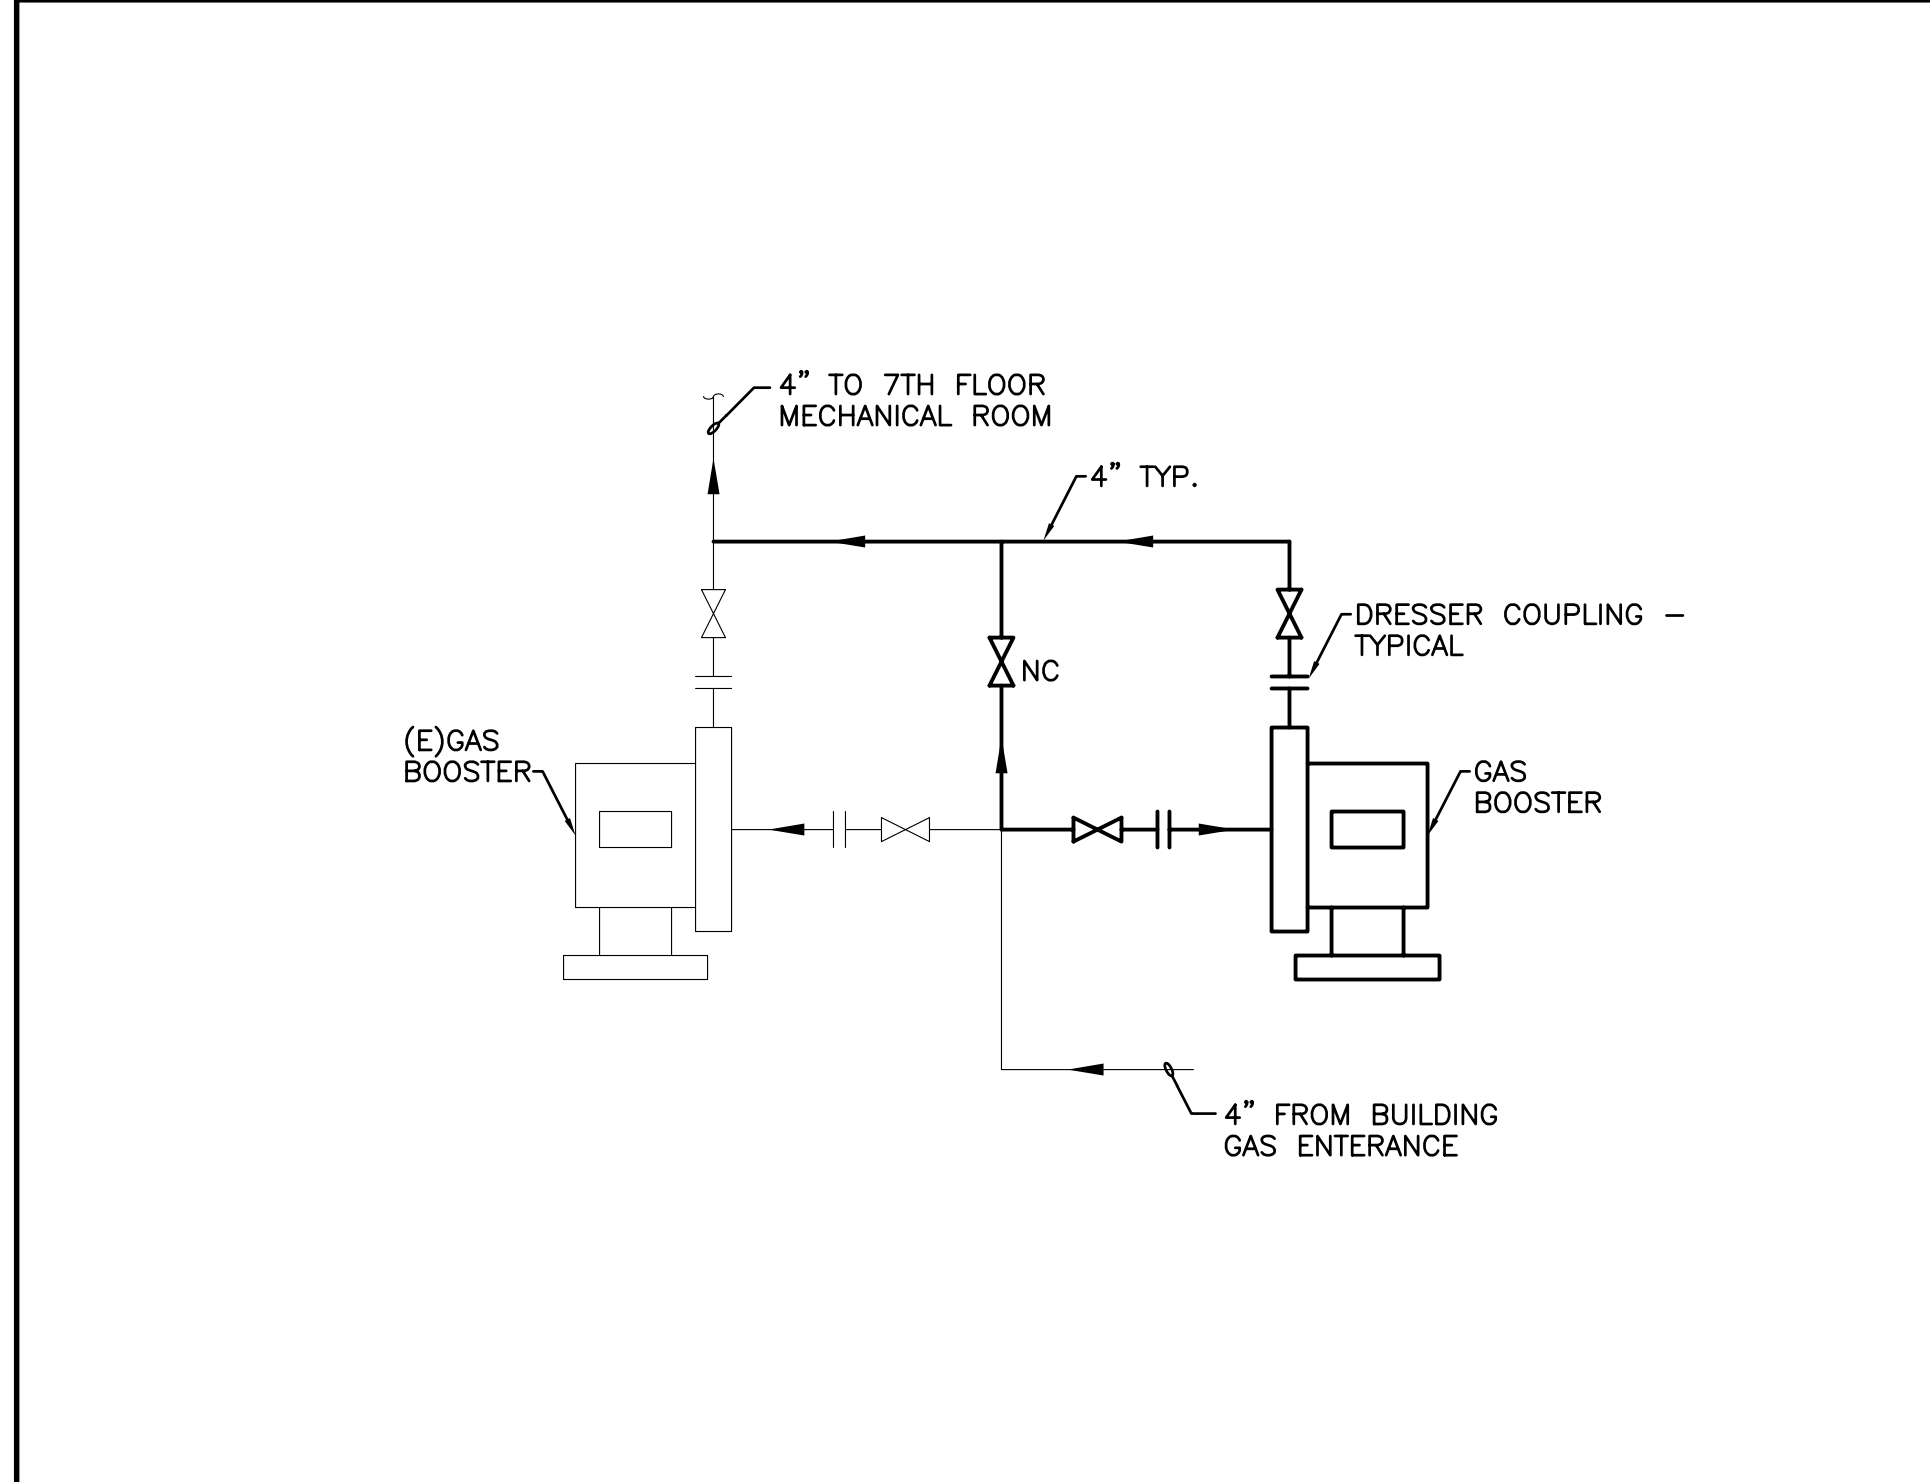

F13 GAS BOOSTER (ADD ALTERNATE #8)
NOT TO SCALE

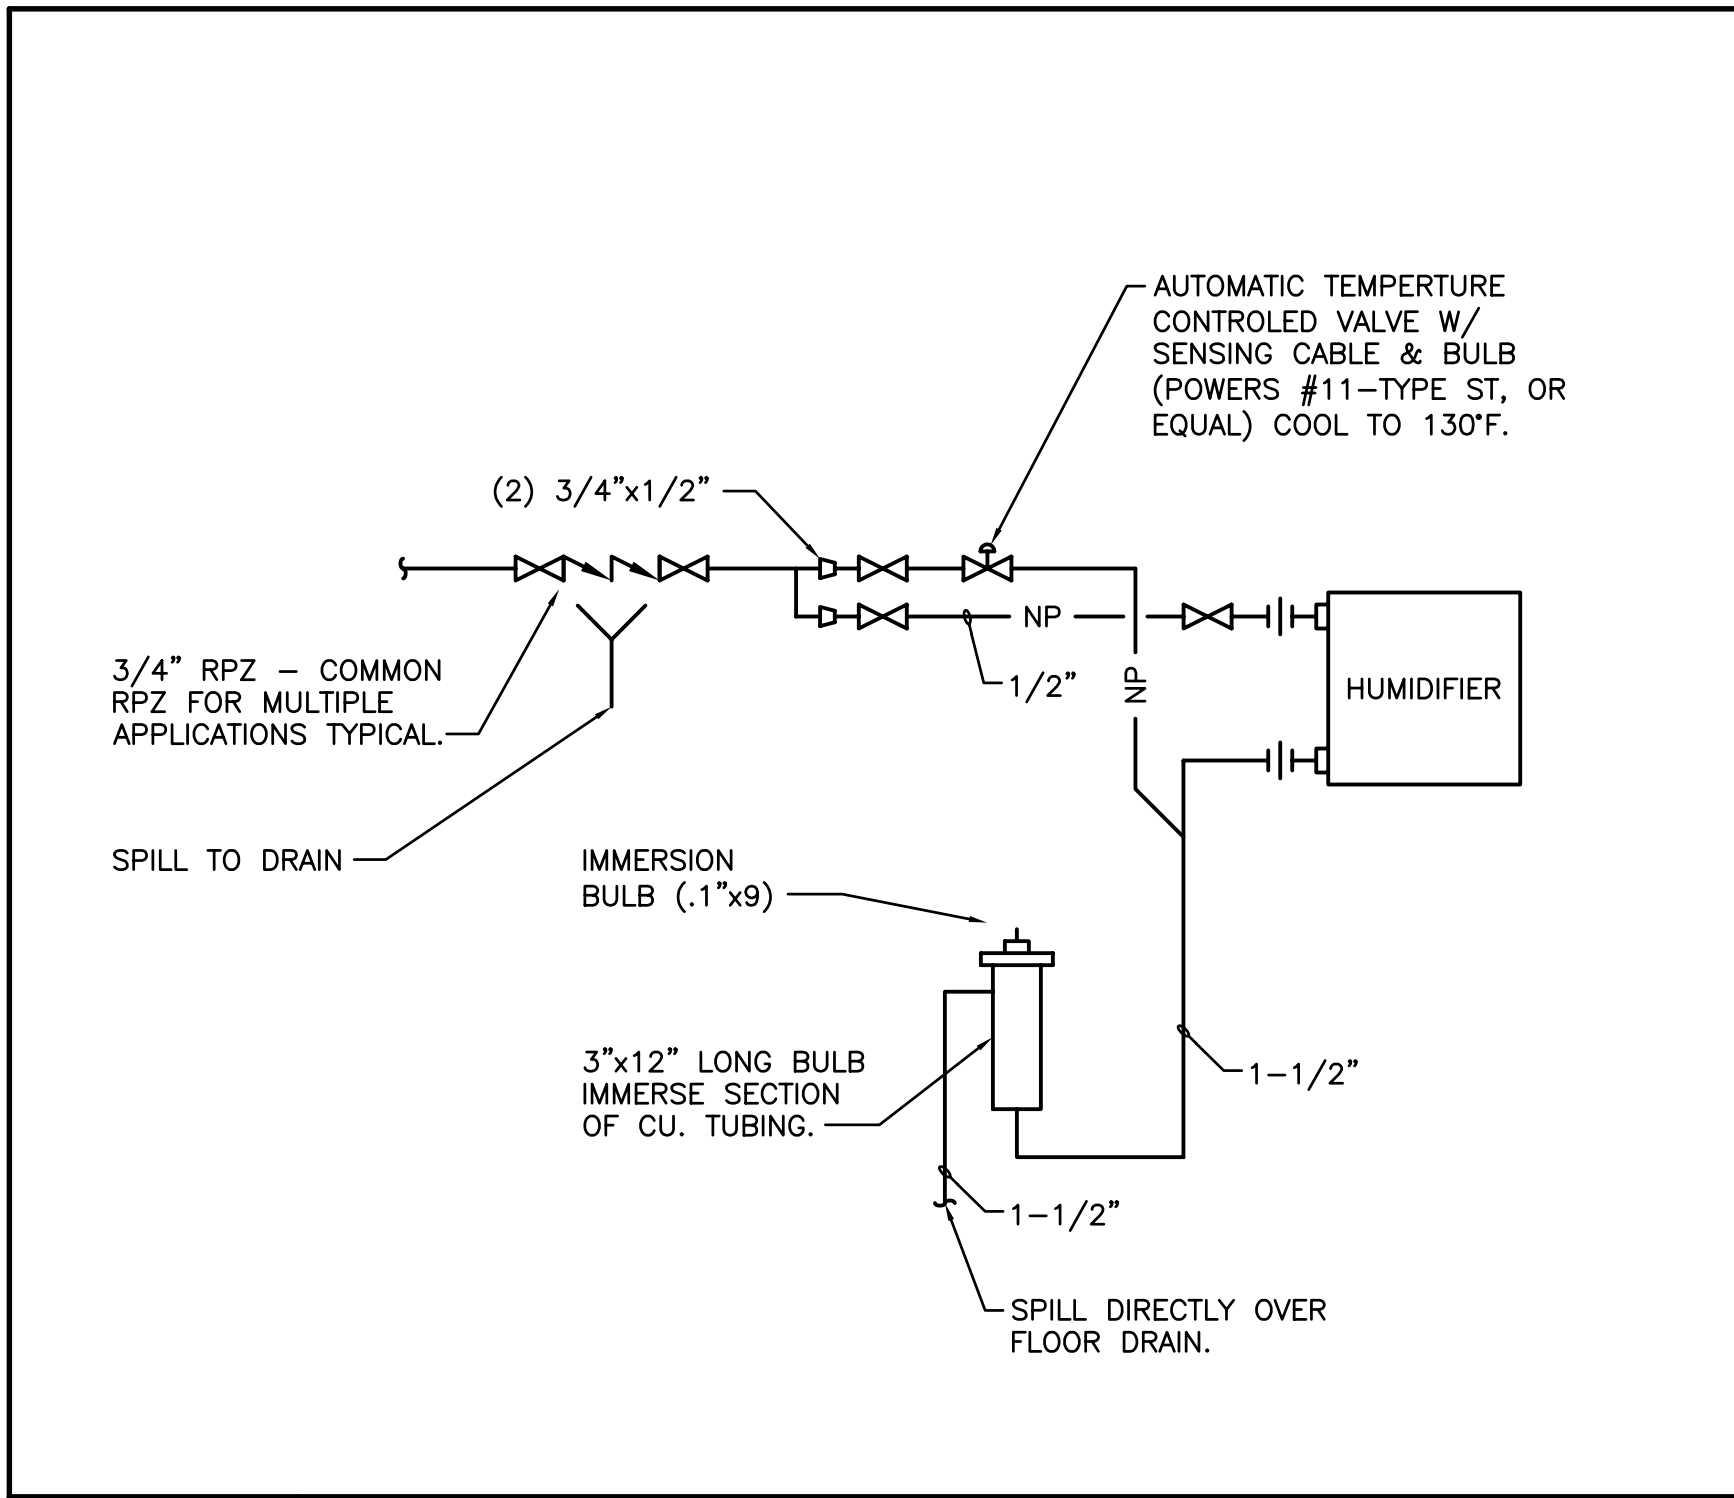

A8 HUMIDIFIER CONNECTION DETAIL
NOT TO SCALE

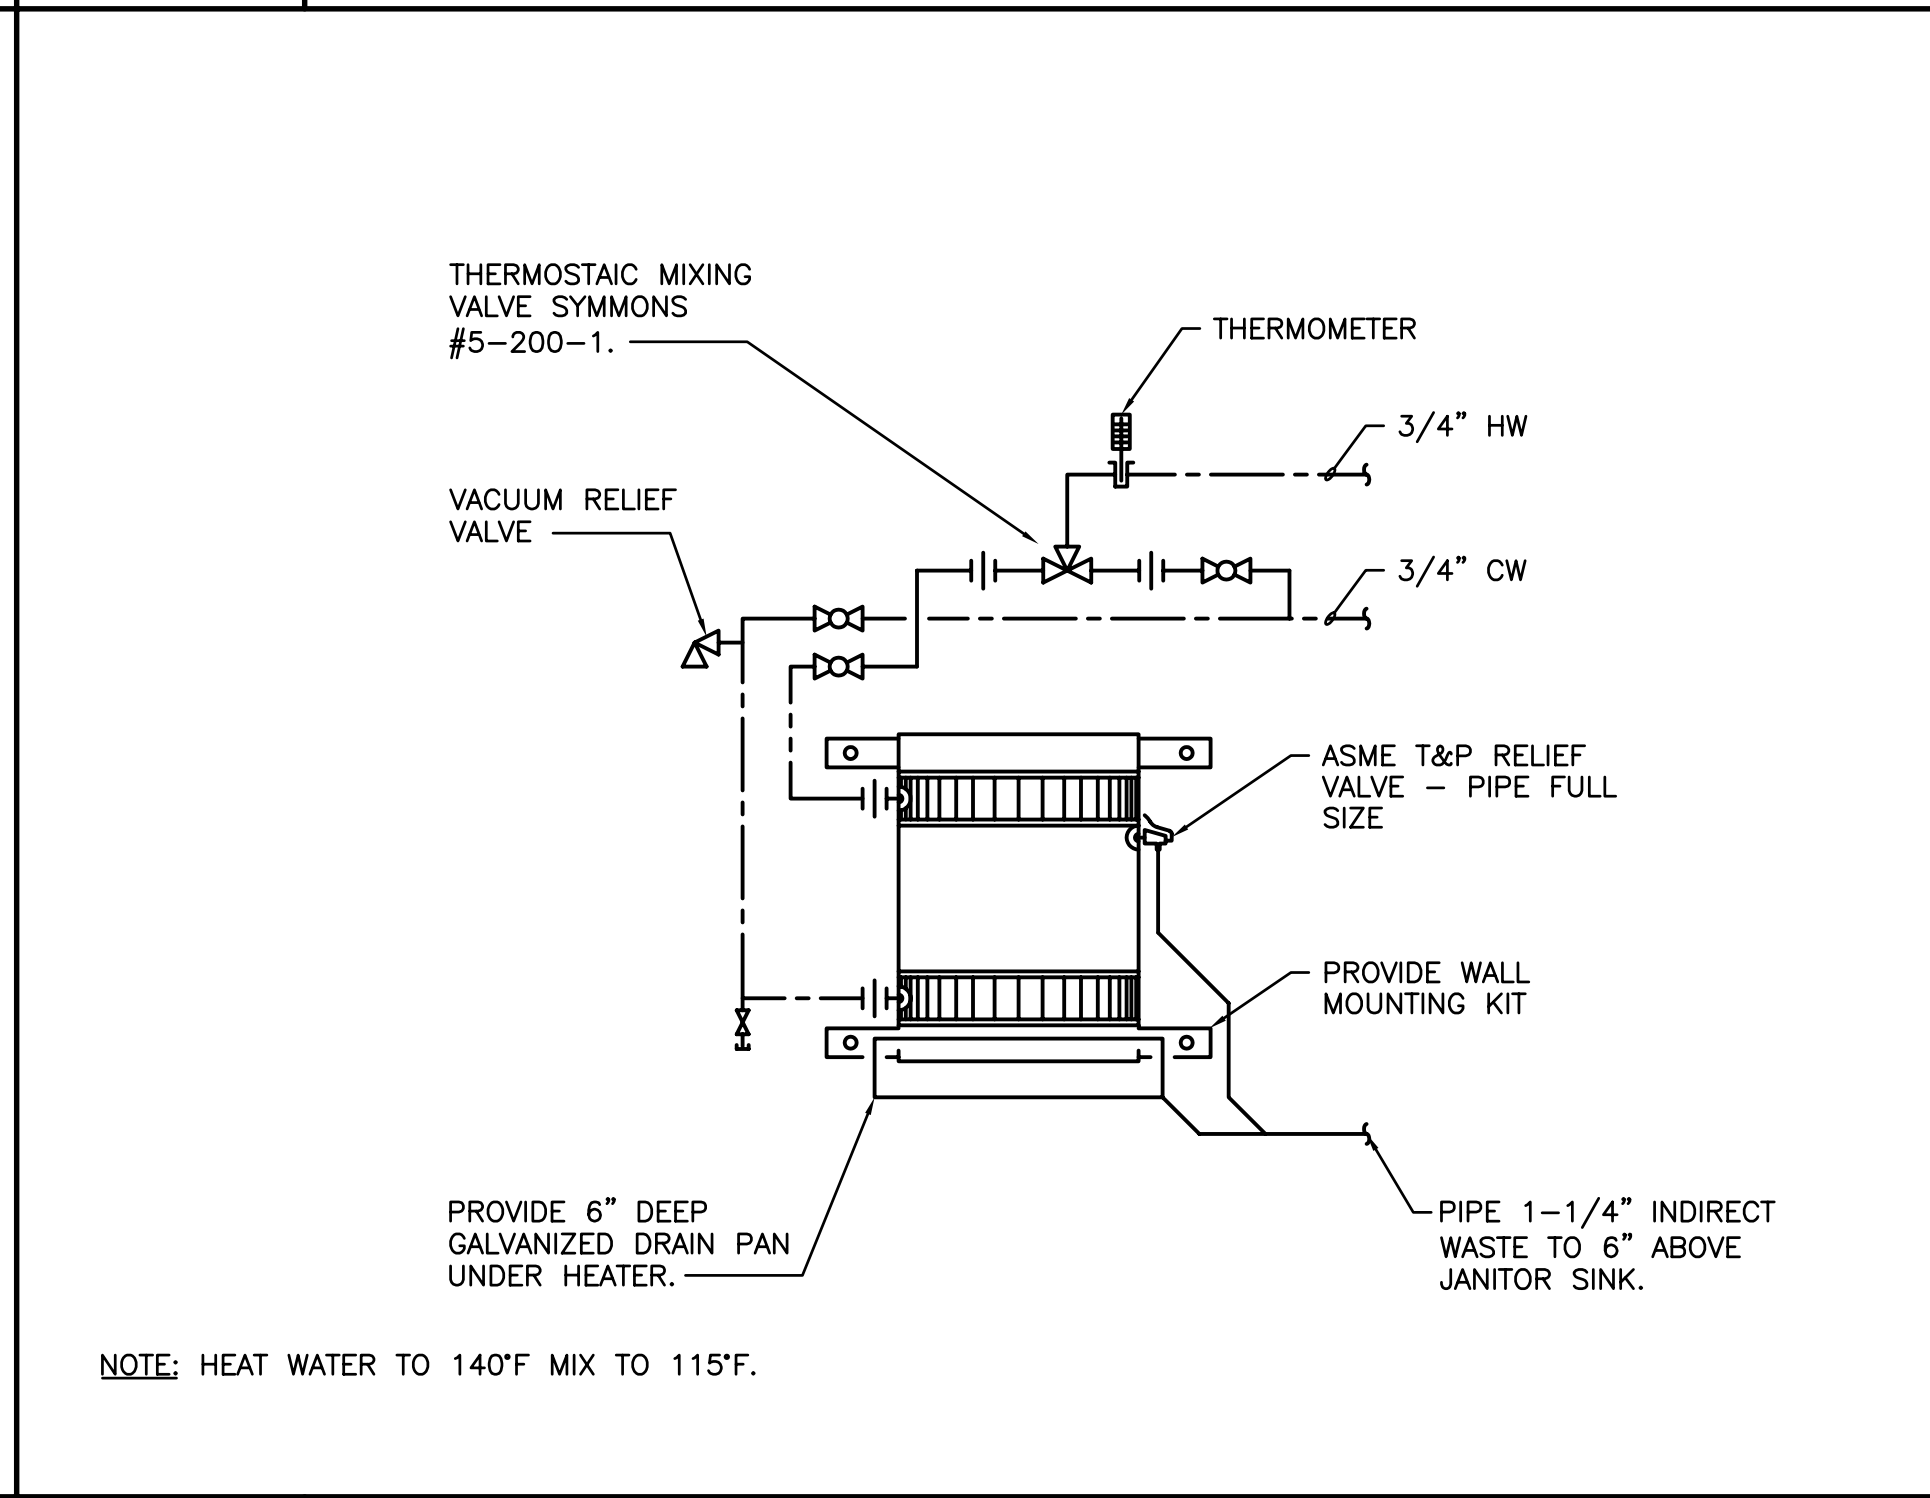

A13 ELECTRIC WATER HEATER DETAIL
NOT TO SCALE

0	ISSUED FOR CONSTRUCTION	3-17-03
REV.	DESCRIPTION	DATE

ISSUED FOR CONSTRUCTION
3-17-03
CURRENT ISSUE STATUS:

--	--	--

SMRT ARCHITECTURE ENGINEERING PLANNING
SMRT
144 Fore Street, P.O. Box 618
Portland, Maine 04104
tel. (207) 772-3846
fax. (207) 772-1070

GLICKMAN LIBRARY
UNIVERSITY OF SOUTHERN MAINE
PORTLAND, MAINE

SCHEDULES & DETAILS

SHEET TITLE:	SCALE: NOT TO SCALE	DATE: 3-17-03
PROJECT MANAGER: SLB	GRAPHIC SCALE: 0" = 1"	
JOB CAP/DRAWN: CTB/LAC		
A/E OF RECORD: DBR	SHEET No.	
SMRT CAD FILE: PL601-99092		
PROJECT No. 99092		PL601