


D1 PIPE TRENCH
SCALE: 1" = 1'-0"

LEGEND

	TRENCH FOR INSTALLATION OF GAS PIPE BACKFILL AND PATCH TO MATCH EXISTING
	4" GAS PIPE- SEE PLUMBING SPECIFICATIONS

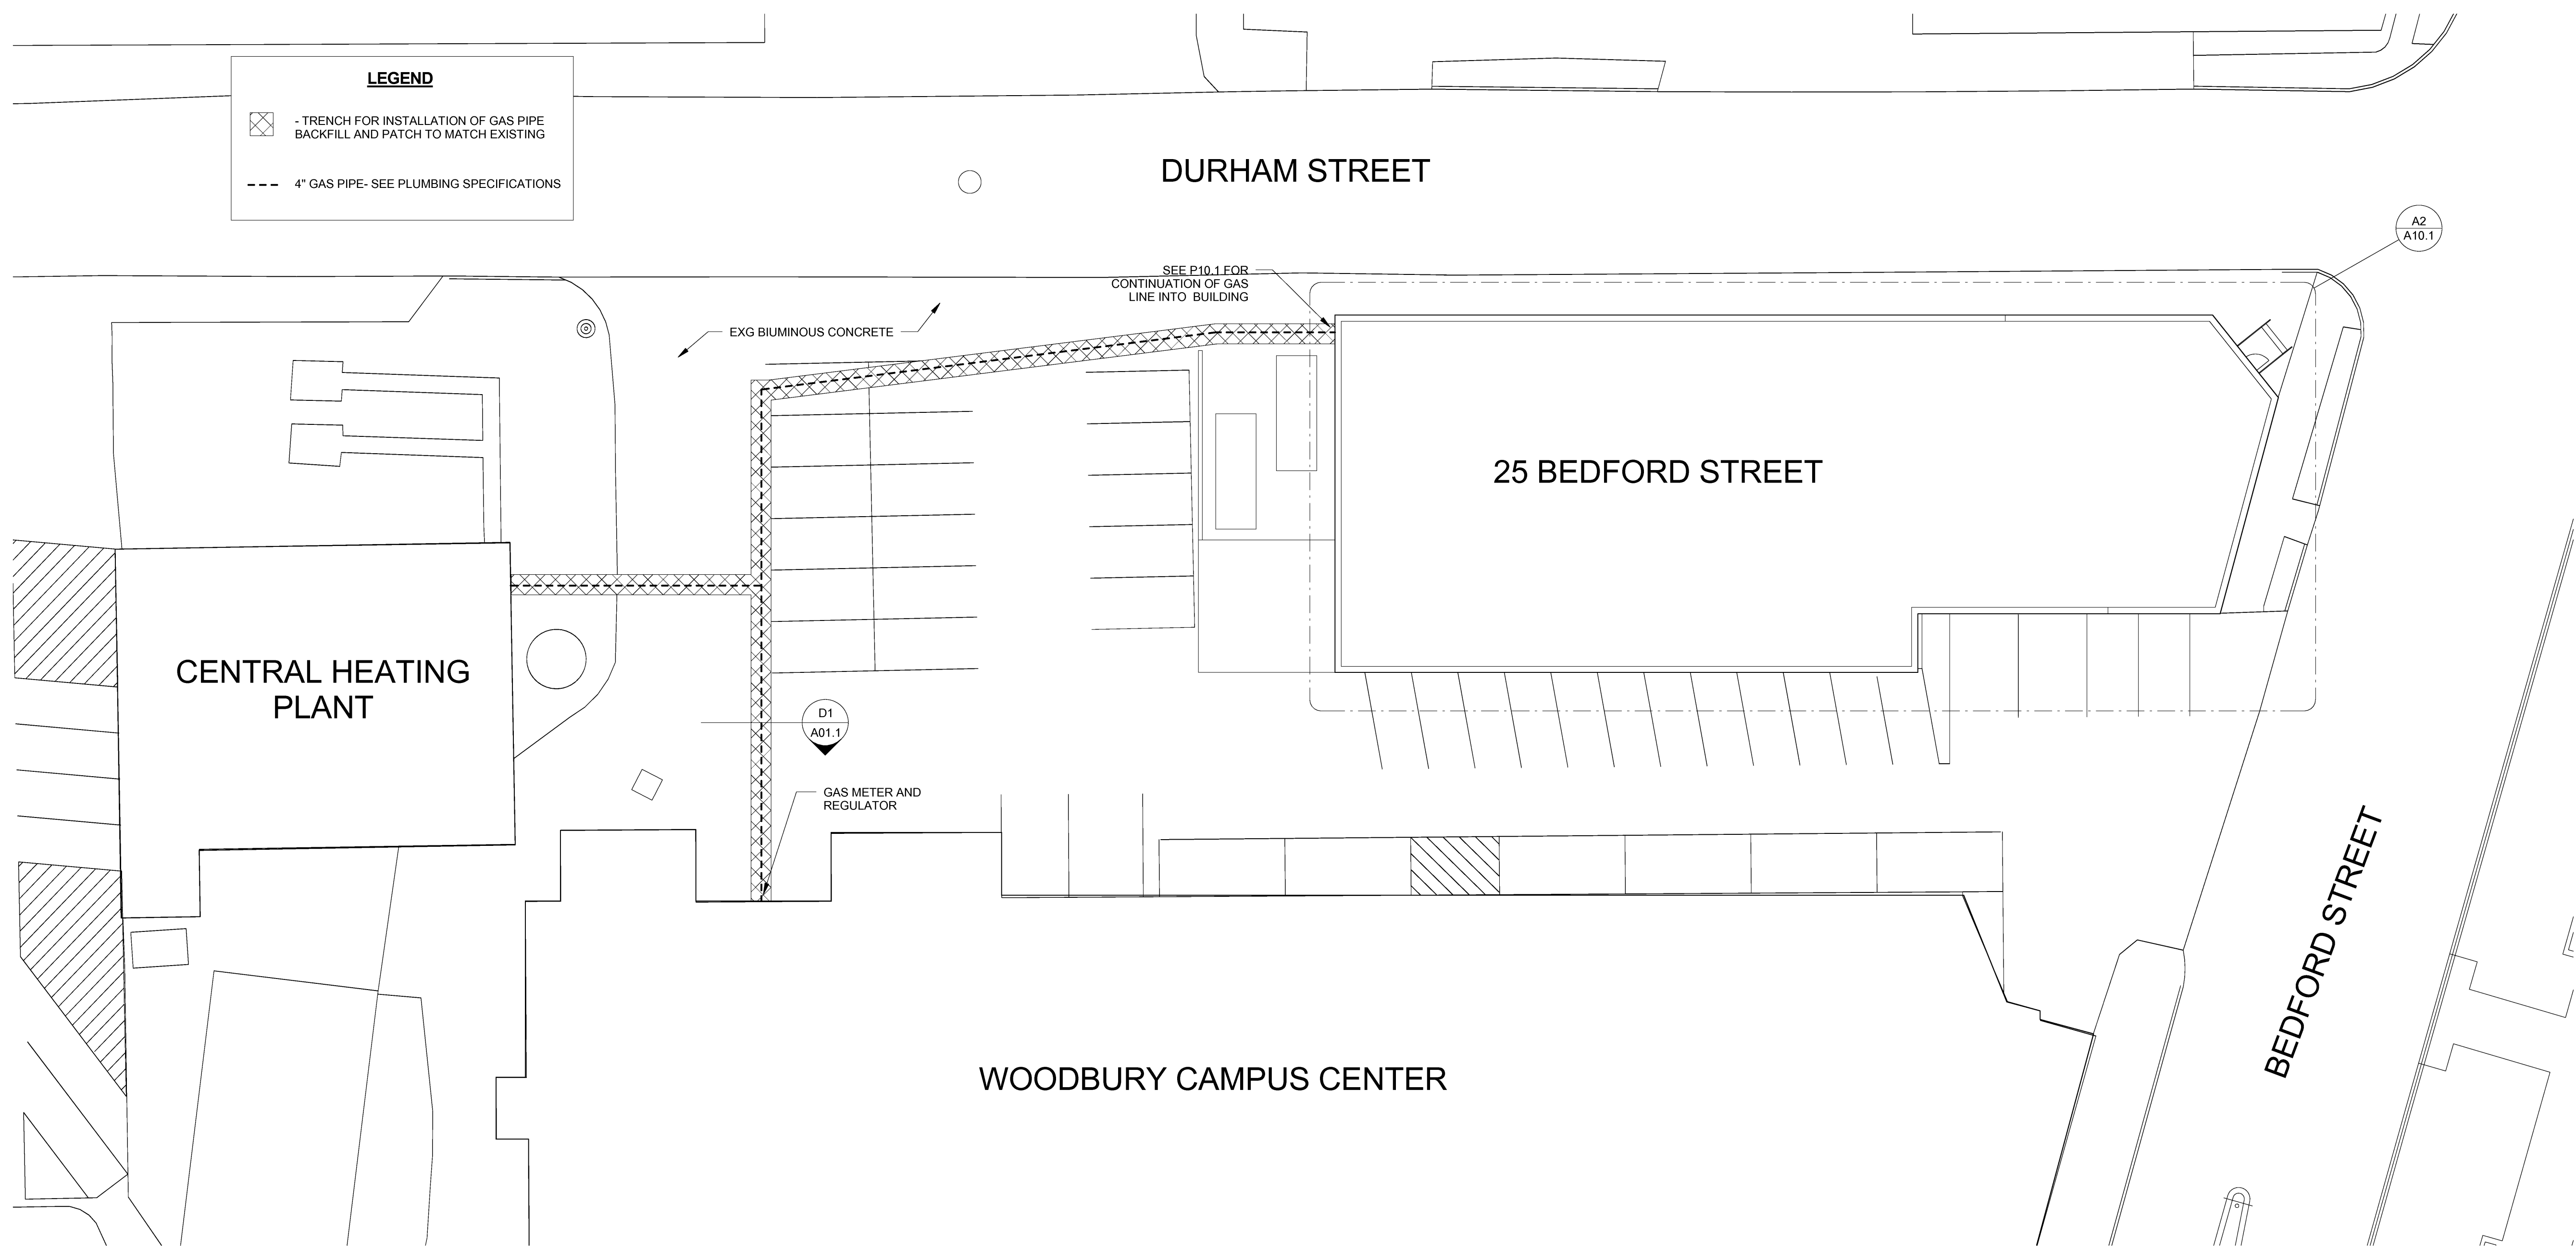

A1 SITE PLAN
SCALE: 1/16" = 1'-0"

HARRIMAN
Architects + Engineers

46 Harriman Drive
Auburn, ME 04210
207.784.5100 tel


123 Middle Street
Portland, ME 04101
207.775.0053 tel

One Perimeter Road
Manchester, NH 03103
603.626.1242 tel

www.harriman.com
© 2012

Project Title
**USM
25 BEDFORD STREET
RENOVATION**
PORTLAND, ME

Harriman Project No. 11711

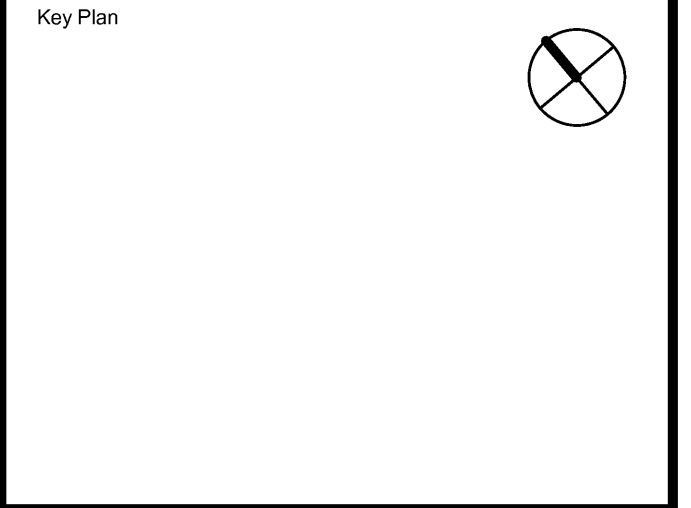

Drawing Scales	Graphic Scale
As indicated	Graphic Scale
Graphic Scale	Graphic Scale
Graphic Scale	Graphic Scale

Mark	Date	Description
	04/02/2012	ISSUED FOR BID
Issue Dates		

Drawing Status

Drawing Title
SITE PLAN

PA / PE: MDL Drawn By: BSL

Drawing Number
A01.1