

46 Harriman Drive
 Scarborough, ME 04210
 207.775.1100 tel

125 Middle Street
 Portland, ME 04101
 207.775.0053 tel

One Perimeter Road
 Manchester, NH 03103
 603.626.1242 tel

www.harriman.com
 © 2012

Project Title


USM
25 BEDFORD STREET
RENOVATION
 PORTLAND, ME

Harriman Project No. 11711


Key Plan

KEY NOTES:

- D01... WHETHER INDICATED ON PLANS OR NOT, REMOVE ALL RECEPTACLES, ELECTRICAL EQUIPMENT, LIGHTING FIXTURES, ACCESSORIES, SWITCHING AND ASSOCIATED WIRING COMPLETE IN THIS ROOM OR SPACE, EXCEPT AS SPECIFICALLY INDICATED. THIS INCLUDES MAKING ALL ELECTRICAL DISCONNECTIONS TO MECHANICAL AND PLUMBING EQUIPMENT INTENDED FOR REMOVAL BY OTHER TRADES.
- D02... THE INTENT IS FOR ALL LIGHTING FIXTURES, ACCESSORIES, SWITCHING AND WIRING IN THIS ROOM OR SPACE TO REMAIN AS IS, EXCEPT AS SPECIFICALLY INDICATED. EXTEND AND RECONNECT EXISTING WIRING AS REQUIRED TO ASSURE PROPER OPERATION.
- D03... EXISTING MECHANICAL EQUIPMENT SHALL BE ELECTRICALLY DISCONNECTED FOR REMOVAL BY OTHERS. COMPLETELY REMOVE ALL ASSOCIATED ELECTRICAL ITEMS AND WIRING BACK TO SOURCE.
- D04... ELECTRICALLY DISCONNECT AND REMOVE ELECTRIC BASEBOARD HEATER, ASSOCIATED CONTROLS AND WIRING COMPLETE BACK TO SOURCE.
- D05... LIGHT FIXTURES IN THIS AREA SHALL BE DISCONNECTED AND REMOVED FROM THE CEILING GRID WHILE DUCTWORK AND OTHER CONSTRUCTION IS BEING COMPLETED. ONCE THIS WORK IS FINISHED REINSTALL EXISTING FIXTURES IN NEW LOCATIONS AND RECONNECT AND CONTROL AS INDICATED.
- D06... DISCONNECT AND REMOVE ALL LIGHT FIXTURES IN THIS ROOM. REMOVE WIRING AND ALL ASSOCIATED ELECTRICAL ITEMS COMPLETE. EXTEND WIRING AS REQUIRED TO ASSURE PROPER OPERATION OF REMAINING ELECTRICAL ITEMS. INSTALL NEW FIXTURES AS INDICATED ON DRAWING E10.1.

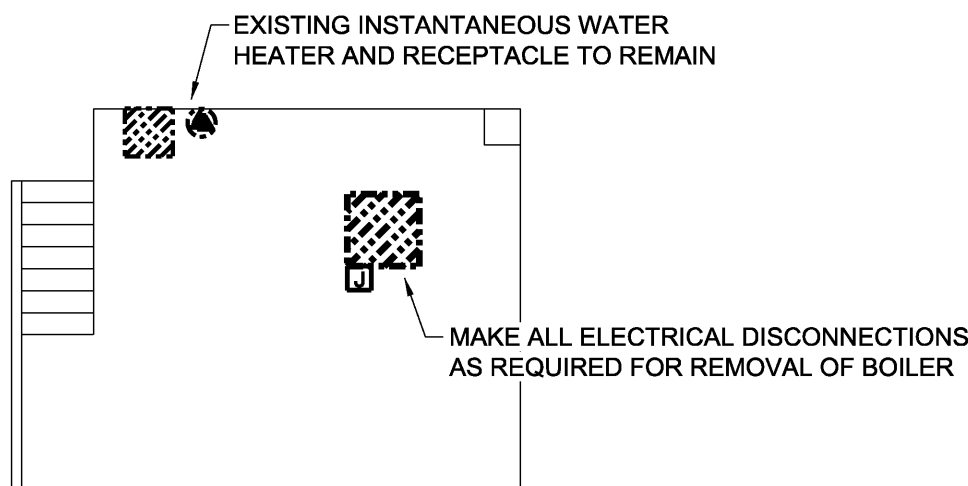

BASEMENT PLAN

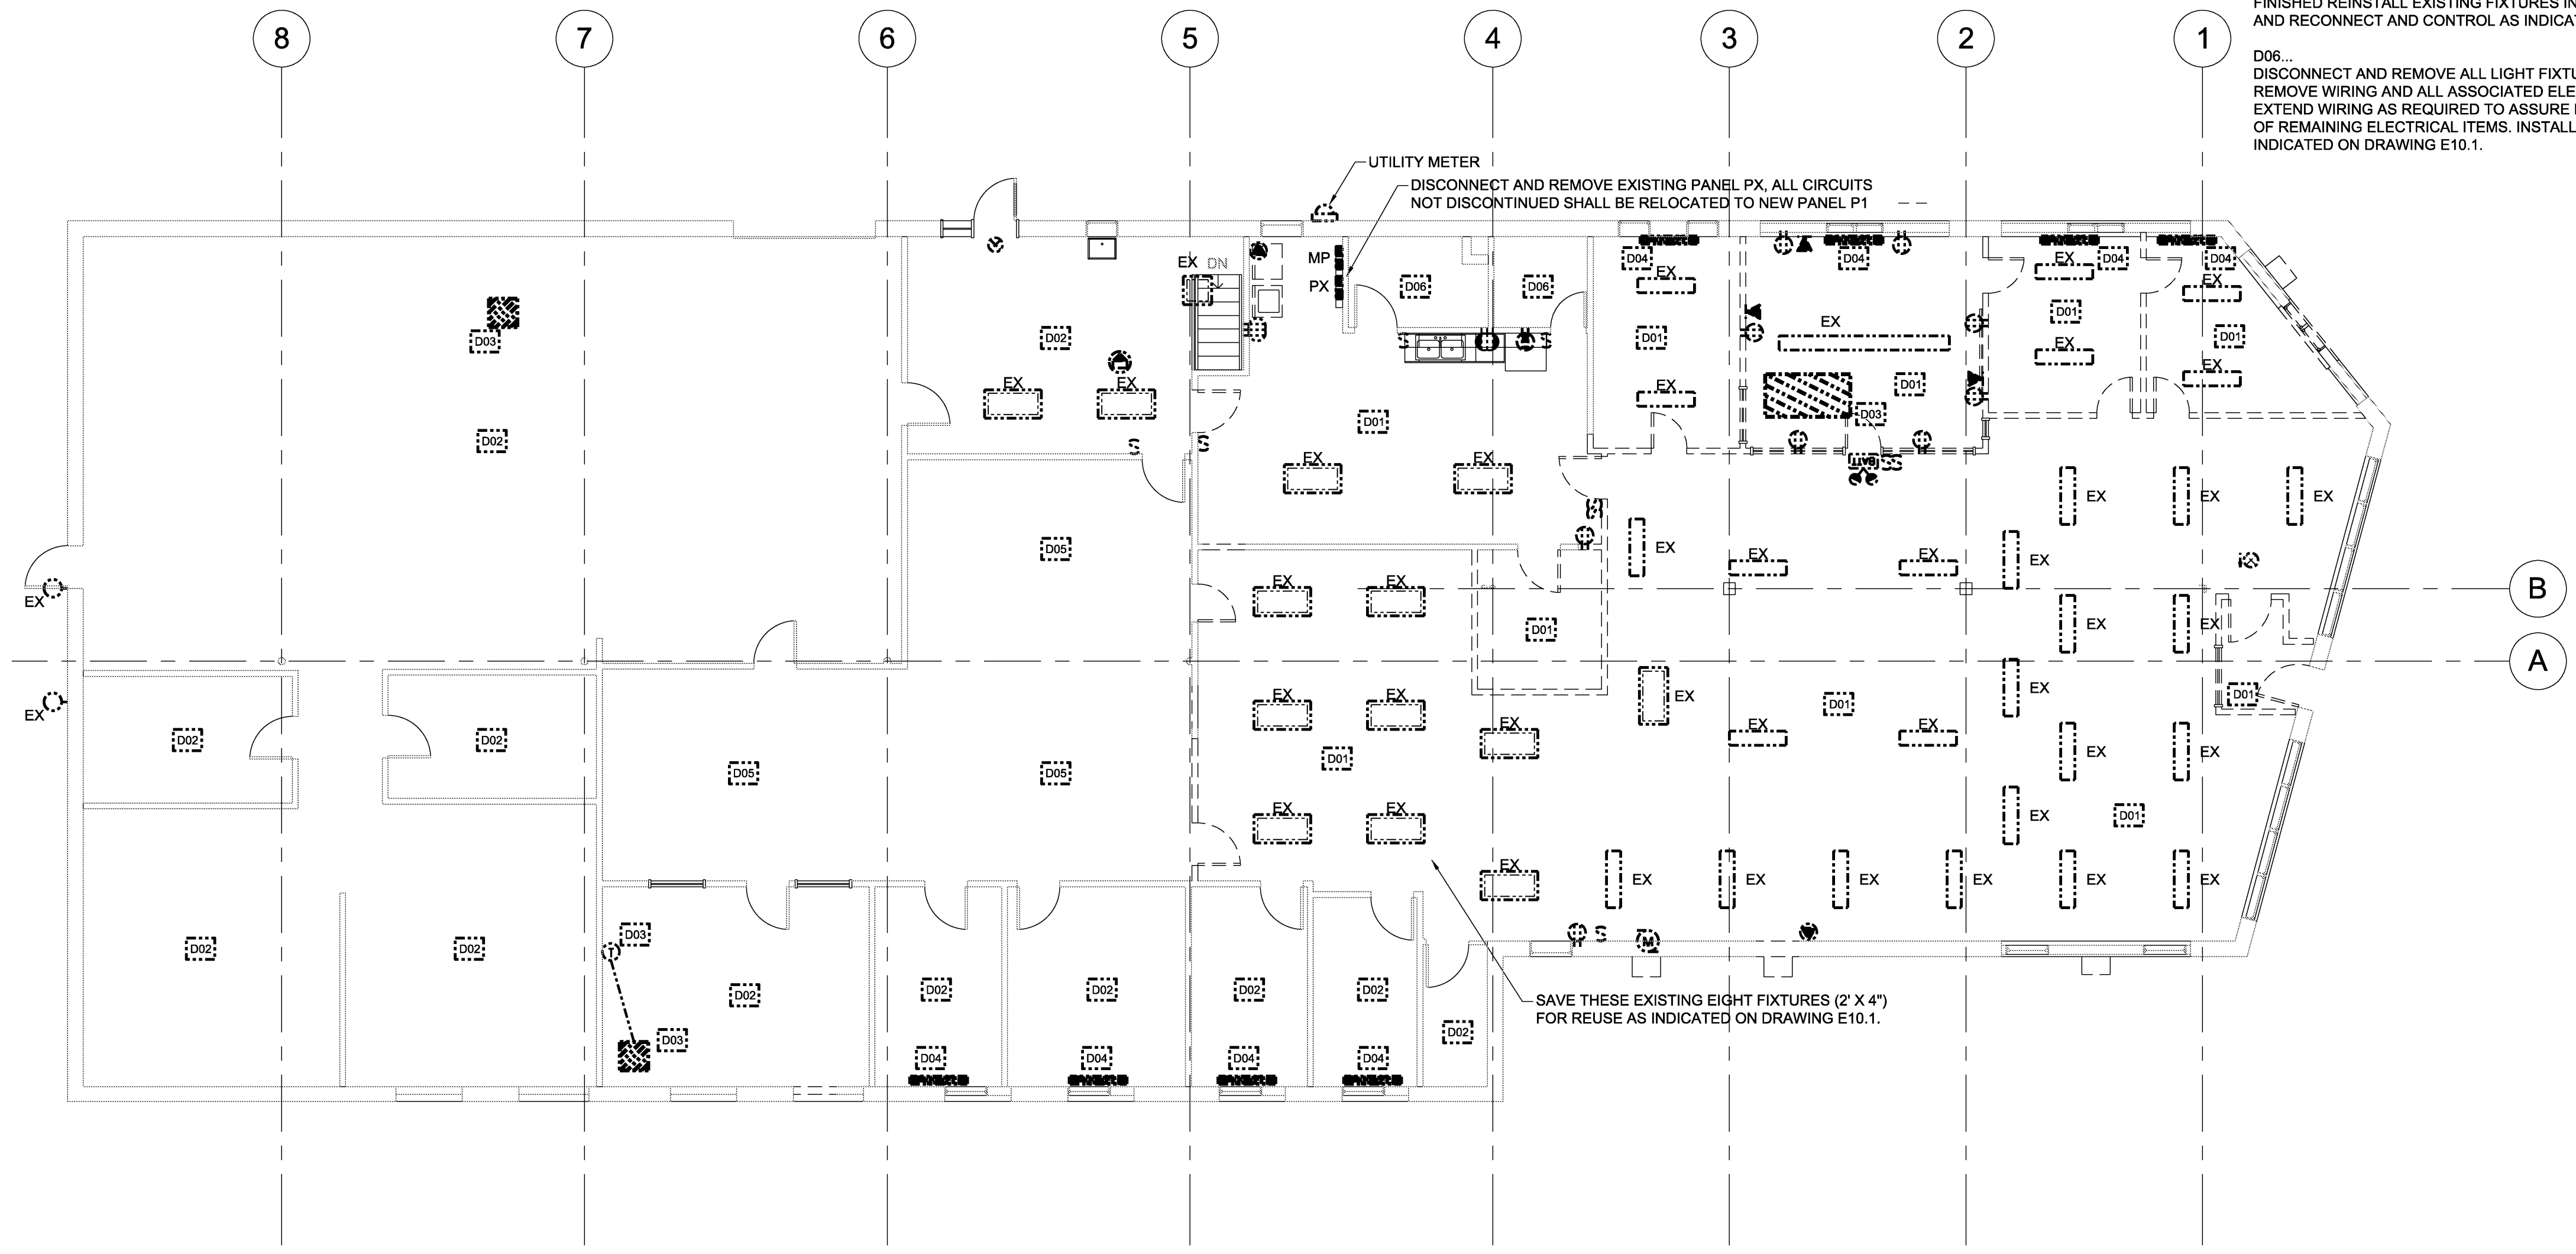

Mark	Date	Description
04-02-2012	ISSUED FOR BID	
03-12-2012	95% REVIEW	
03-02-2012	75% REVIEW	
Issue Dates		

Drawing Status

Drawing Title

FIRST FLOOR PLAN
EXISTING CONDITIONS

PA / PE: JWT Drawn By: JWT

Drawing Number

E05.1