


UNIVERSITY OF SOUTHERN MAINE

BIO-SCIENCE 3rd FLOOR LAB

RENOVATION - BIOLOGY

PORTLAND, MAINE

USM PROJECT No. 2014-008
 ALLIED PROJECT No. 14003

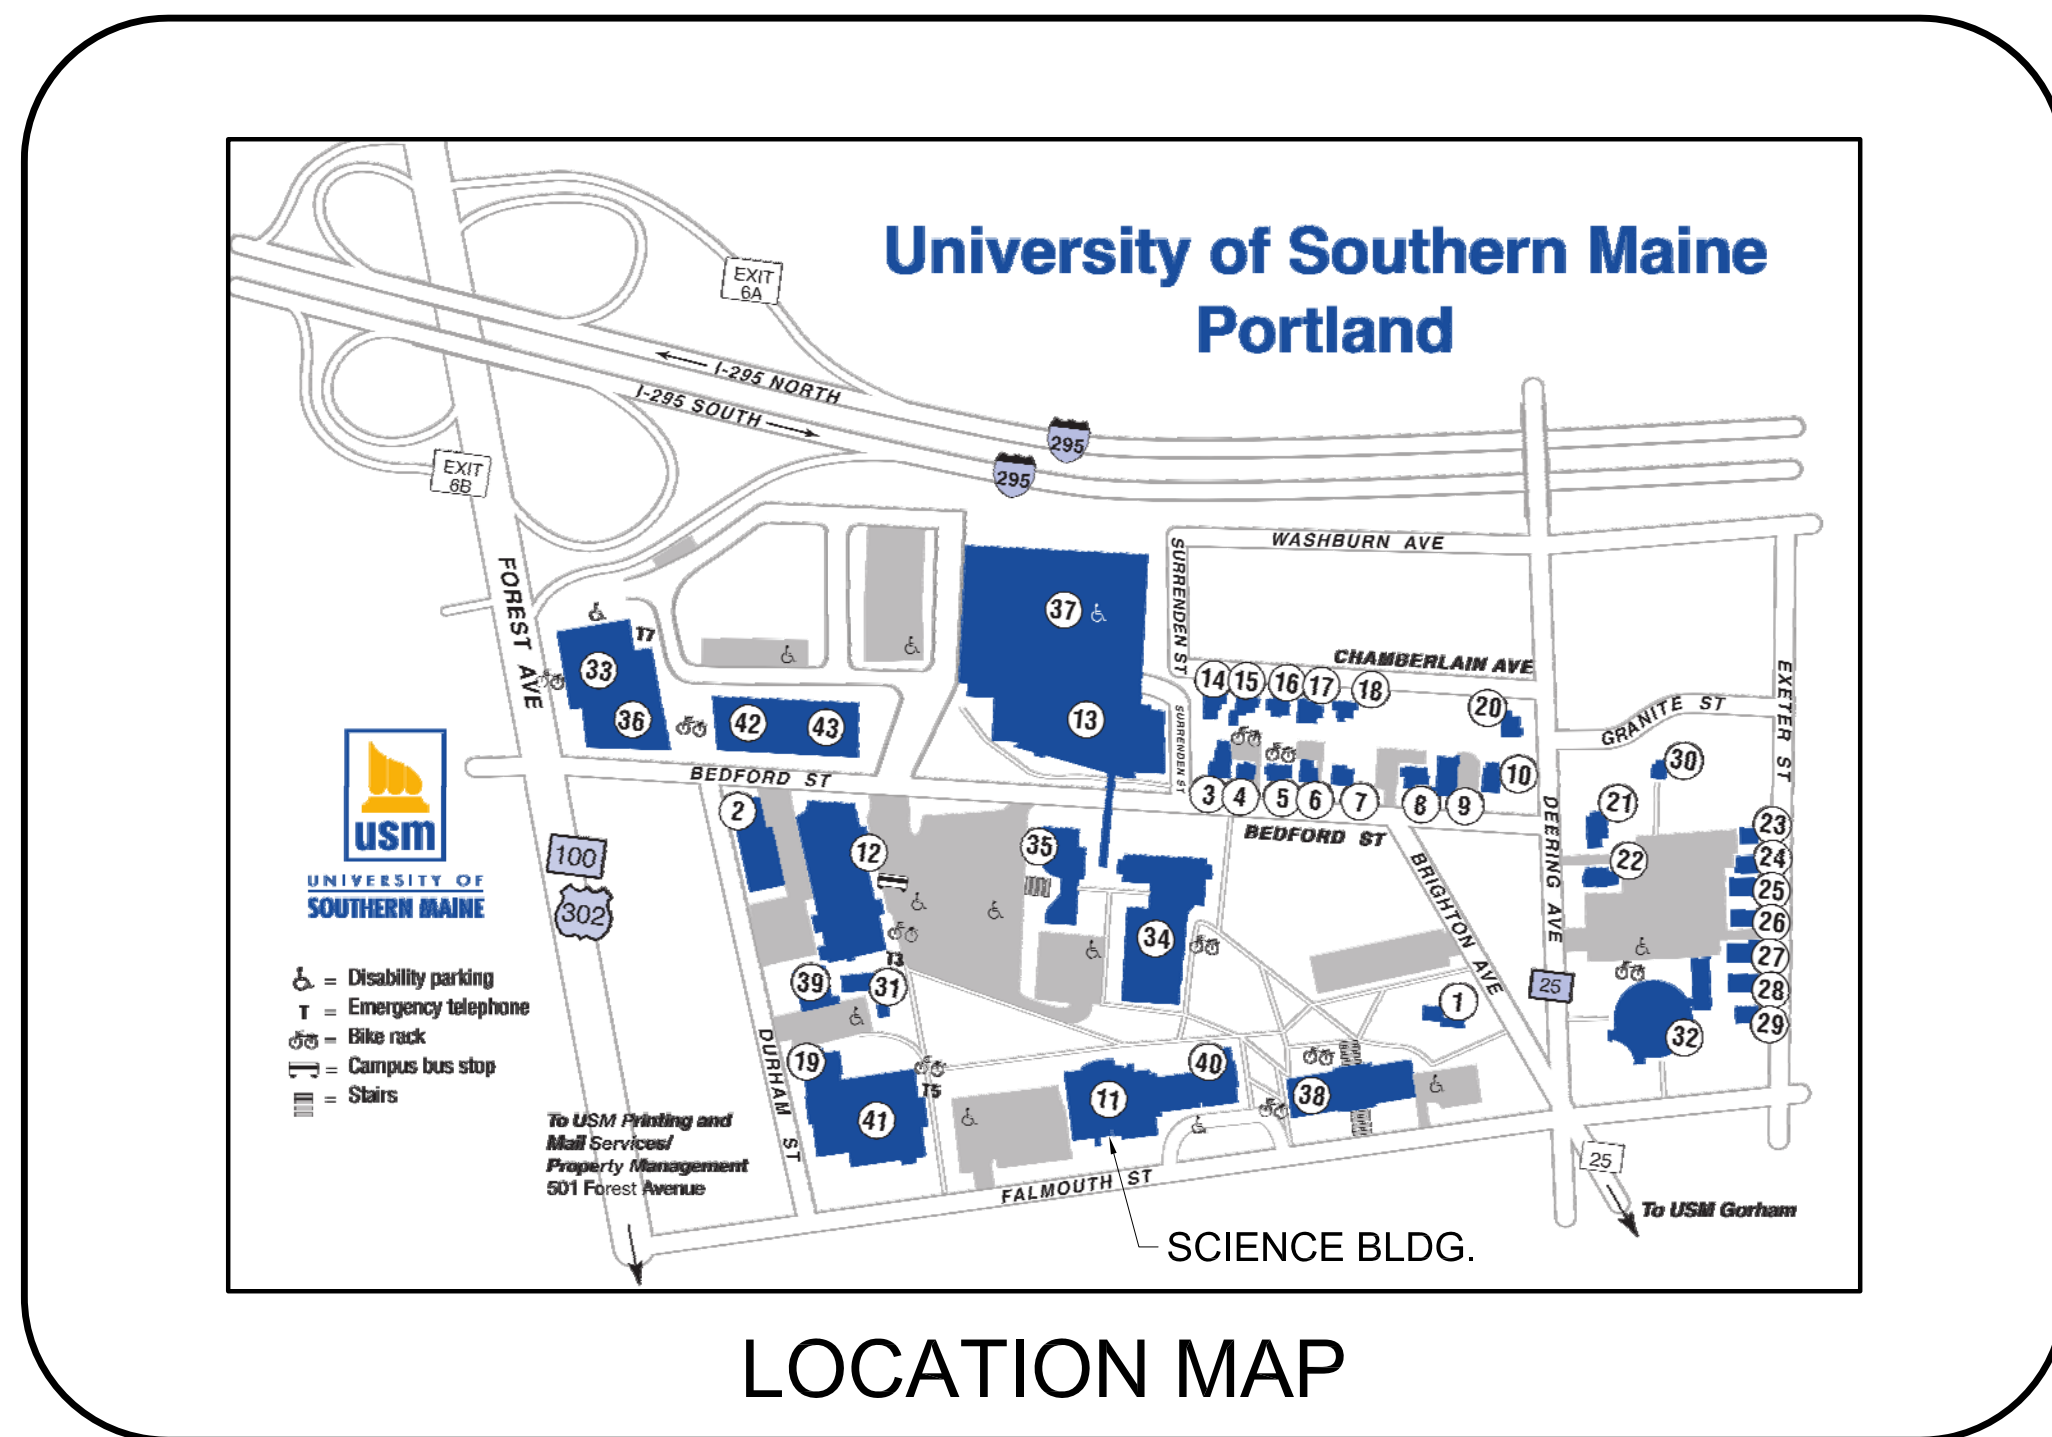

LOCATION MAP

BID DOCUMENTS
March 28, 2014

DRAWING STATUS LIST		ISSUE																	
		DESCRIPTION	DATE	DESIGN DEVELOPMENT	100% OWNER REVIEW														
DRAWINGS																			
Sht No.	SHEET TITLE																		
-	COVER SHEET																		
A-100	LOCATION OF WORK PLAN																		
A-101	FLOOR/EQUIPMENT PLAN																		
A-201	REFLECTED CEILING PLAN																		
A-301	INTERIOR ELEVATIONS																		
A-401	DOORS, ARCHITECTURAL DETAILS, SCHEDULES																		
LS-101	LIFE SAFETY PLAN																		
PL-000	PLUMBING AND HVAC NOTES, LEGEND AND ABBREVIATIONS																		
PL-100	PLUMBING AND PROCESS PIPING																		
PL-101	PROCESS AND MISCELLANEOUS PIPING																		
MD-100	MECHANICAL DEMOLITION PART PLAN																		
MH-100	MECHANICAL PART PLAN																		
MH-500	MECHANICAL DETAILS AND SCHEDULES																		
MP-100	MECHANICAL PIPING PART PLAN																		
E-000	ELECTRICAL LEGENDS, ABBREVIATIONS AND GENERAL NOTES																		
EL-100	LIGHTING PLAN																		
EP-100	POWER AND SYSTEMS PLAN																		

HKTA / architects, inc.
 482 Congress Street Suite 502
 Portland, Maine 04101

HKTA / architects

phone: 207. 774. 6016
 fax: 207. 774. 9128
 email: hkta@aol.com

Allied Engineering
 Structural Mechanical Electrical Commissioning

160 Veranda Street
 Portland, Maine 04103

T: 207.221.2260
 F: 207.221.2266
 Web: www.allied-eng.com

--	--	--	--	--