


# UNIVERSITY OF SOUTHERN MAINE SCIENCE "B" 3rd FLOOR RENOVATION PORTLAND, MAINE

USM PROJECT No. 2012-065

ALLIED PROJECT No. 12073

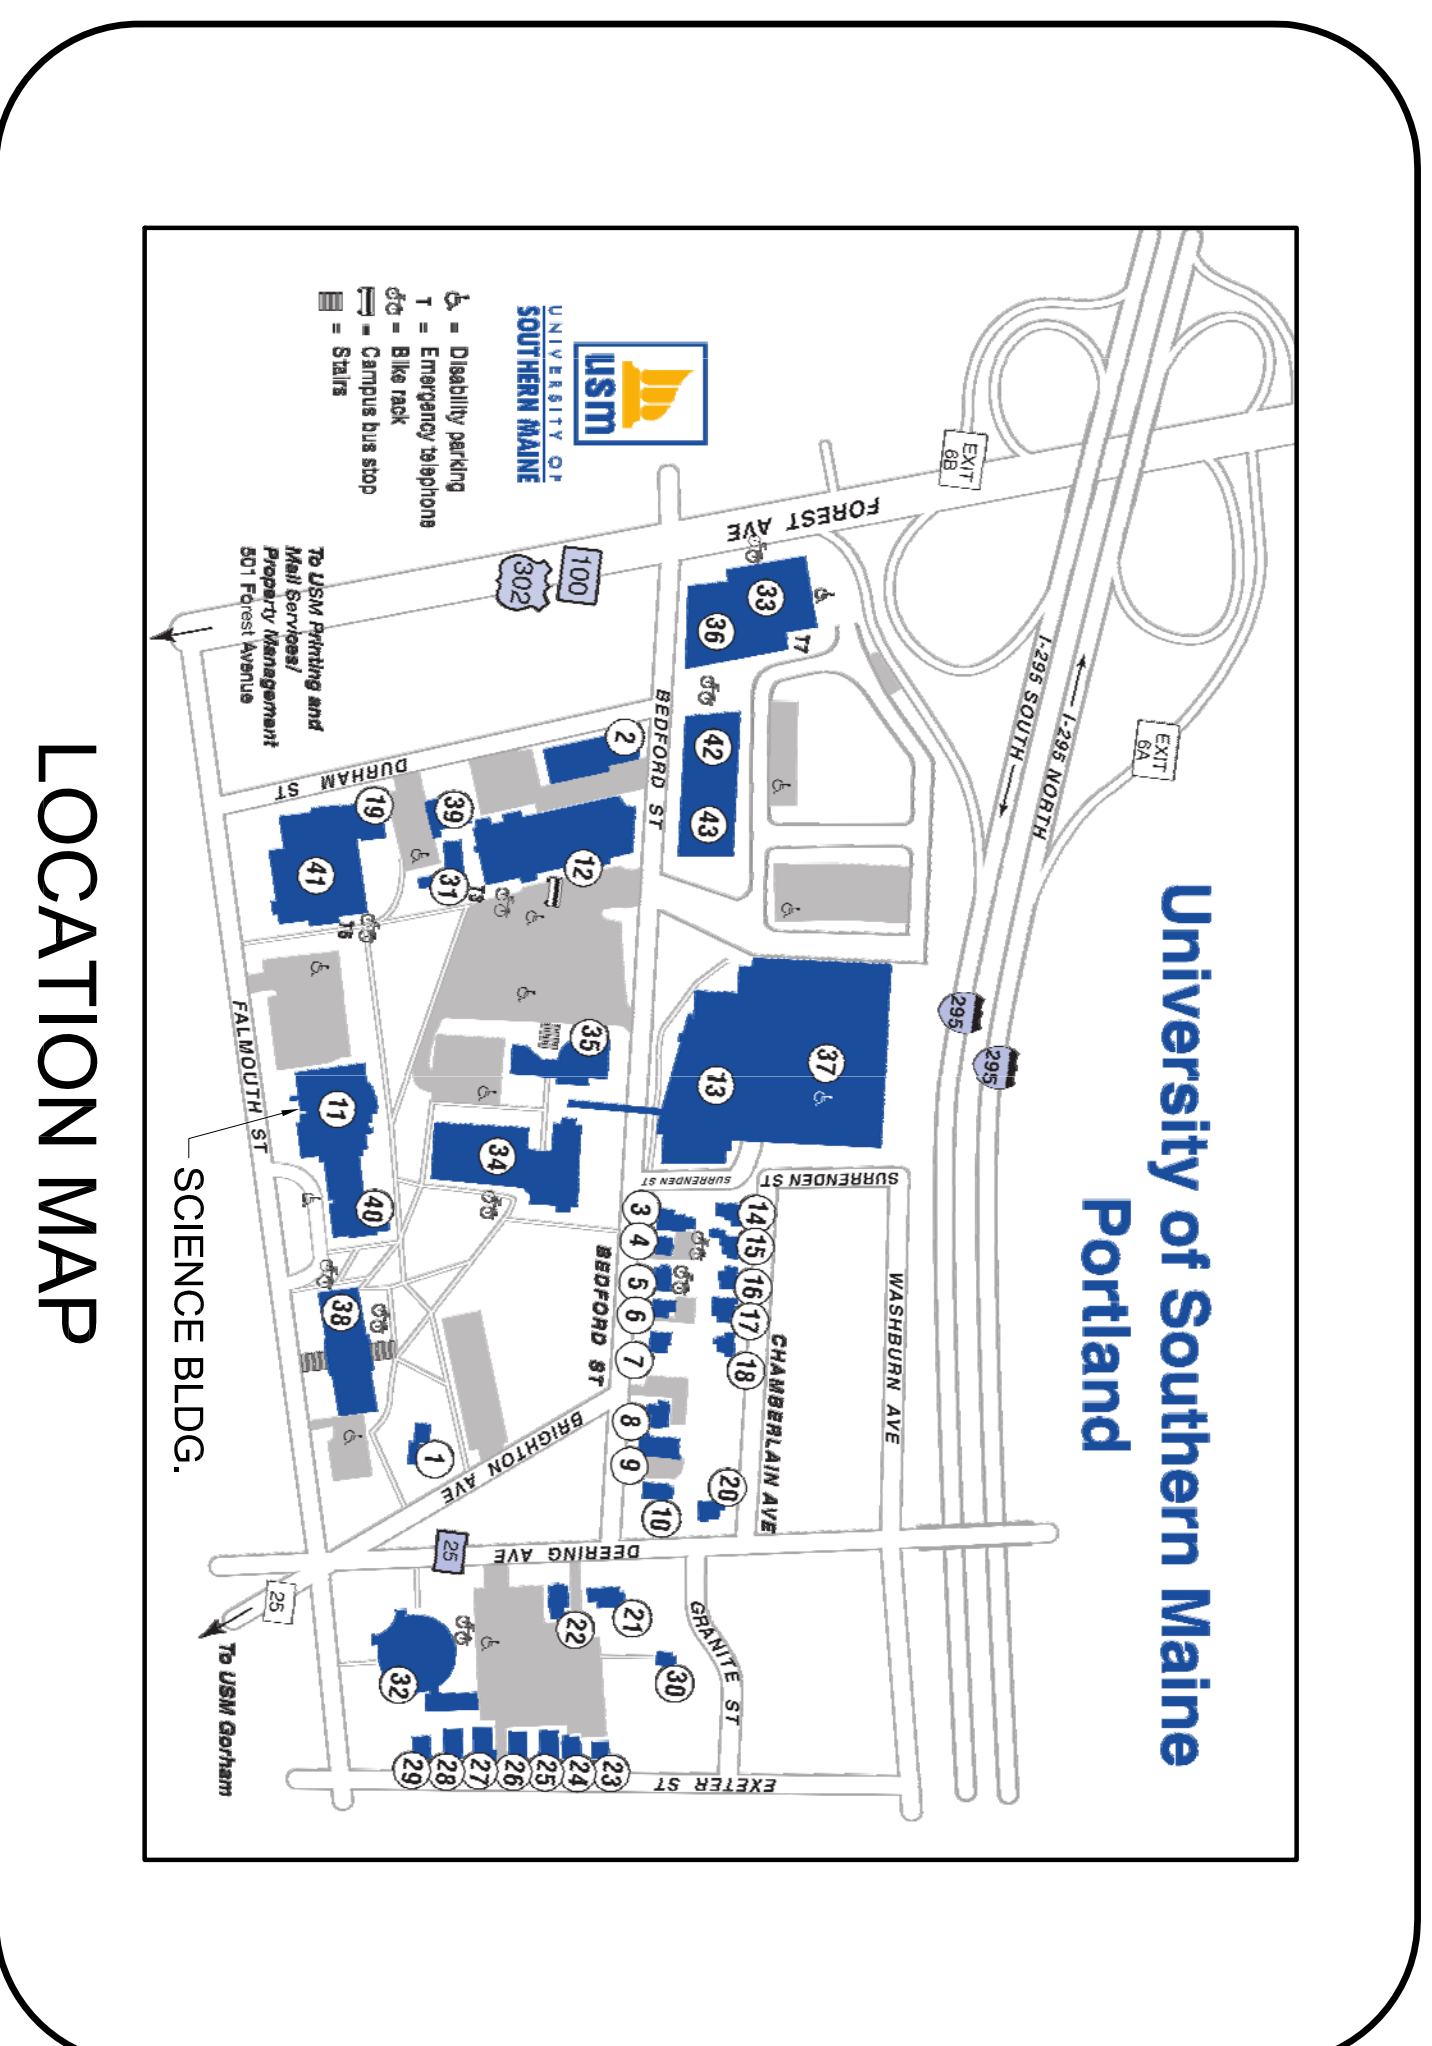

**ISSUED FOR  
CONSTRUCTION  
04-02-2013**

## DRAWING STATUS LIST

SH. No.	DRAWINGS SHEET TITLE	ISSUE	
		DESCRIPTION	DATE
-	COVER SHEET	DESIGN DEVELOPMENT	08-16-2012
D-101	DEMOLITION PLAN	100% REVIEW	09-14-2012
A-101	RENOVATION PLAN	DESIGN DEVELOPMENT	12-04-2012
A-102	REFLECTED CEILING PLAN	FOR CONSTRUCTION	04-02-2013
A-103	FINISHES PLAN		
A-201	INTERIOR ELEVATIONS		
A-301	CASEWORK DETAILS		
M-000	PLUMBING AND HVAC NOTES, LEGEND AND ABBREVIATIONS		
M-101	MECHANICAL DEMOLITION AND MECHANICAL PLANS		
E-000	ELECTRICAL LEGENDS, ABBREVIATIONS AND GENERAL NOTES		
E-101	ELECTRICAL PART PLANS		

*HKTA / architects, inc.*  
482 Congress Street Suite 502  
Portland, Maine 04101

**HKTA / architects**

phone: 207. 774. 6016  
fax: 207. 774. 9128  
email: [hkta@aol.com](mailto:hkta@aol.com)

**Allied Engineering**  
Structural Mechanical Electrical Commissioning



160 Veranda Street  
Portland, Maine 04103  
T: 207.221.2260  
F: 207.221.2266  
Web: [www.allied-eng.com](http://www.allied-eng.com)

