

DRAWING ISSUE LOG

LEGEND	
<input checked="" type="checkbox"/>	ISSUED WITH THIS PACKAGE
<input type="checkbox"/>	PREVIOUSLY ISSUED
<input type="checkbox"/>	NOT ISSUED

NO.	DRAWING NAME	DATE	ISSUED FOR CONSTRUCTION
	COVER AND DRAWING ISSUE LOG	10.10.2013	DESIGN REVIEW PACKAGE

ARCHITECTURAL

<input checked="" type="checkbox"/>	A-001	ABBREVIATIONS, SYMBOLS, DOOR AND WALL TYPES	
<input checked="" type="checkbox"/>	A-102	SECOND FLOOR PLAN	
<input checked="" type="checkbox"/>	A-103	THIRD FLOOR PLAN	
<input checked="" type="checkbox"/>	A-105	FIFTH FLOOR PLAN	
<input checked="" type="checkbox"/>	A-501	2ND AND 3RD FLOOR ENLARGED PLANS AND ELEVATIONS	
<input checked="" type="checkbox"/>	A-502	5TH FLOOR ENLARGED PLANS AND ELEVATIONS	
<input checked="" type="checkbox"/>	A-503	PLAN DETAILS	
<input checked="" type="checkbox"/>	A-600	REFLECTED CEILING PLANS 2ND, 3RD AND 5TH FLOOR	

FIRE PROTECTION

<input checked="" type="checkbox"/>	F-001	FIRE PROTECTION LEGEND AND DETAILS	
<input checked="" type="checkbox"/>	F-101	ENLARGED FIRE PROTECTION 2ND, 3RD AND 5TH FLOOR PLANS	

PLUMBING


<input checked="" type="checkbox"/>	P-001	LEGEND AND SCHEDULES	
<input checked="" type="checkbox"/>	P-101	FIRST FLOOR PLAN	
<input checked="" type="checkbox"/>	P-102	SECOND FLOOR PLAN	
<input checked="" type="checkbox"/>	P-103U	THIRD FLOOR UNDERSLAB PLAN	
<input checked="" type="checkbox"/>	P-103	THIRD FLOOR PLAN	
<input checked="" type="checkbox"/>	P-104	FOURTH FLOOR PLAN	
<input checked="" type="checkbox"/>	P-105	FIFTH FLOOR PLAN	
<input checked="" type="checkbox"/>	P-201	DOMESTIC WATER RISER DIAGRAM	
<input checked="" type="checkbox"/>	P-202	WASTE & VENT RISER DIAGRAMS	

MECHANICAL

<input checked="" type="checkbox"/>	M-401	SECOND, THIRD AND FIFTH FLOOR PART PLANS AND SCHEDULE	
-------------------------------------	-------	---	--

ELECTRICAL

<input checked="" type="checkbox"/>	E-001	LEGEND	
<input checked="" type="checkbox"/>	E-002	FIXTURE SCHEDULE AND NOTES	
<input checked="" type="checkbox"/>	E-102	SECOND FLOOR PLANS	
<input checked="" type="checkbox"/>	E-103	THIRD FLOOR PLANS	
<input checked="" type="checkbox"/>	E-105	FIFTH FLOOR PLANS	

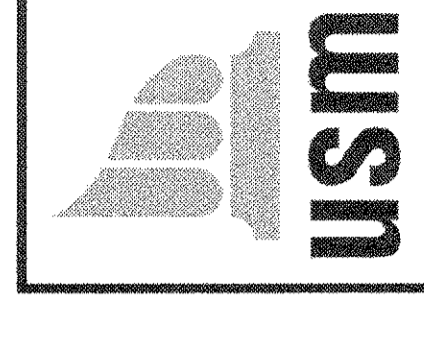

UNIVERSITY OF
SOUTHERN MAINE

UNIVERSITY OF SOUTHERN MAINE

BIO-SCIENCE BUILDING TOILET ROOM FIT-UP
SECOND, THIRD AND FIFTH FLOORS
USM PROJECT NUMBER 2012-066

70 FALMOUTH STREET, PORTLAND, ME


ISSUED FOR CONSTRUCTION 10/10/2013

PROJECT # 11082.04

TEAM:

ARCHITECTURAL DESIGNER Derek Osterman
FIRE PROTECTION Bob Marshall
PLUMBING Bob Marshall
MECHANICAL Michael Coppola
ELECTRICAL Mark Blundell

PROJECT MANAGER Bob Hicks

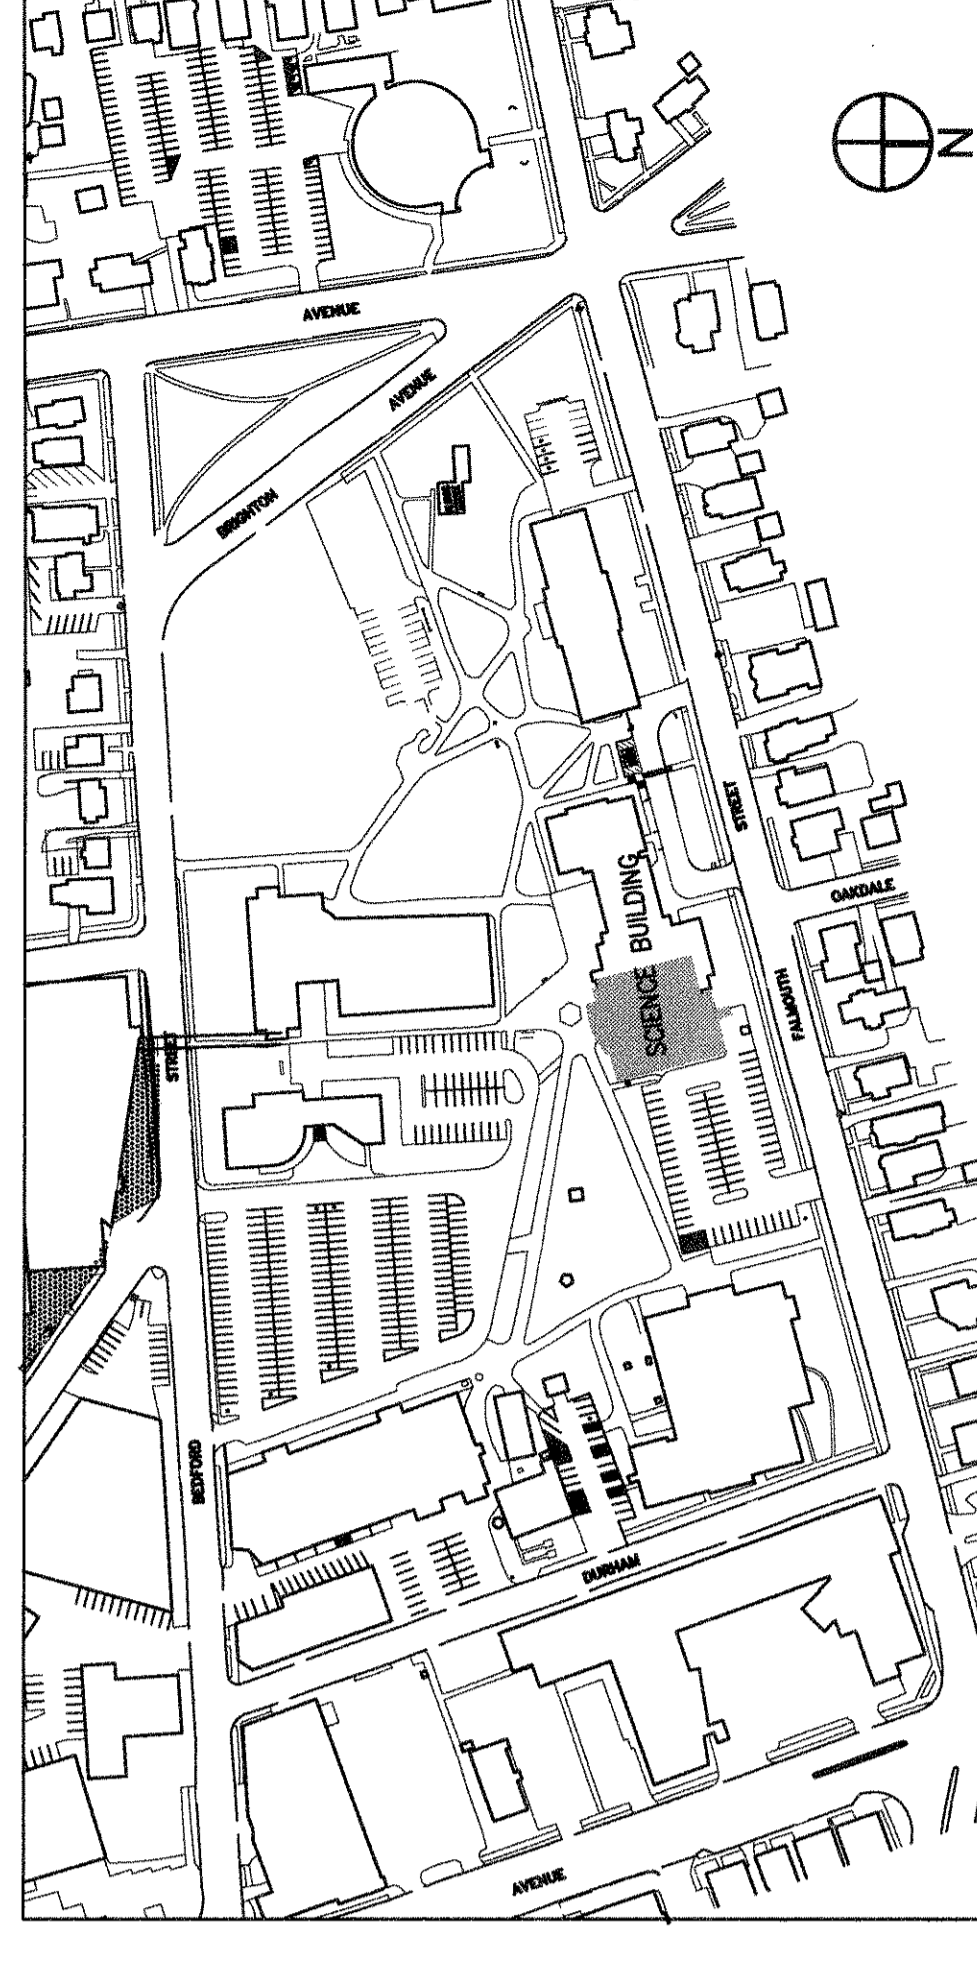

CAMPUS MAP

SMMA

Cambridge | Chapel Hill | Providence