


UNIVERSITY OF SOUTHERN MAINE LUTHER BONNEY HEATING UPGRADES

USM PROJECT No. 2012-038

PORTLAND, MAINE

ALLIED PROJECT No. 13102

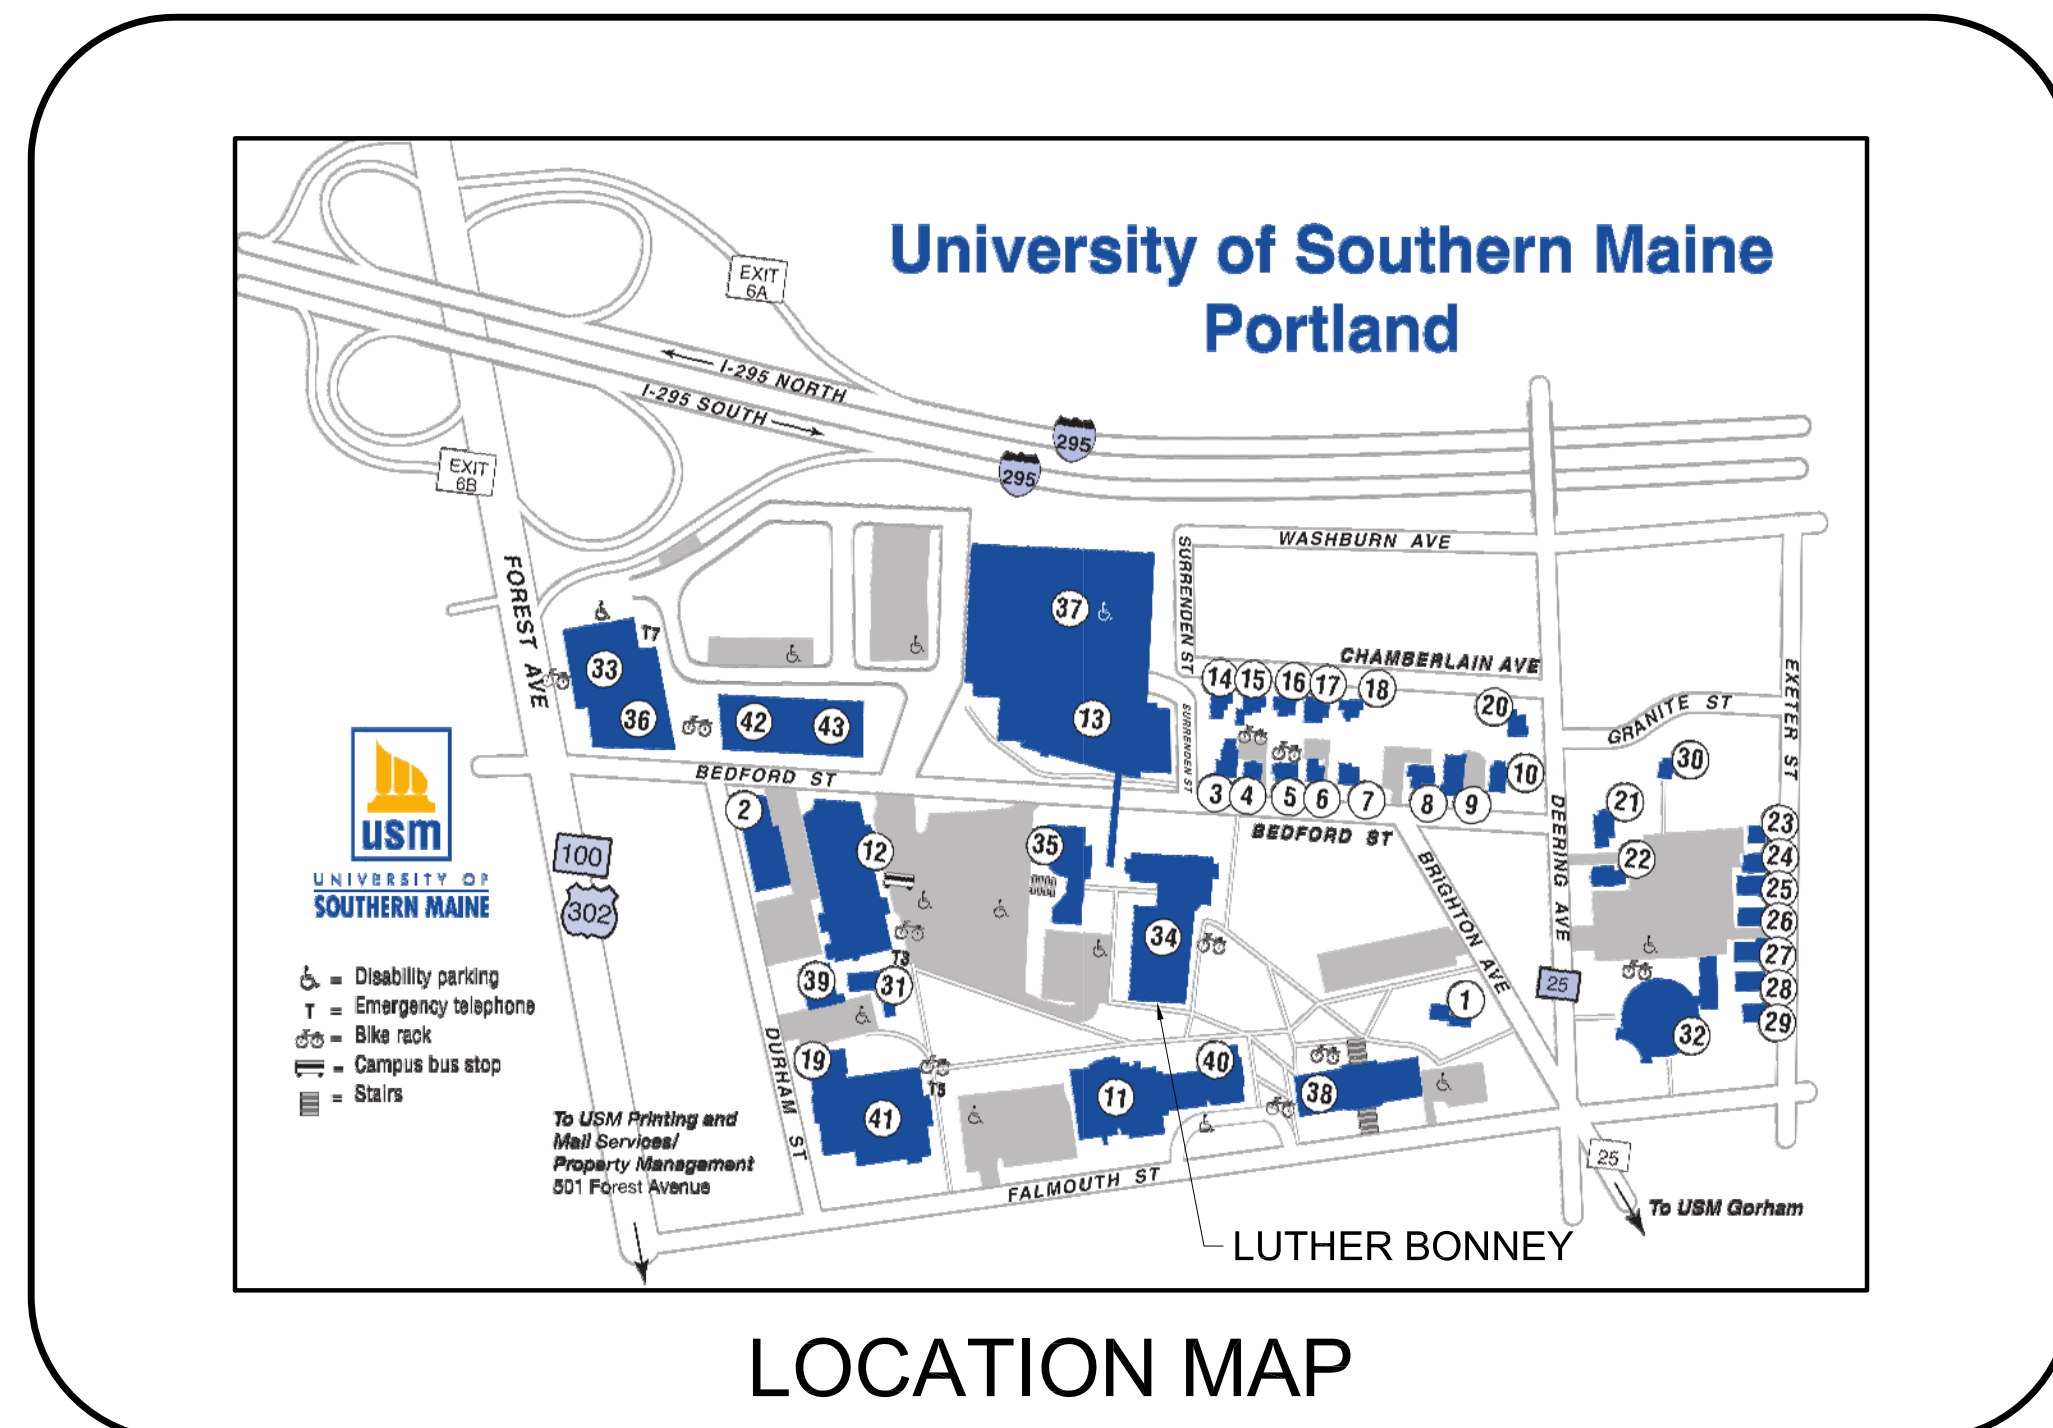

**ISSUED FOR
CONSTRUCTION
2-14-2014**

DRAWING STATUS LIST		ISSUE	DATE							
			DESCRIPTION	ISSUED FOR REVIEW	ISSUED FOR CONSTRUCTION					
DRAWINGS										
Sht No.	SHEET TITLE									
-	COVER SHEET									
MH-000	MECHANICAL, ABBREVIATIONS AND LEGEND									
MD-100	MECHANICAL DEMOLITION SECOND AND THIRD FLOOR PLANS									
MD-101	MECHANICAL DEMOLITION FOURTH AND FIFTH FLOOR PLANS									
MD-102	NOT USED									
MH-100	MECHANICAL SECOND AND THIRD FLOOR PLANS									
MH-101	MECHANICAL FOURTH AND FIFTH FLOOR PLANS									
MH-102	NOT USED									
MH-500	MECHANICAL SCHEDULES DETAILS AND NOTES									
E-100	ELECTRICAL PLANS BASEMENT AND FIRST FLOORS									
E-101	ELECTRICAL PLANS SECOND AND THIRD FLOORS									
E-102	ELECTRICAL PLANS FOURTH AND FIFTH FLOORS									

Allied Engineering
Structural Mechanical Electrical Commissioning

160 Veranda Street
Portland, Maine 04103

T: 207.221.2260

F: 207.221.2266

Web: www.allied-eng.com

