
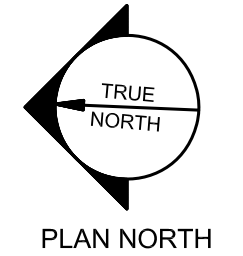
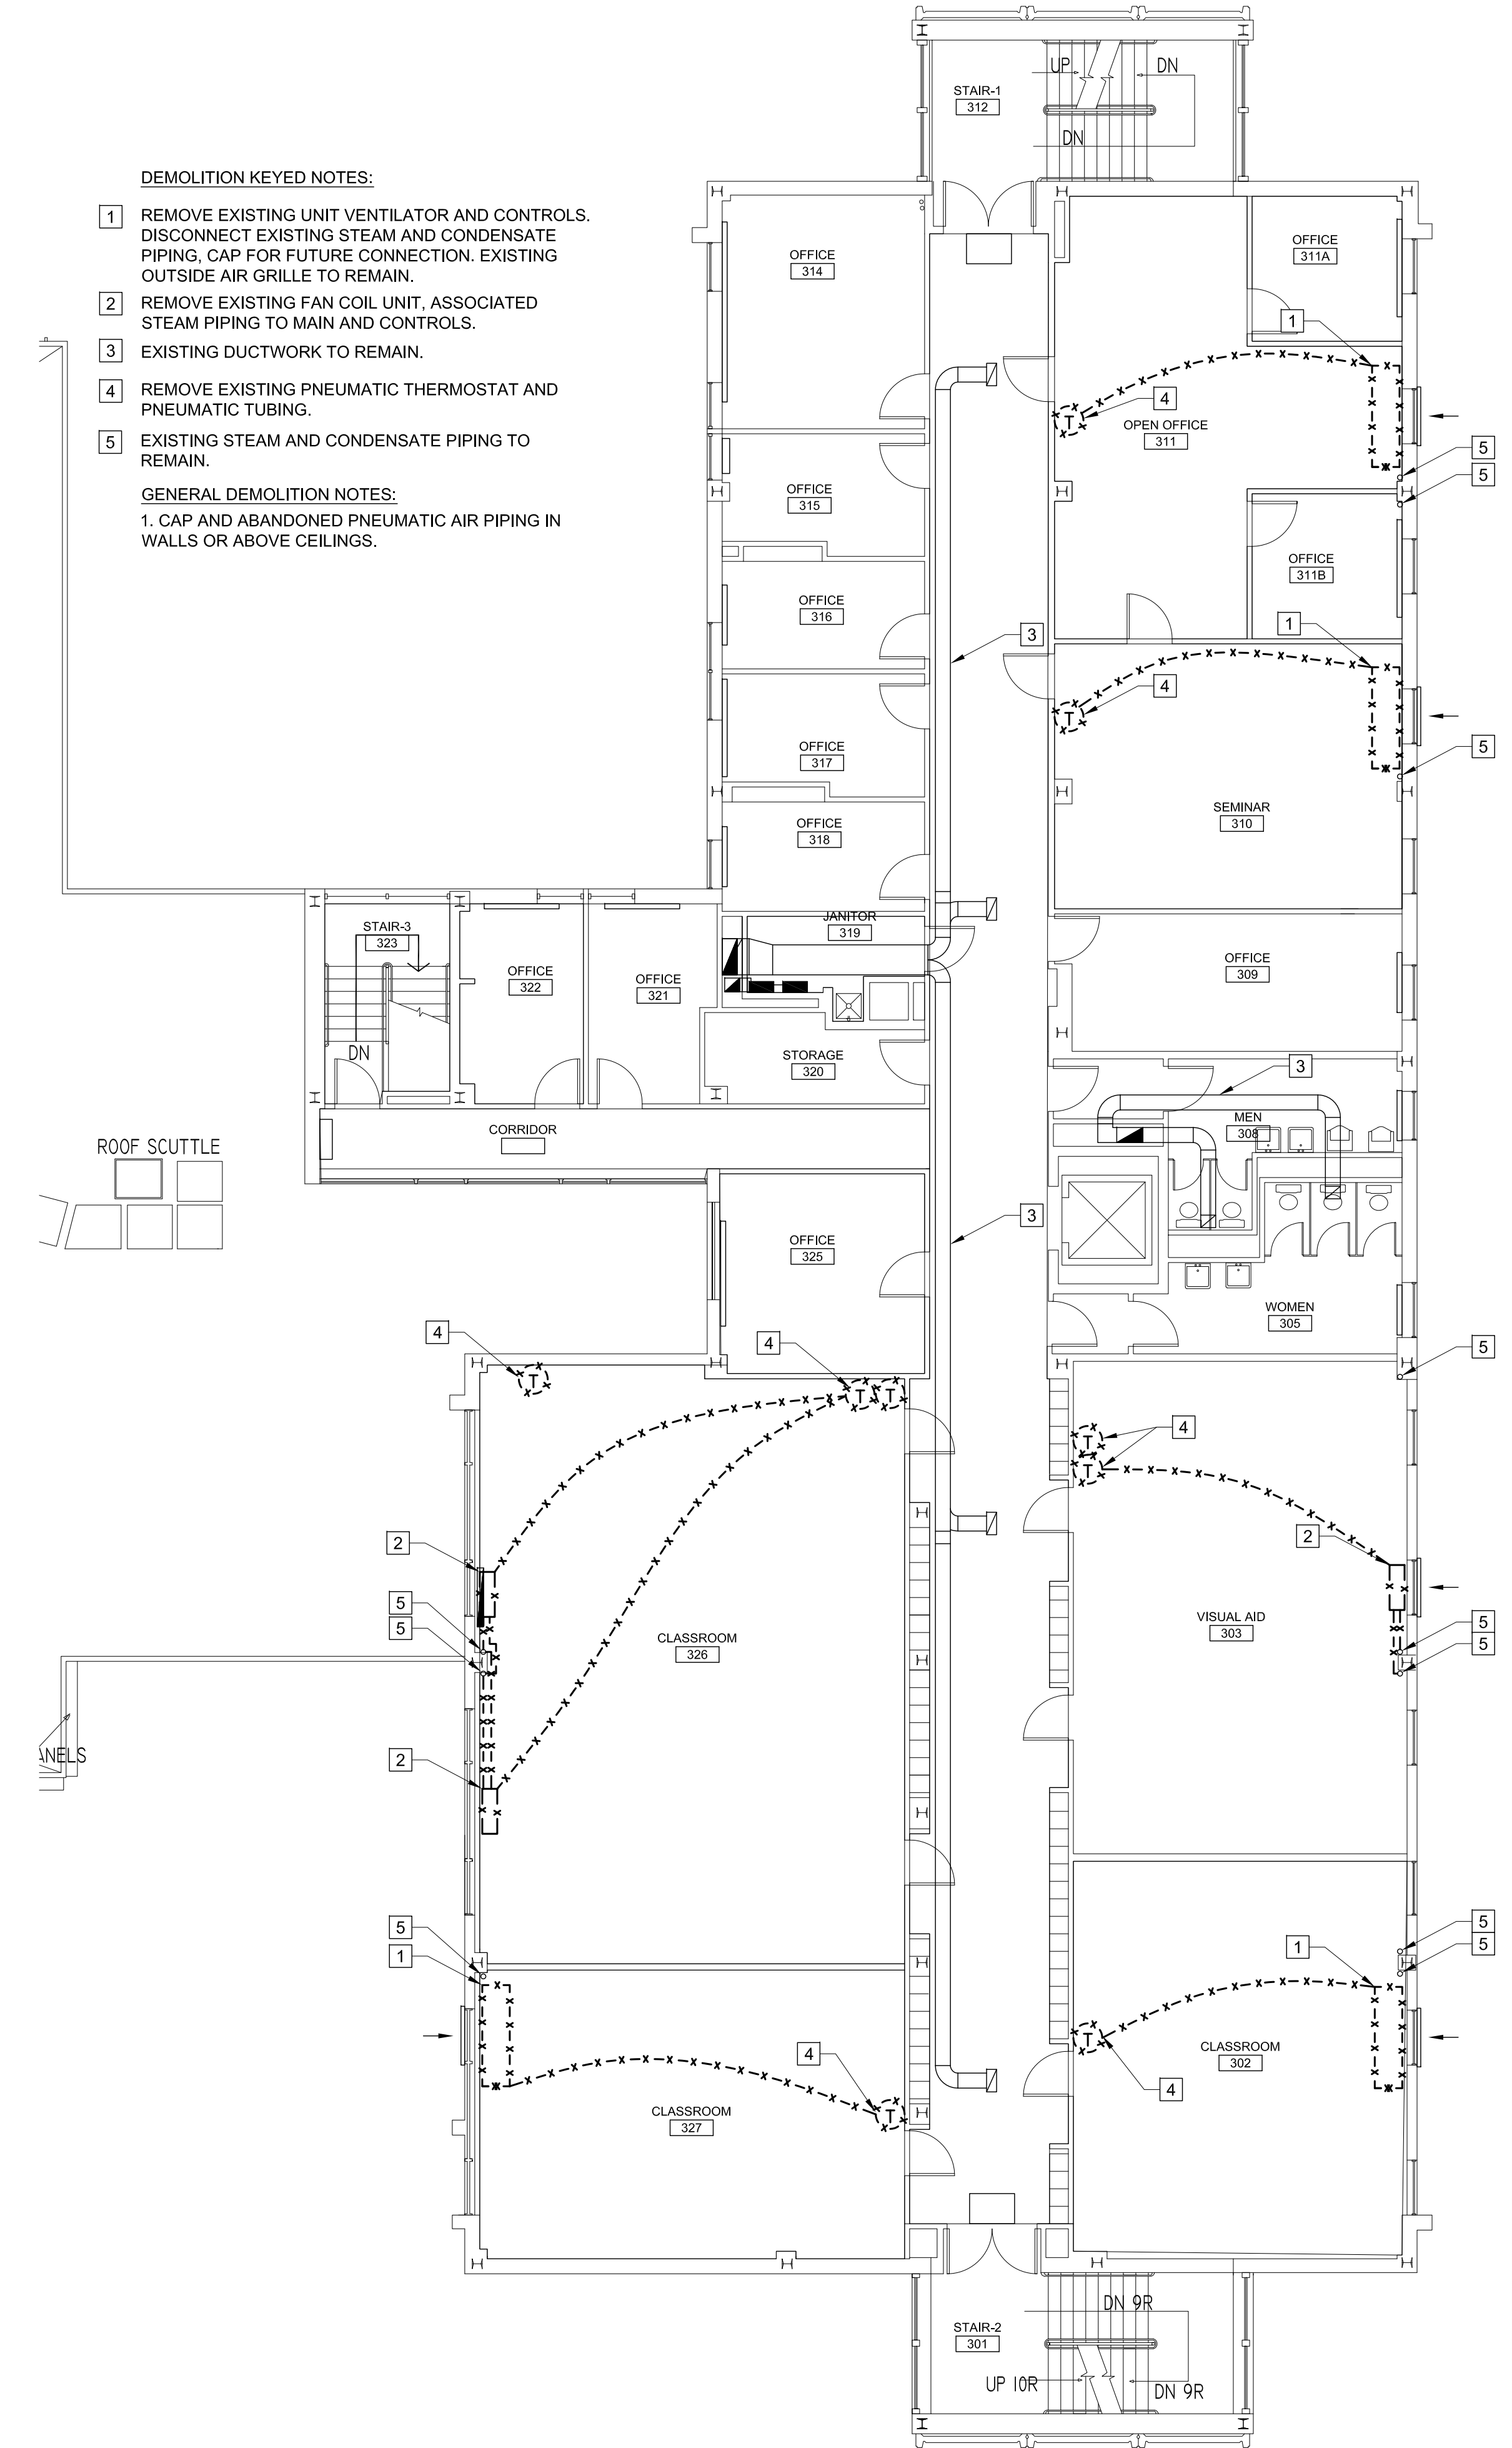


N:\Projects\2013\13102 ~ USM Luther Bonney Classroom Upgrade\00 Drawing Files\13102\_M.dwg Feb 14, 2014 - 10:32am

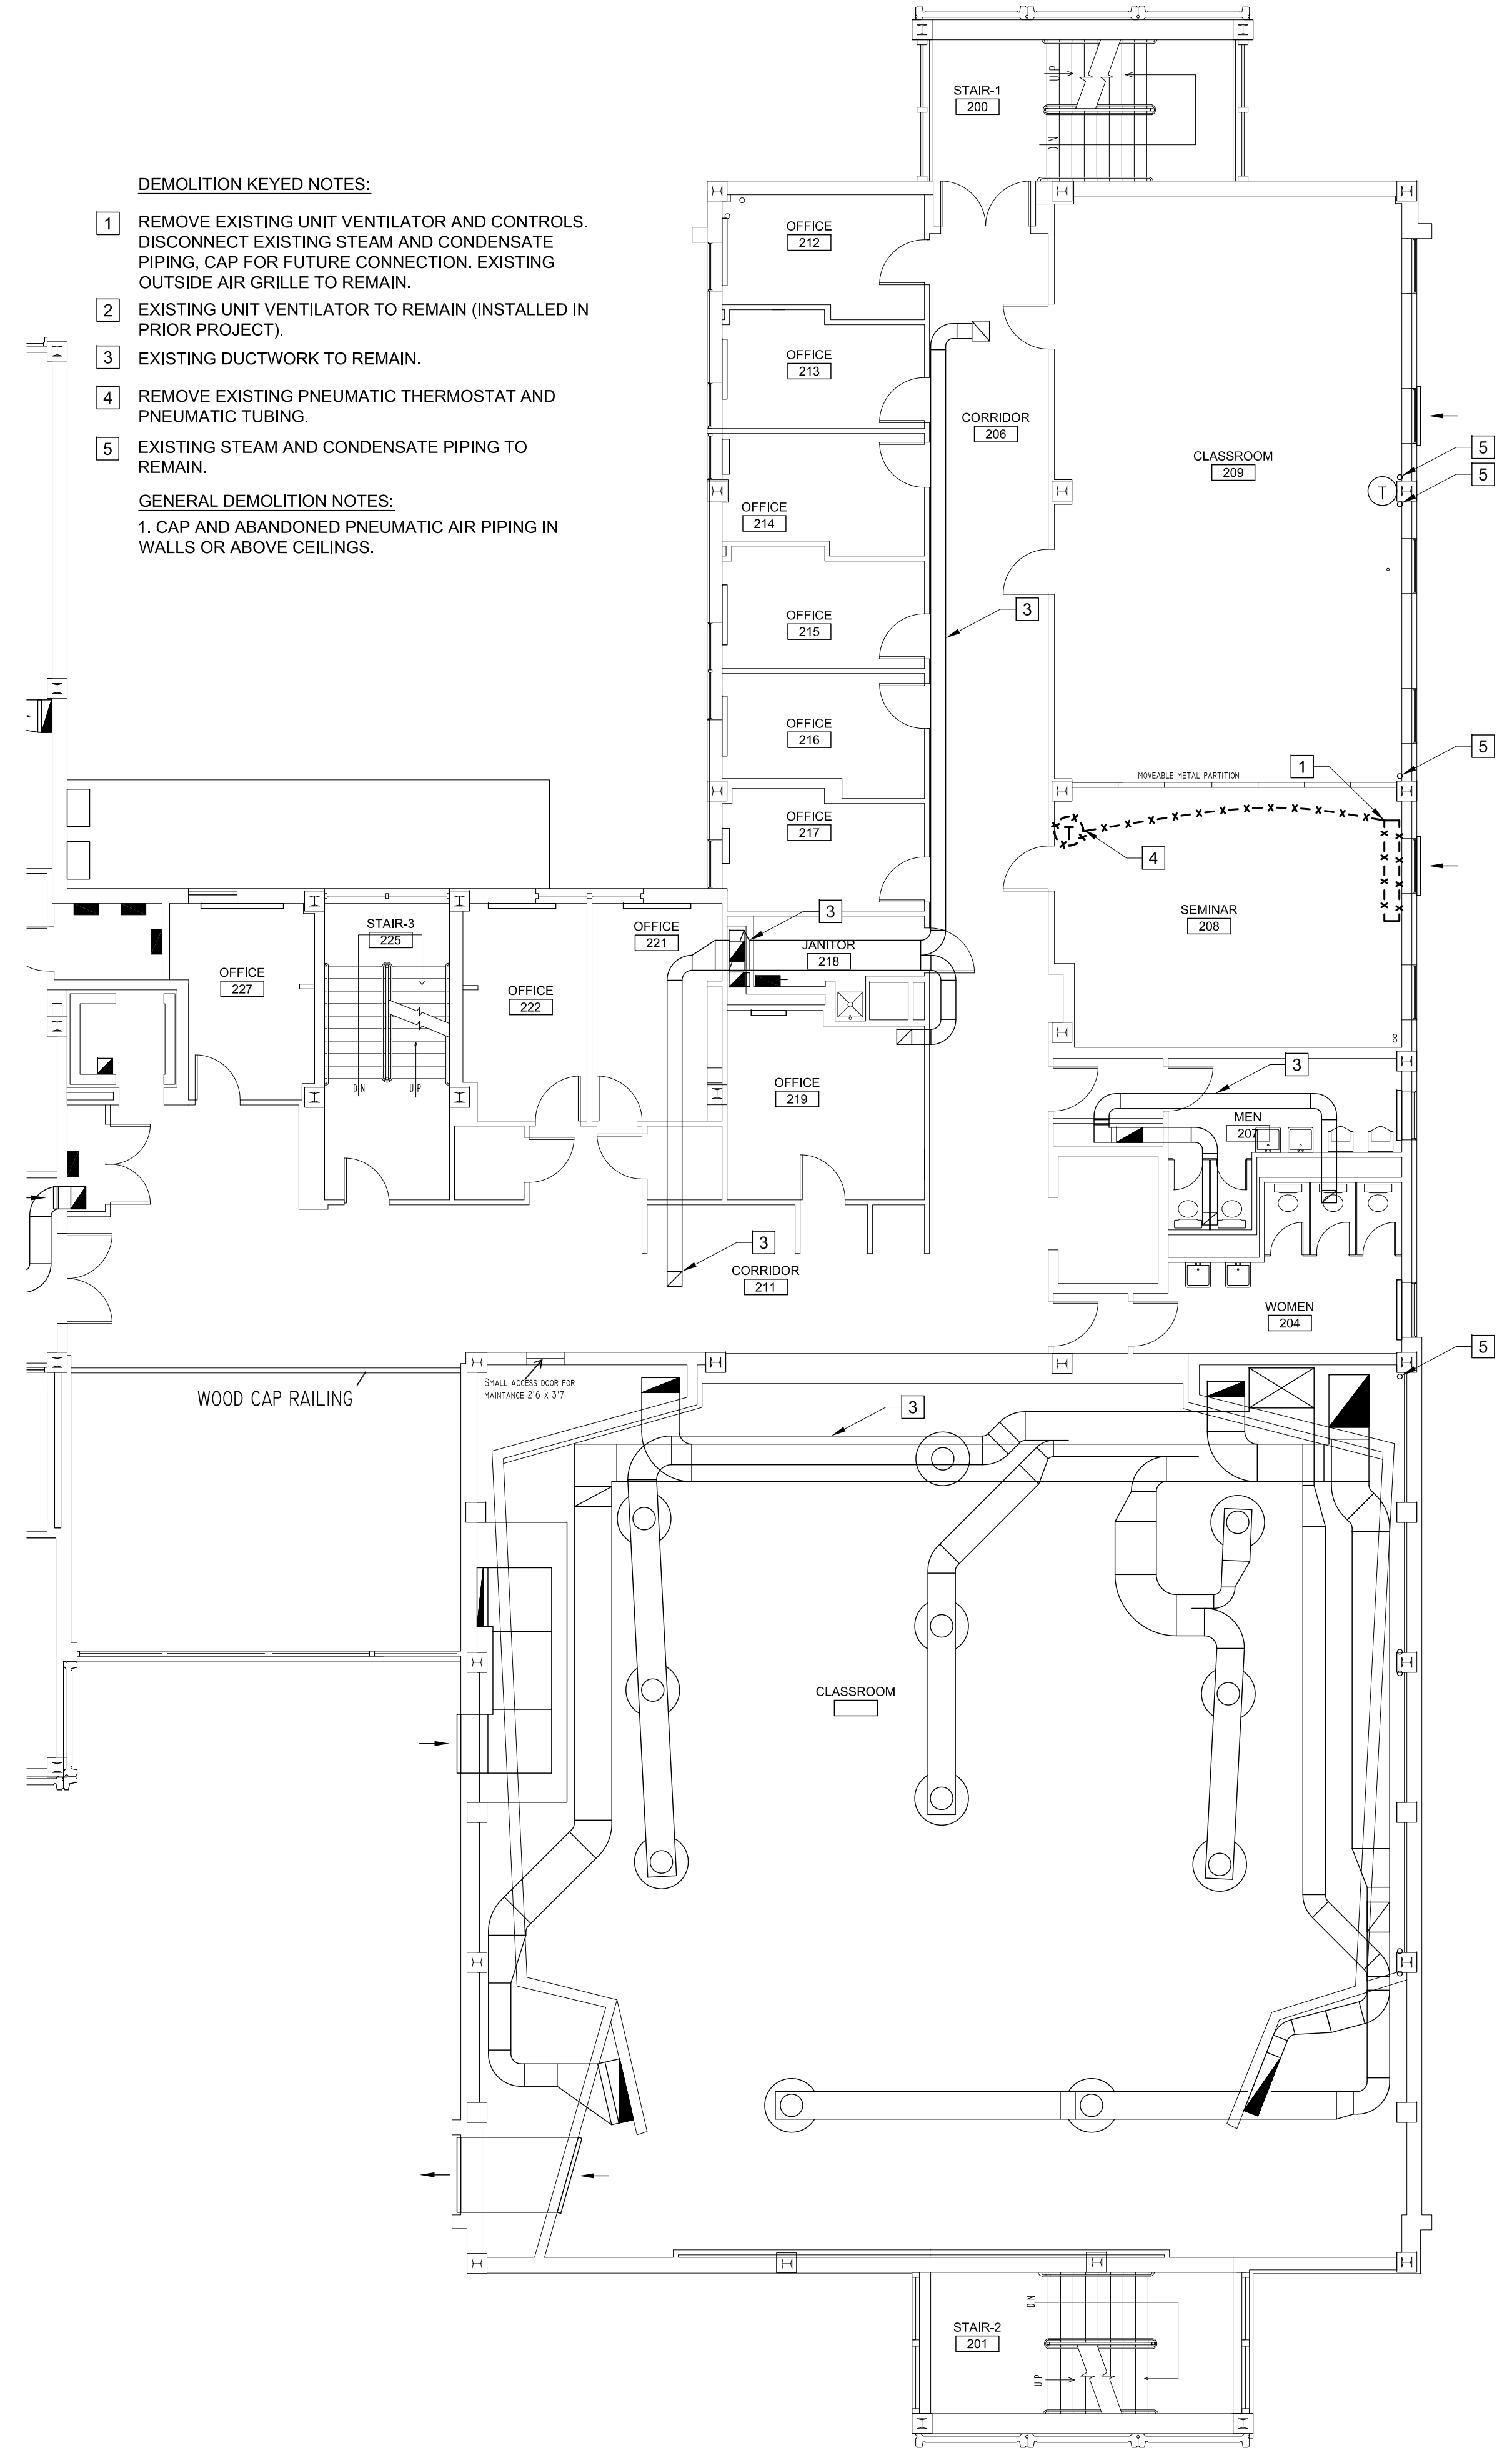

Design Firm

Consultant

**Allied Engineering**  
Structural Mechanical  
Electrical Commissioning

160 Veranda Street  
Portland, Maine 04103  
T: 207.221.2260  
F: 207.221.2266  
Web: www.allied-eng.com

Allied Project No. 13102

STATE OF MAINE  
IAN A. MACDONALD  
No. 6980  
LICENSED PROFESSIONAL ENGINEER

Project Title

**Luther Bonney Heating Upgrades**  
USM Luther Bonney Hall  
85 Bedford St.  
Portland Maine

Issue/Revision	Description	Date	Mark
Project ID	-		
CAD File	13102 M		
Drawn By	SCL		
Checked By	IAM		
Issue Date	2-14-2014		
Plot Date			
Reviewed By			
Designed By			
Submitted By			
Drawing Code			
Sheet Title	MECHANICAL DEMOLITION SECOND AND THIRD FLOOR PLANS		
Drawing No.	MD-100		

2 of 9