



N:\Projects\2013\13102 ~ USM Luther Bonney Classroom Upgrade\00 Drawing Files\13102_M.dwg Feb 14, 2014 -- 10:32am

- DEMOLITION KEYED NOTES (BASE):
- 1 REMOVE EXISTING UNIT VENTILATOR AND CONTROLS. DISCONNECT EXISTING STEAM AND CONDENSATE PIPING, CAP FOR FUTURE CONNECTION. EXISTING OUTSIDE AIR GRILLE TO REMAIN.
 - 2 EXISTING UNIT VENTILATOR TO REMAIN (INSTALLED IN PRIOR PROJECT).
 - 3 EXISTING DUCTWORK TO REMAIN.
 - 4 REMOVE EXISTING PNEUMATIC THERMOSTAT AND PNEUMATIC TUBING.
 - 5 EXISTING STEAM AND CONDENSATE PIPING TO REMAIN.
- GENERAL DEMOLITION NOTES:
 1. CAP AND ABANDONED PNEUMATIC AIR PIPING IN WALLS OR ABOVE CEILINGS.

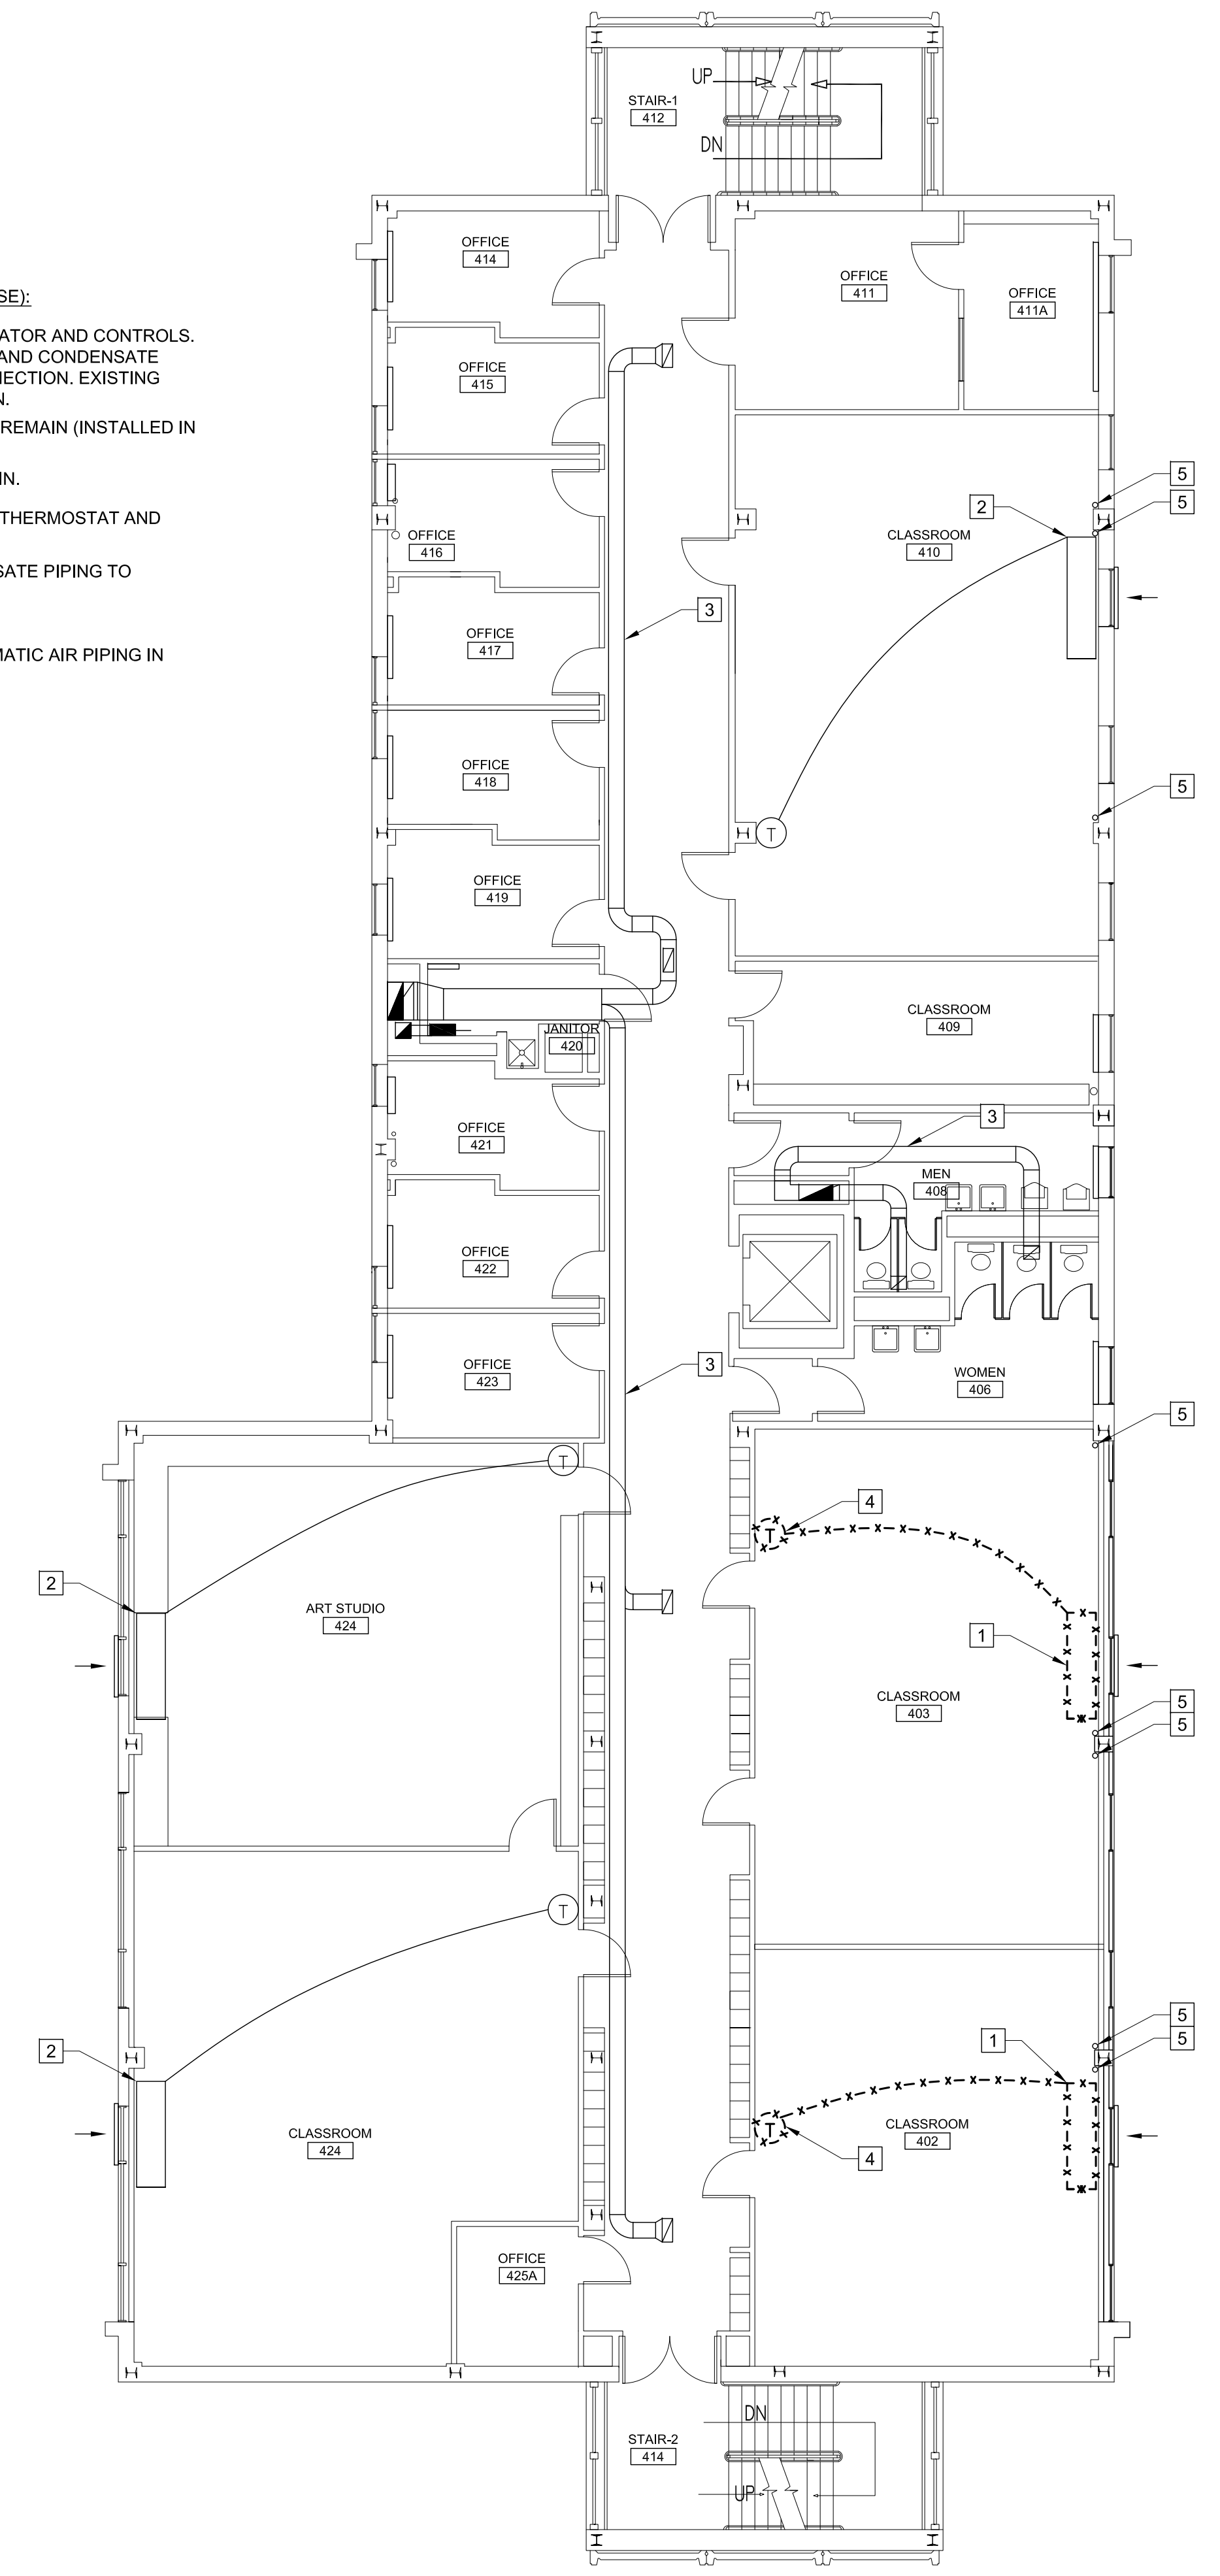


A1 MECHANICAL DEMOLITION FOURTH FLOOR PLAN
 1/8"=1'-0"

- DEMOLITION KEYED NOTES (BASE):
- 1 REMOVE EXISTING UNIT VENTILATOR AND CONTROLS. DISCONNECT EXISTING STEAM AND CONDENSATE PIPING, CAP FOR FUTURE CONNECTION. EXISTING OUTSIDE AIR GRILLE TO REMAIN.
 - 2 EXISTING UNIT VENTILATOR TO REMAIN (INSTALLED IN PRIOR PROJECT).
 - 3 EXISTING DUCTWORK TO REMAIN.
 - 4 REMOVE EXISTING PNEUMATIC THERMOSTAT AND PNEUMATIC TUBING.
 - 5 EXISTING STEAM AND CONDENSATE PIPING TO REMAIN.
- GENERAL DEMOLITION NOTES:
 1. CAP AND ABANDONED PNEUMATIC AIR PIPING IN WALLS OR ABOVE CEILINGS.

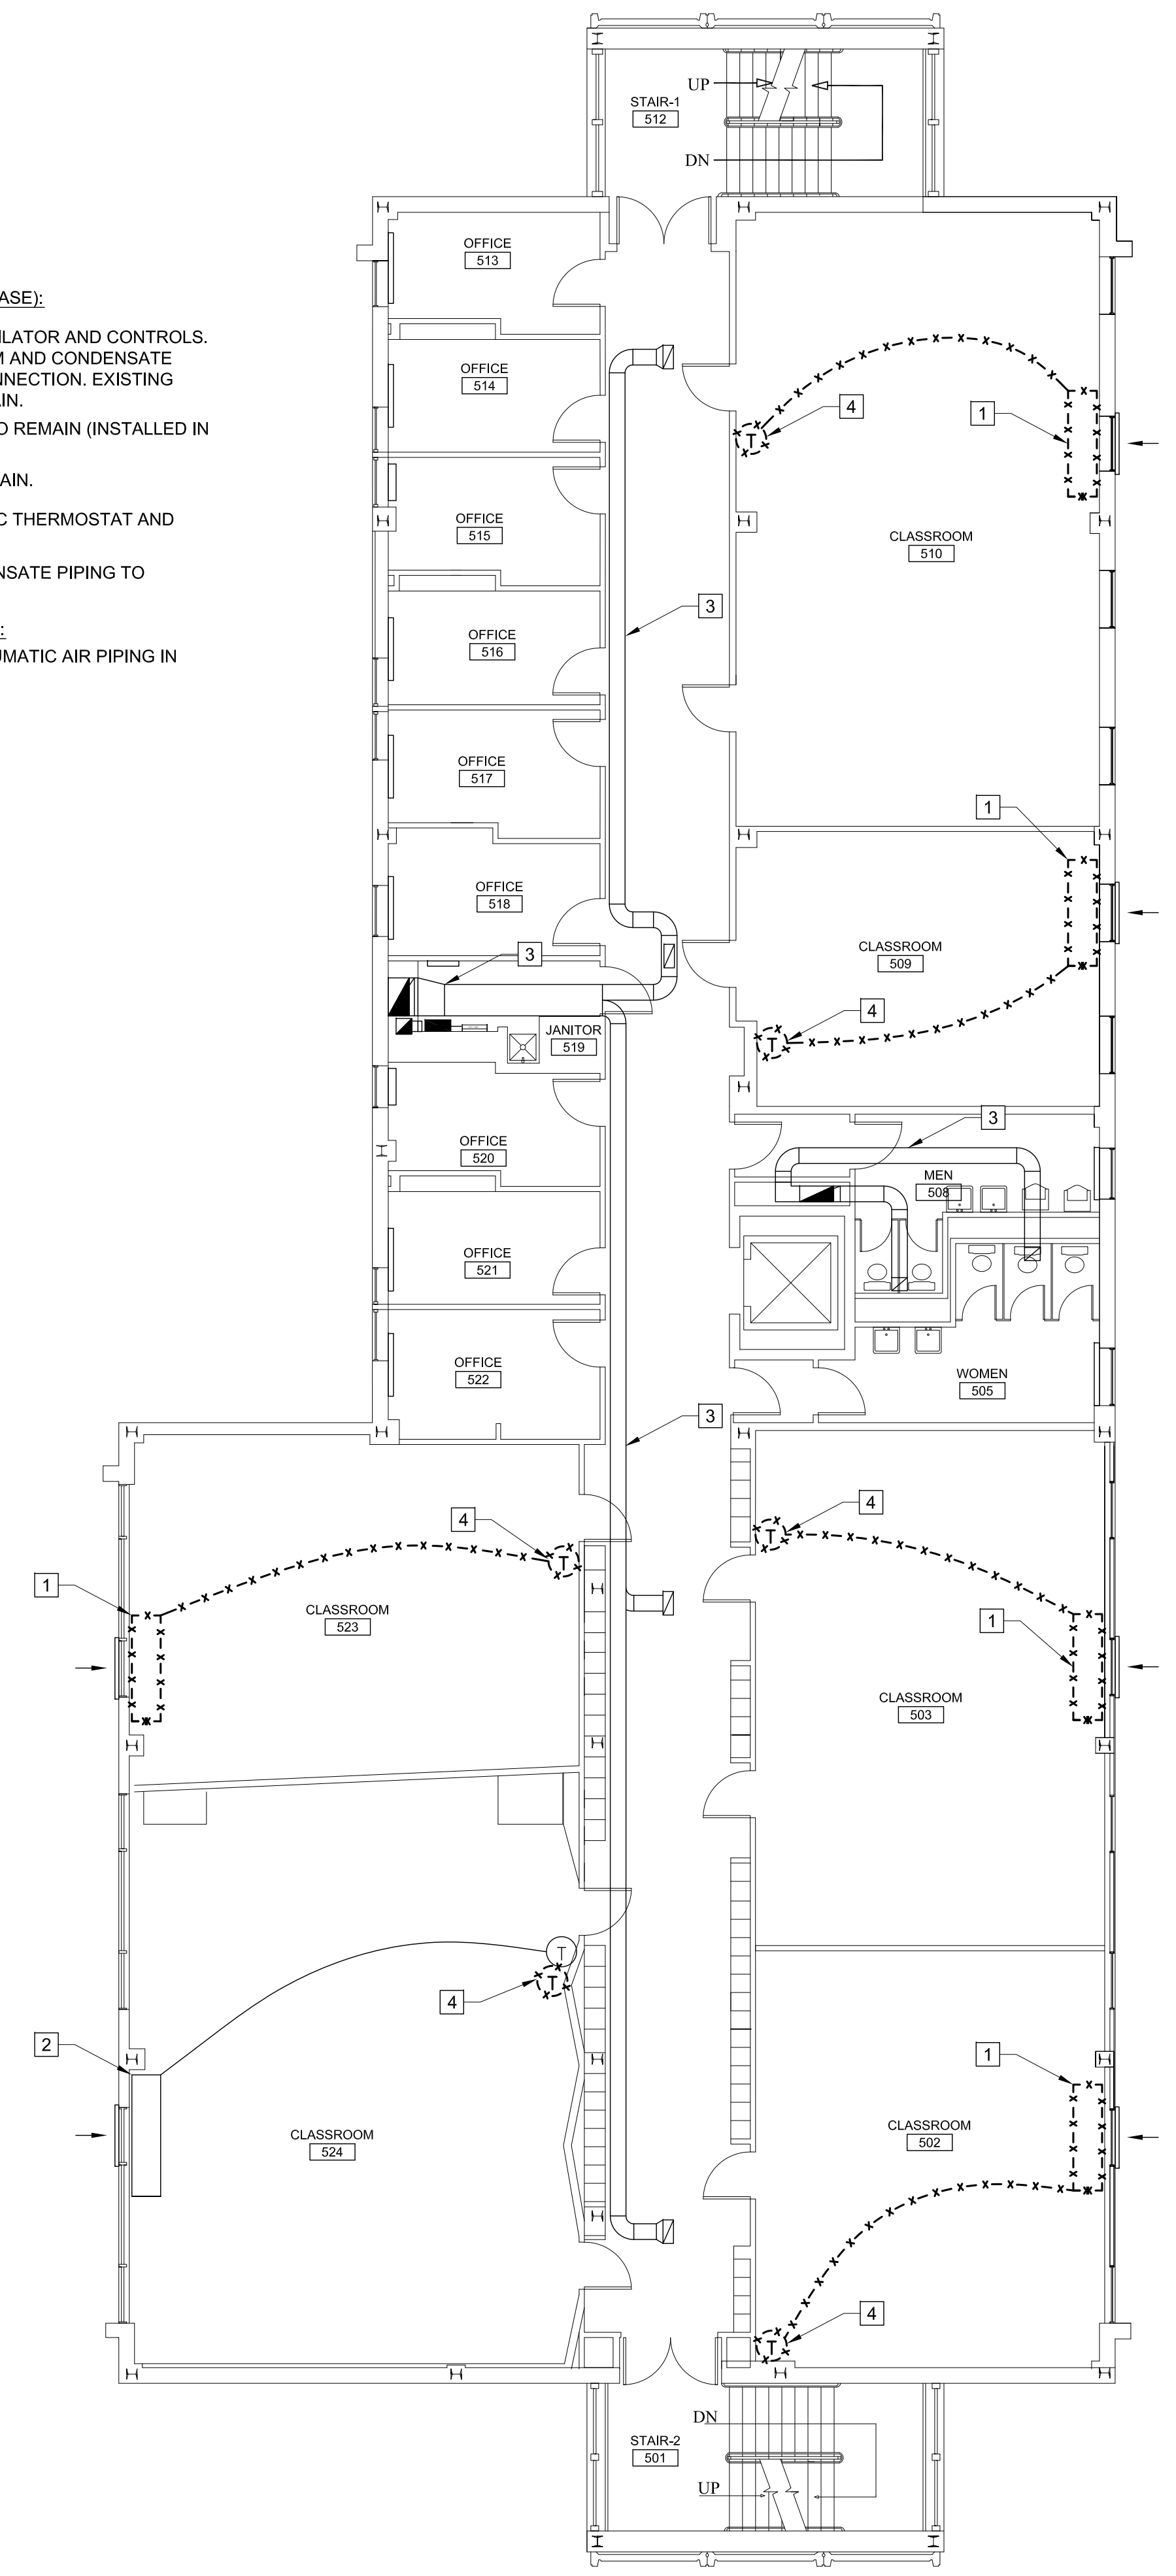

A3 MECHANICAL DEMOLITION FIFTH FLOOR PLAN
 1/8"=1'-0"

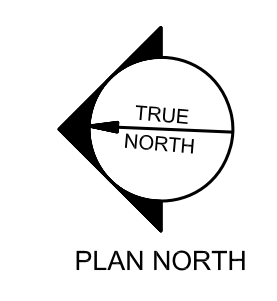

Design Firm

Consultant

Allied Engineering
 Structural Mechanical Electrical Commissioning

160 Veranda Street
 Portland, Maine 04103
 T: 207.221.2260
 F: 207.221.2266
 Web: www.allied-eng.com

Allied Project No. 13102

STATE OF MAINE
 IAN A. MACDONALD
 No. 6990
 LICENSED PROFESSIONAL ENGINEER

Project Title

Luther Bonney Heating Upgrades
 USM Luther Bonney Hall
 85 Bedford St.
 Portland Maine

Issue/Revision	Description
Project ID	-
CAD File	13102_M
Drawn By	SCL
Checked By	IAM
Issue Date	2-14-2014
Plot Date	
Reviewed By	
Designed By	
Submitted By	
Drawing Code	
Sheet Title	MECHANICAL DEMOLITION FOURTH AND FIFTH FLOOR PLANS
Drawing No.	MD-101

3 of 9