
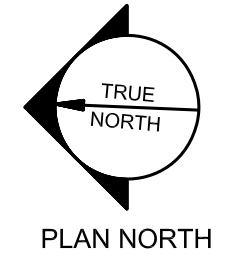
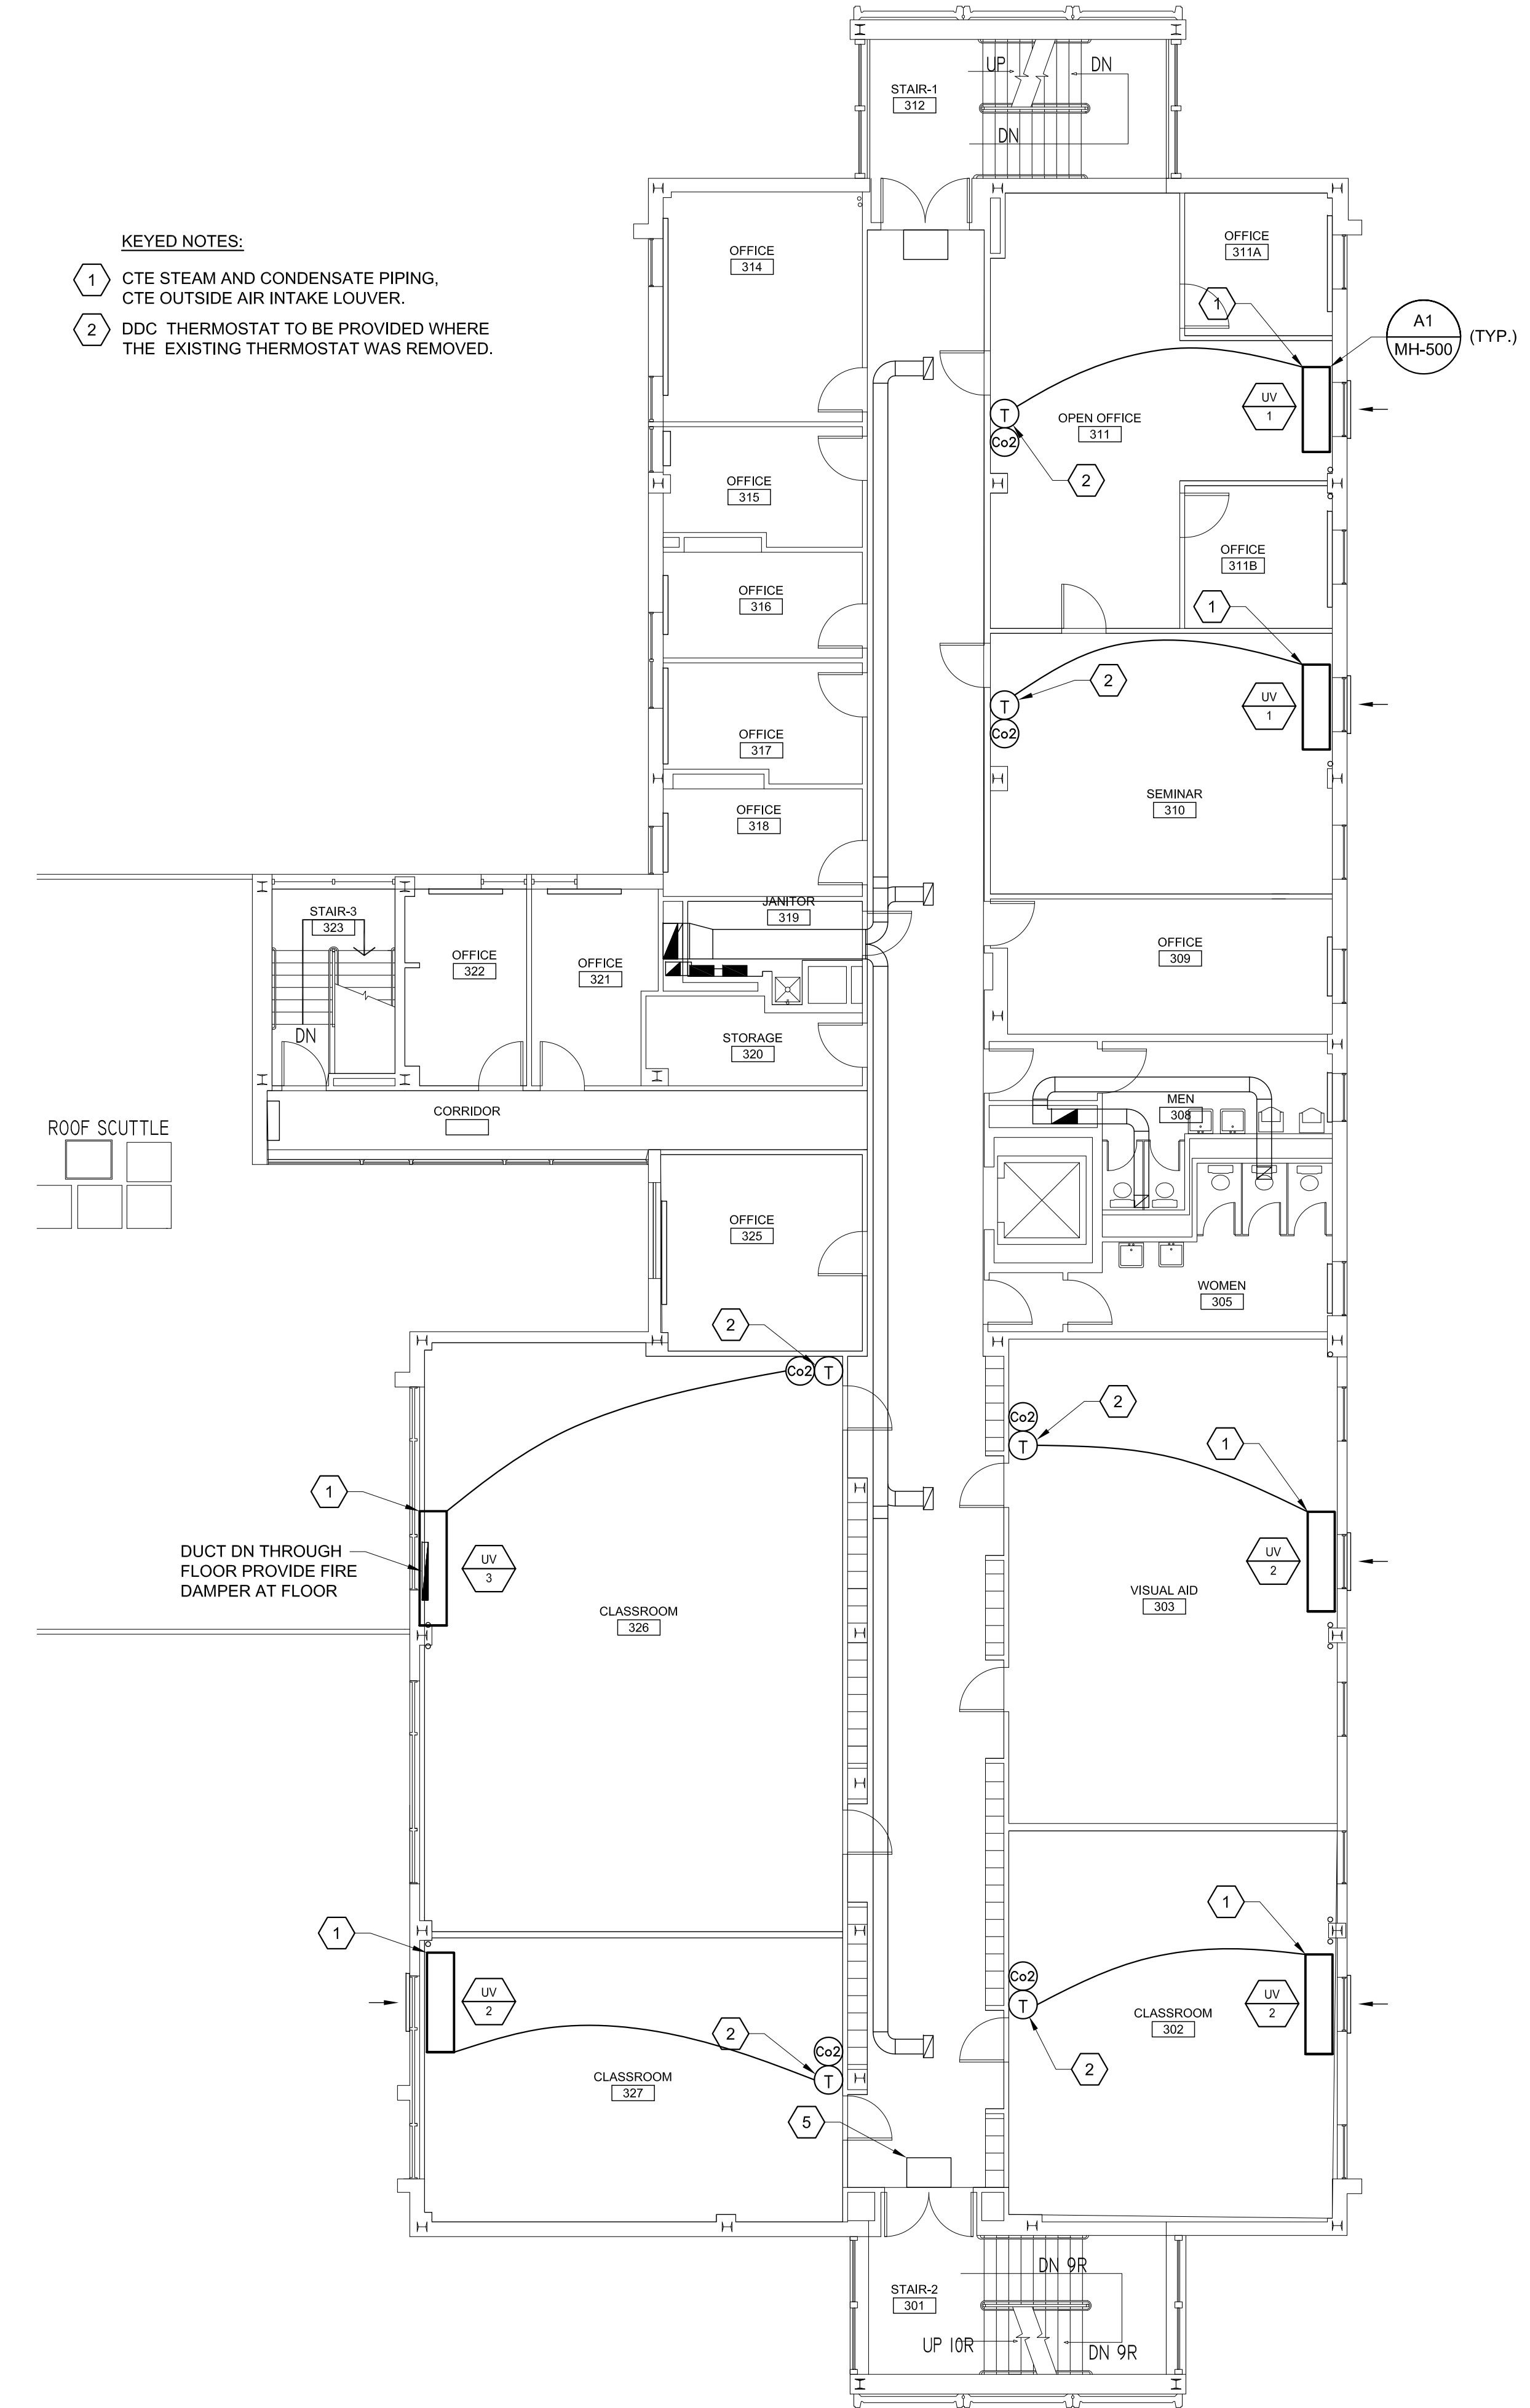


N:\Projects\2013\13102 ~ USM Luther Bonney Classroom Upgrade\00 Drawing Files\13102\_M.dwg Feb 14, 2014 - 10:18am

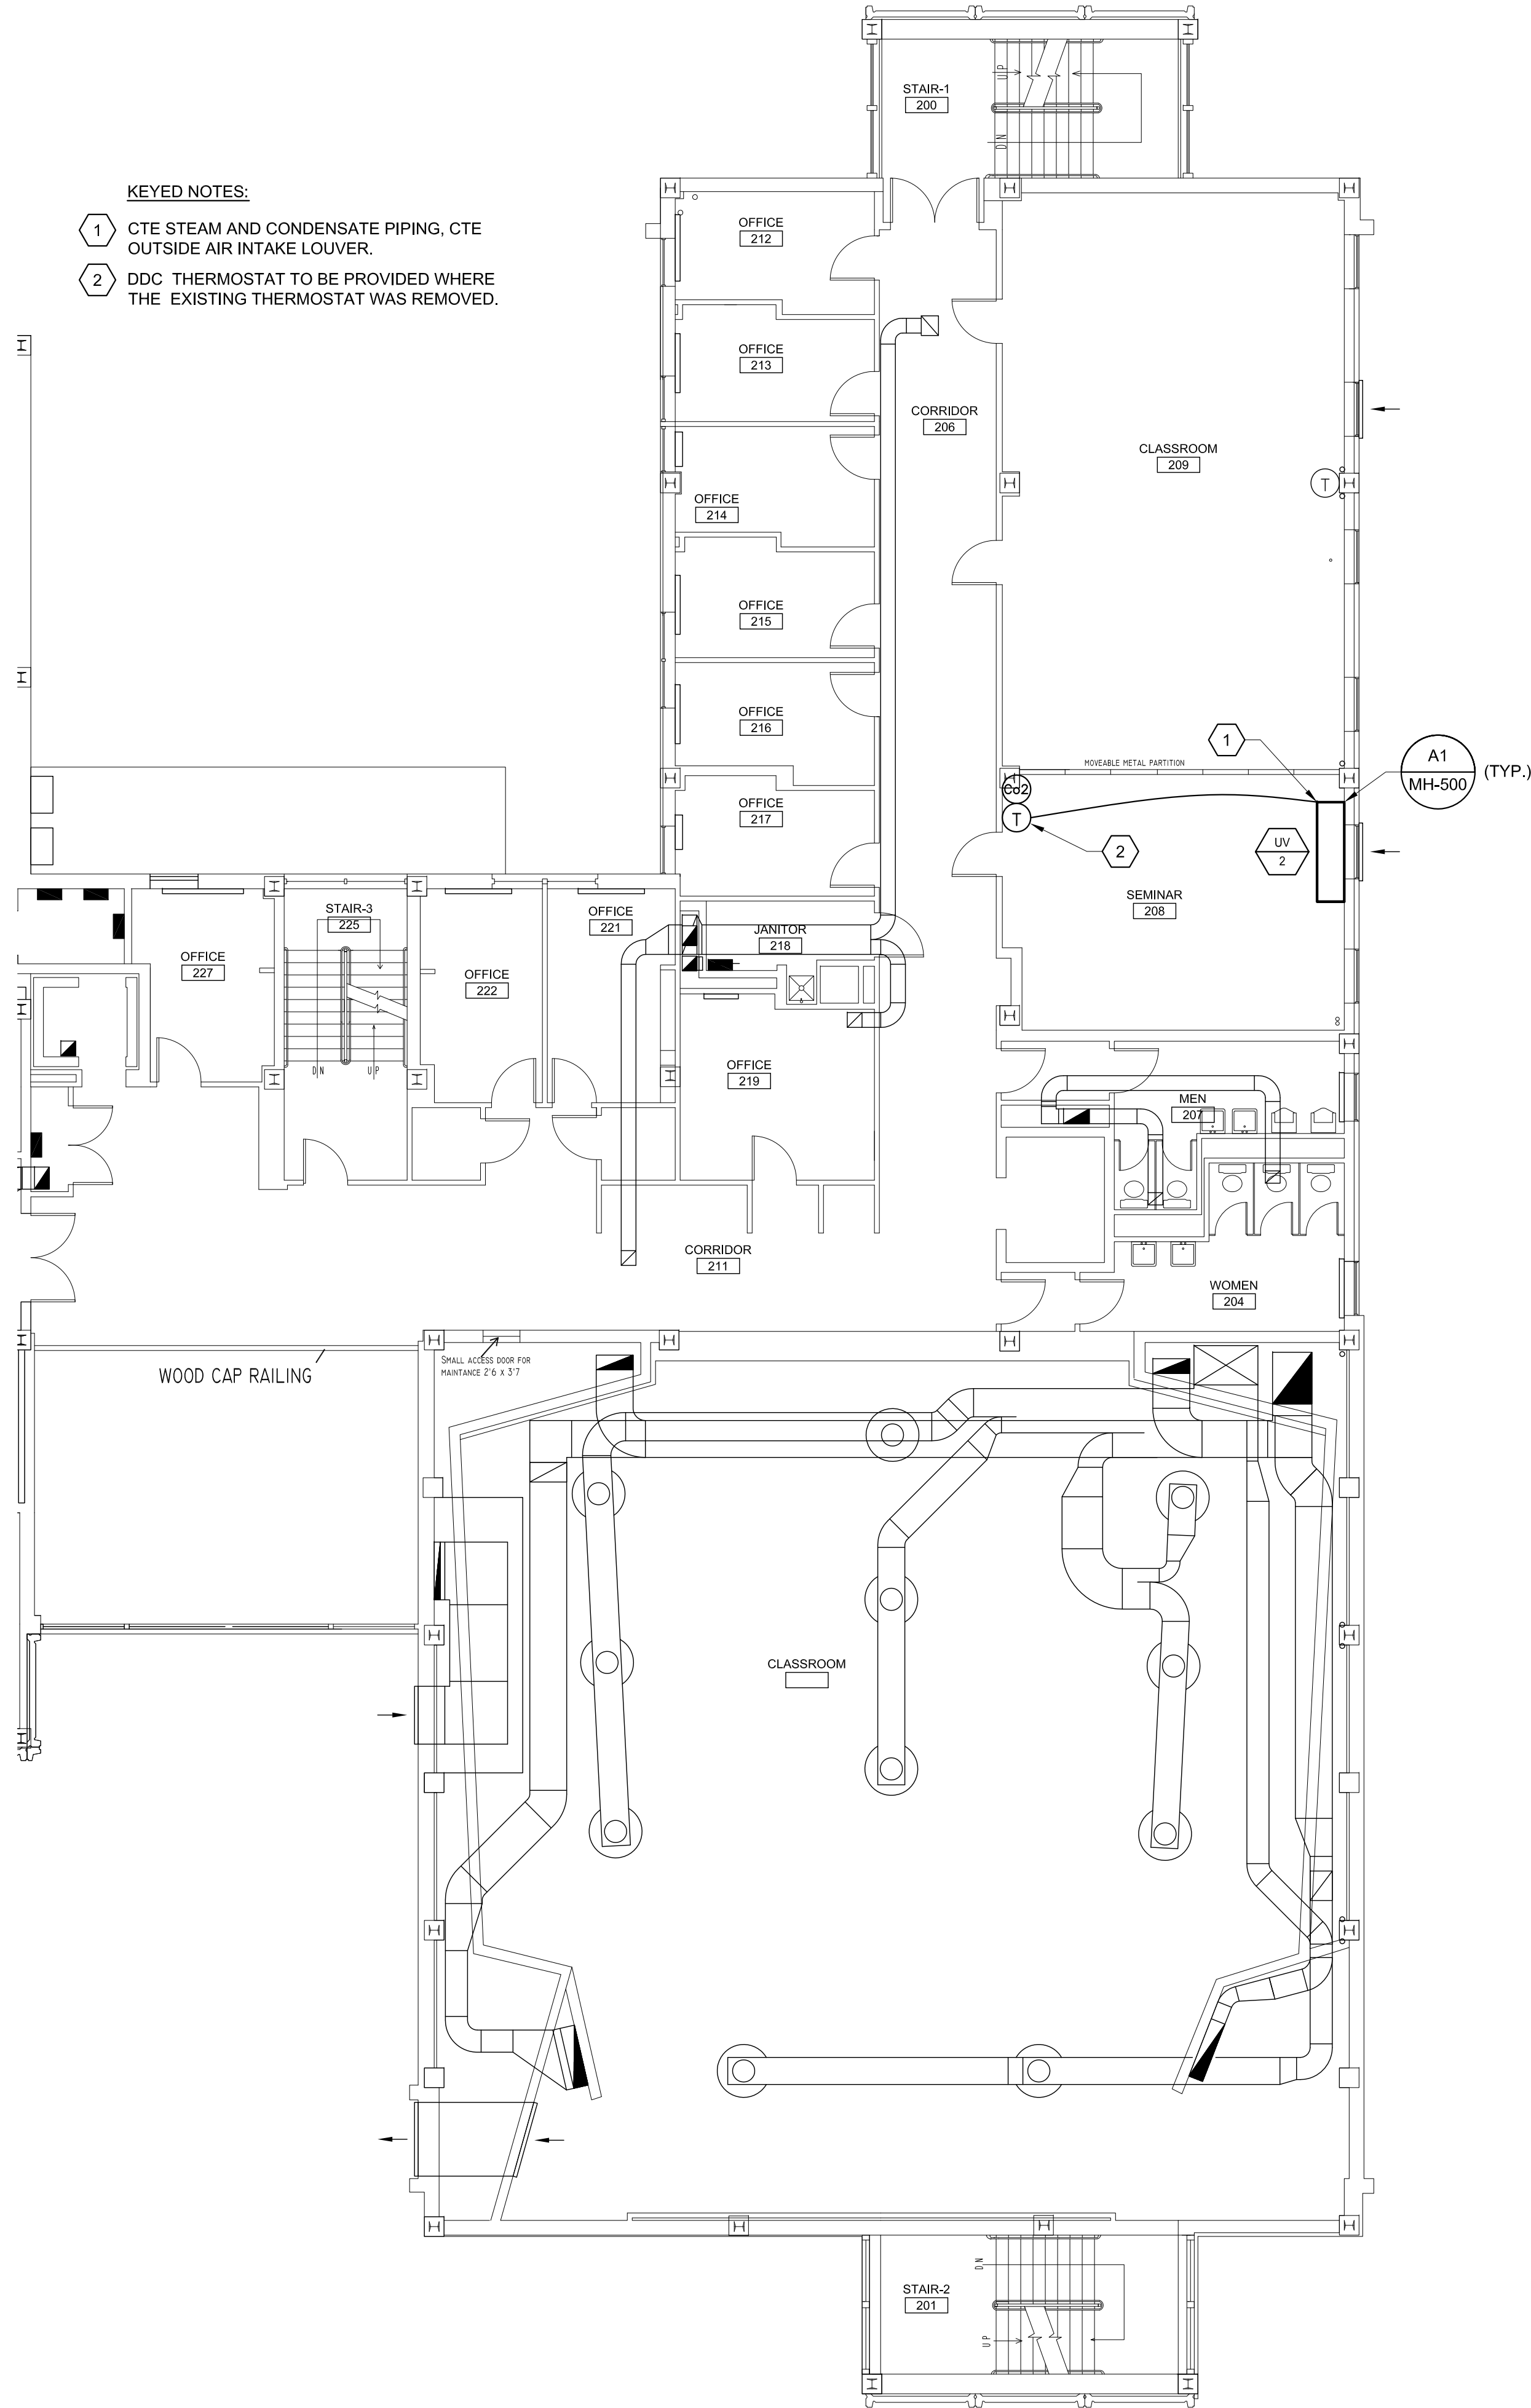

Design Firm

Consultant

**Allied Engineering**  
Structural Mechanical  
Electrical Commissioning

160 Veranda Street  
Portland, Maine 04103  
T: 207.221.2260  
F: 207.221.2266  
Web: www.allied-eng.com

Allied Project No. 13102

STATE OF MAINE  
IAN A. MACDONALD  
No. 6990  
LICENSED PROFESSIONAL ENGINEER

Project Title

**Luther Bonney Heating Upgrades**  
USM Luther Bonney Hall  
85 Bedford St.  
Portland Maine

Issue/Revision	Description
Project ID	13102_M
CAD File	13102_M
Drawn By	SCL
Checked By	IAM
Issue Date	2-14-2014
Plot Date	
Reviewed By	
Designed By	
Submitted By	
Drawing Code	
Sheet Title	MECHANICAL SECOND AND THIRD FLOOR PLANS
Drawing No.	MH-100

4 of 9