



N:\Projects\2013\13102 ~ USM Luther Bonney Classroom Upgrade\00 Drawing Files\13102_M.dwg Feb 14, 2014 -- 10:18am

- KEYED NOTES:**
- 1 CTE STEAM AND CONDENSATE PIPING, CTE OUTSIDE AIR INTAKE LOUVER.
 - 2 DDC THERMOSTAT TO BE PROVIDED WHERE THE EXISTING THERMOSTAT WAS REMOVED.

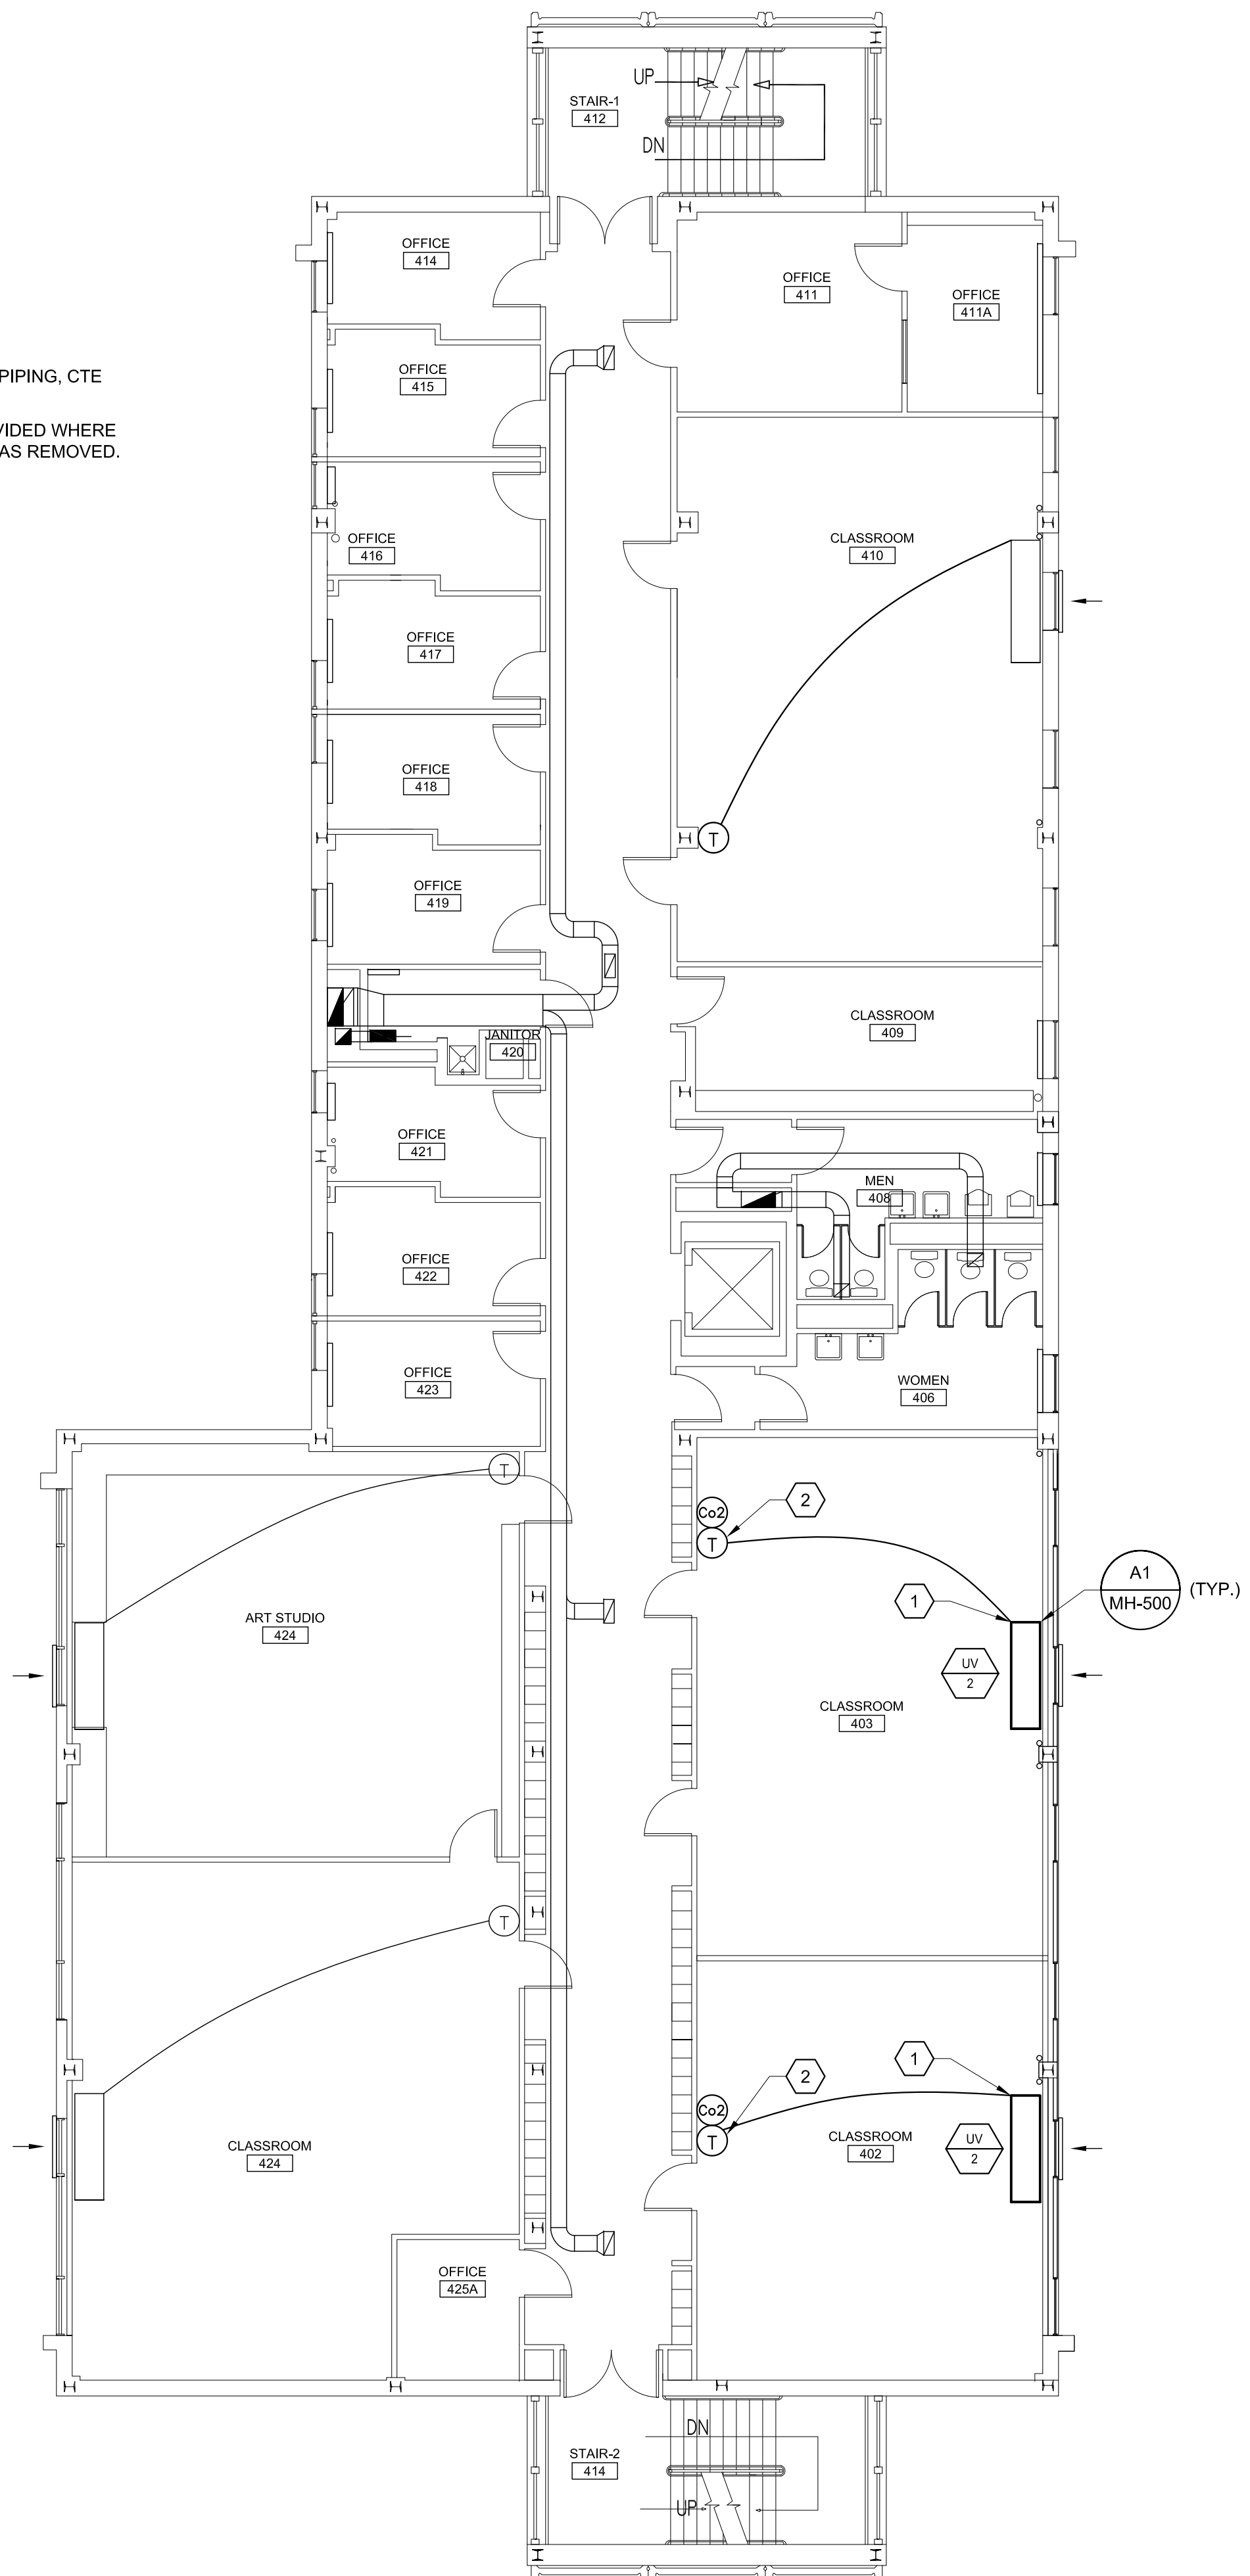

A1 MECHANICAL FOURTH FLOOR PLAN
1/8"=1'-0"

- KEYED NOTES:**
- 1 CTE STEAM AND CONDENSATE PIPING, CTE OUTSIDE AIR INTAKE LOUVER.
 - 2 DDC THERMOSTAT TO BE PROVIDED WHERE THE EXISTING THERMOSTAT WAS REMOVED.

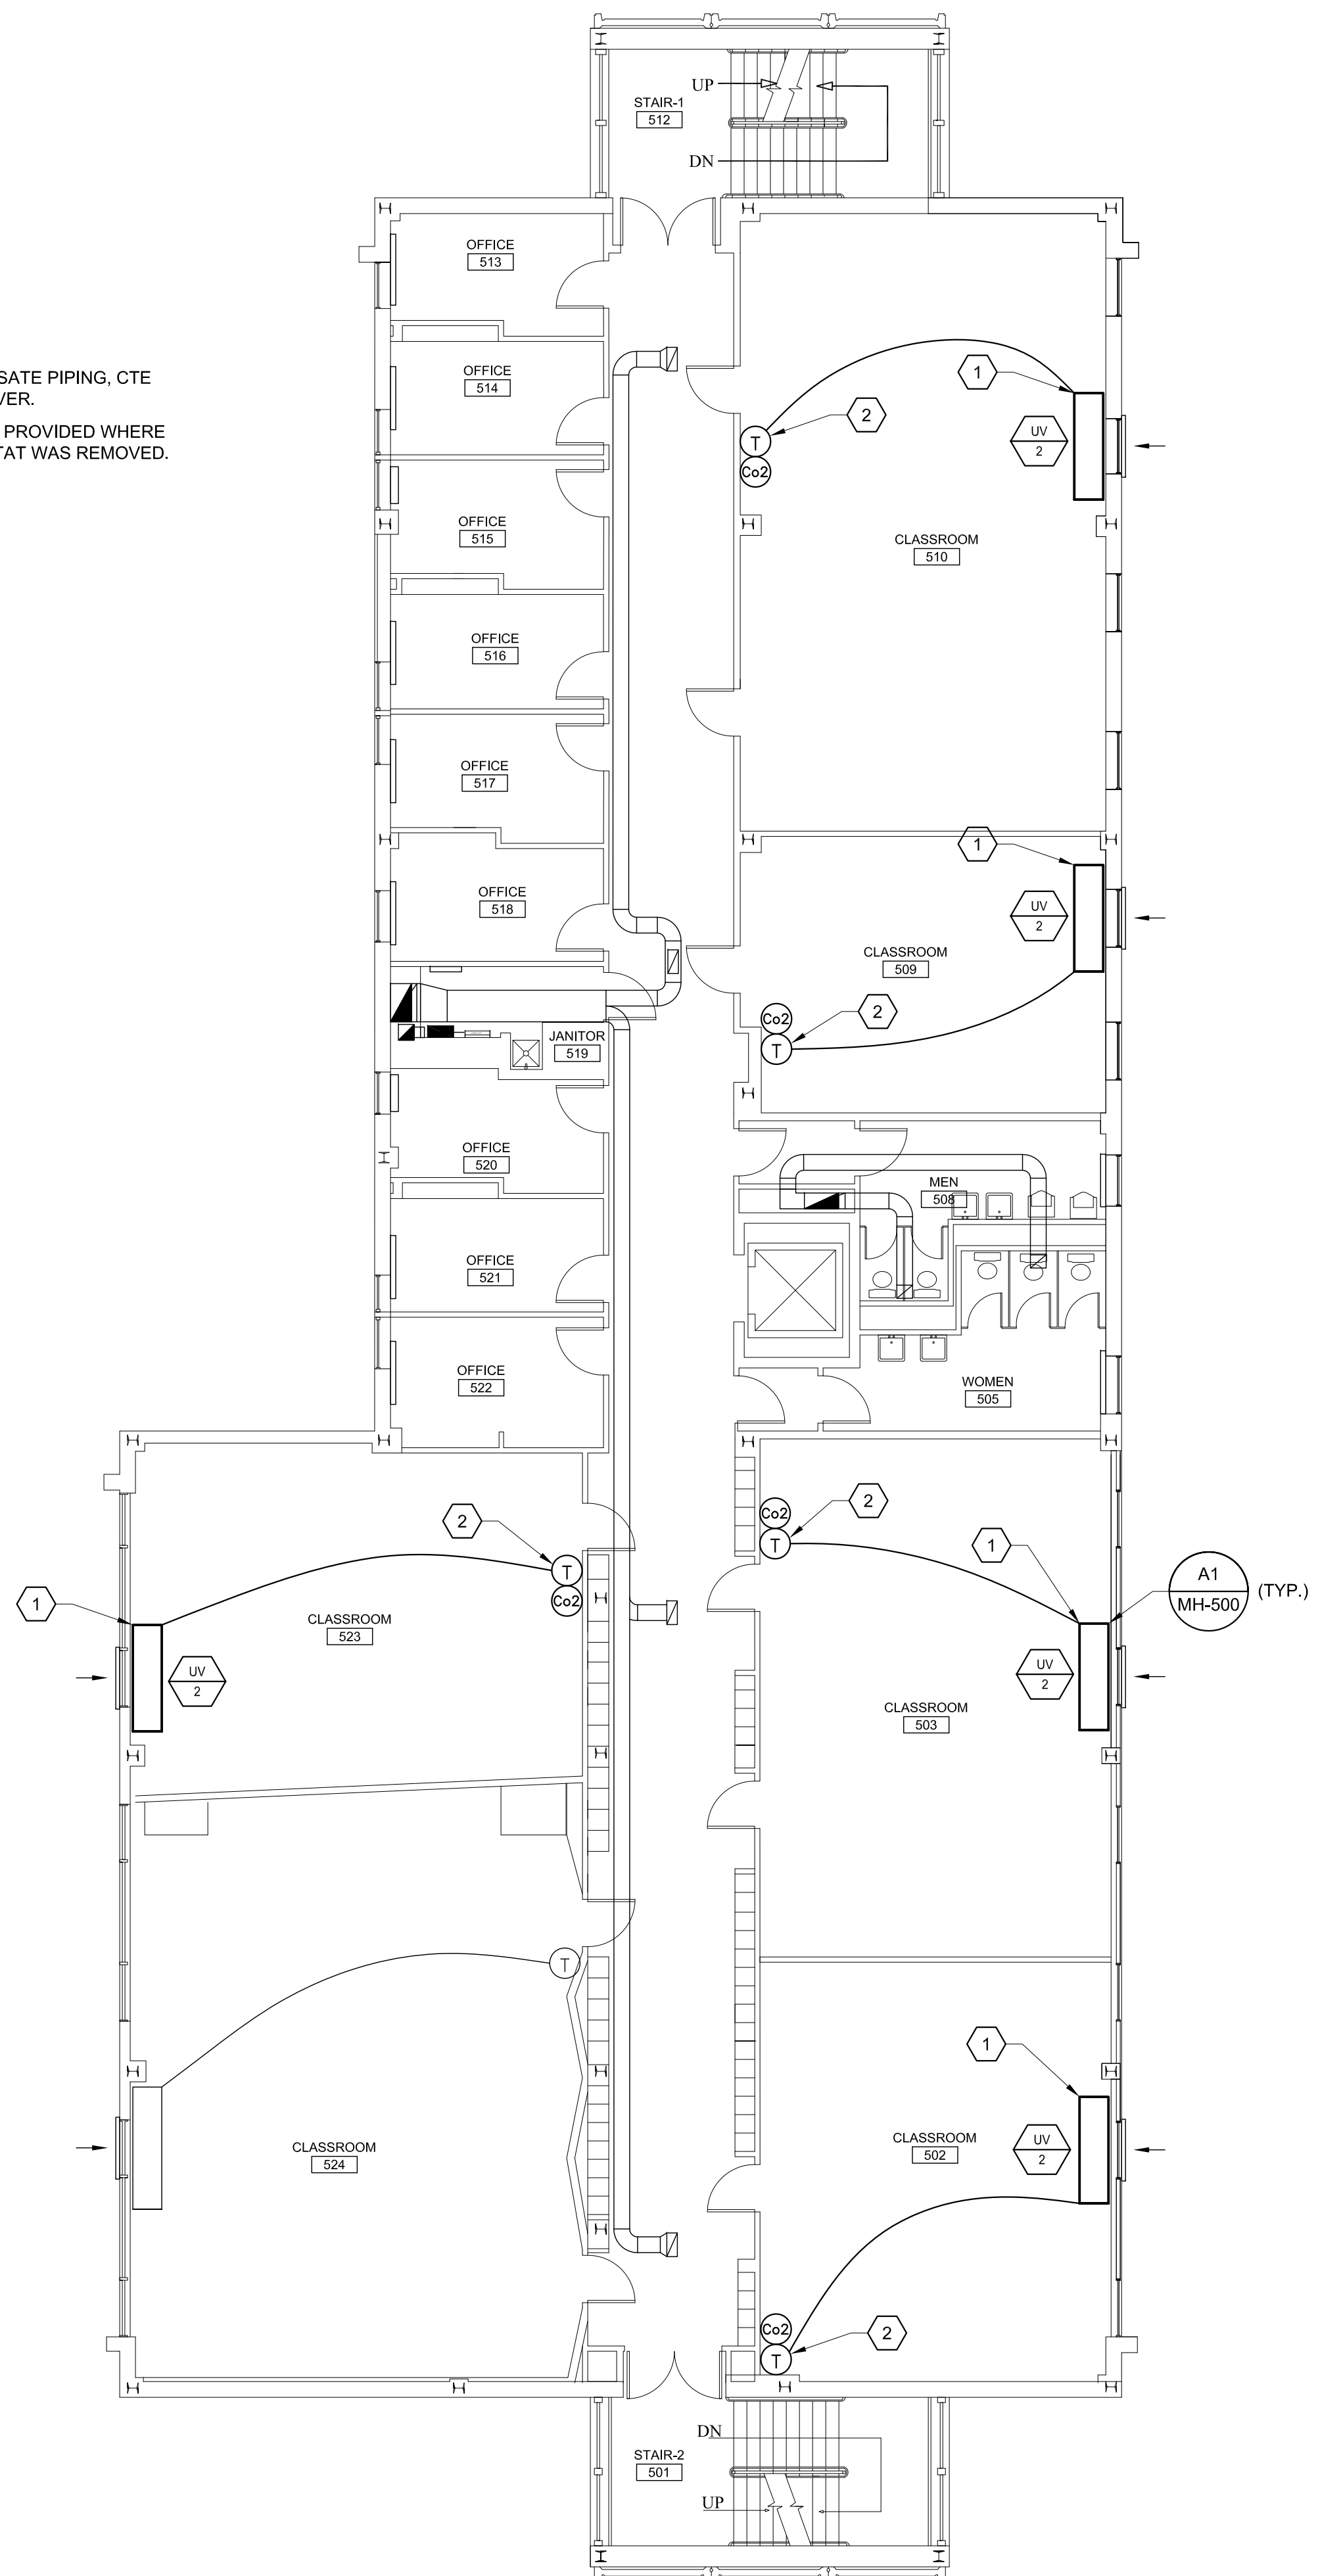

A3 MECHANICAL FIFTH FLOOR PLAN
1/8"=1'-0"

Design Firm

Consultant

Allied Engineering
Structural Mechanical
Electrical Commissioning

160 Veranda Street
Portland, Maine 04103
T: 207.221.2260
F: 207.221.2266
Web: www.allied-eng.com

Allied Project No. 13102



Project Title

Luther Bonney Heating Upgrades
USM Luther Bonney Hall
85 Bedford St.
Portland Maine

| Mark | Date | Description |
|------|------|-------------|
| | | |
| | | |

| Issue/Revision | |
|----------------|-----------|
| Project ID | - |
| CAD File | 13102_M |
| Drawn By | SCL |
| Checked By | IAM |
| Issue Date | 2-14-2014 |
| Plot Date | |
| Reviewed By | |
| Designed By | |
| Submitted By | |
| Drawing Code | |

Sheet Title
MECHANICAL FOURTH AND FIFTH FLOOR PLANS

Drawing No.

MH-101
5 of 9

