



HARRIMAN



AUBURN PORTLAND MANCHESTER

UNIVERSITY OF SOUTHERN MAINE CENTRAL HEAT PLANT UPGRADES

PORTLAND, ME


Harriman Project No. 14411

Key Plan

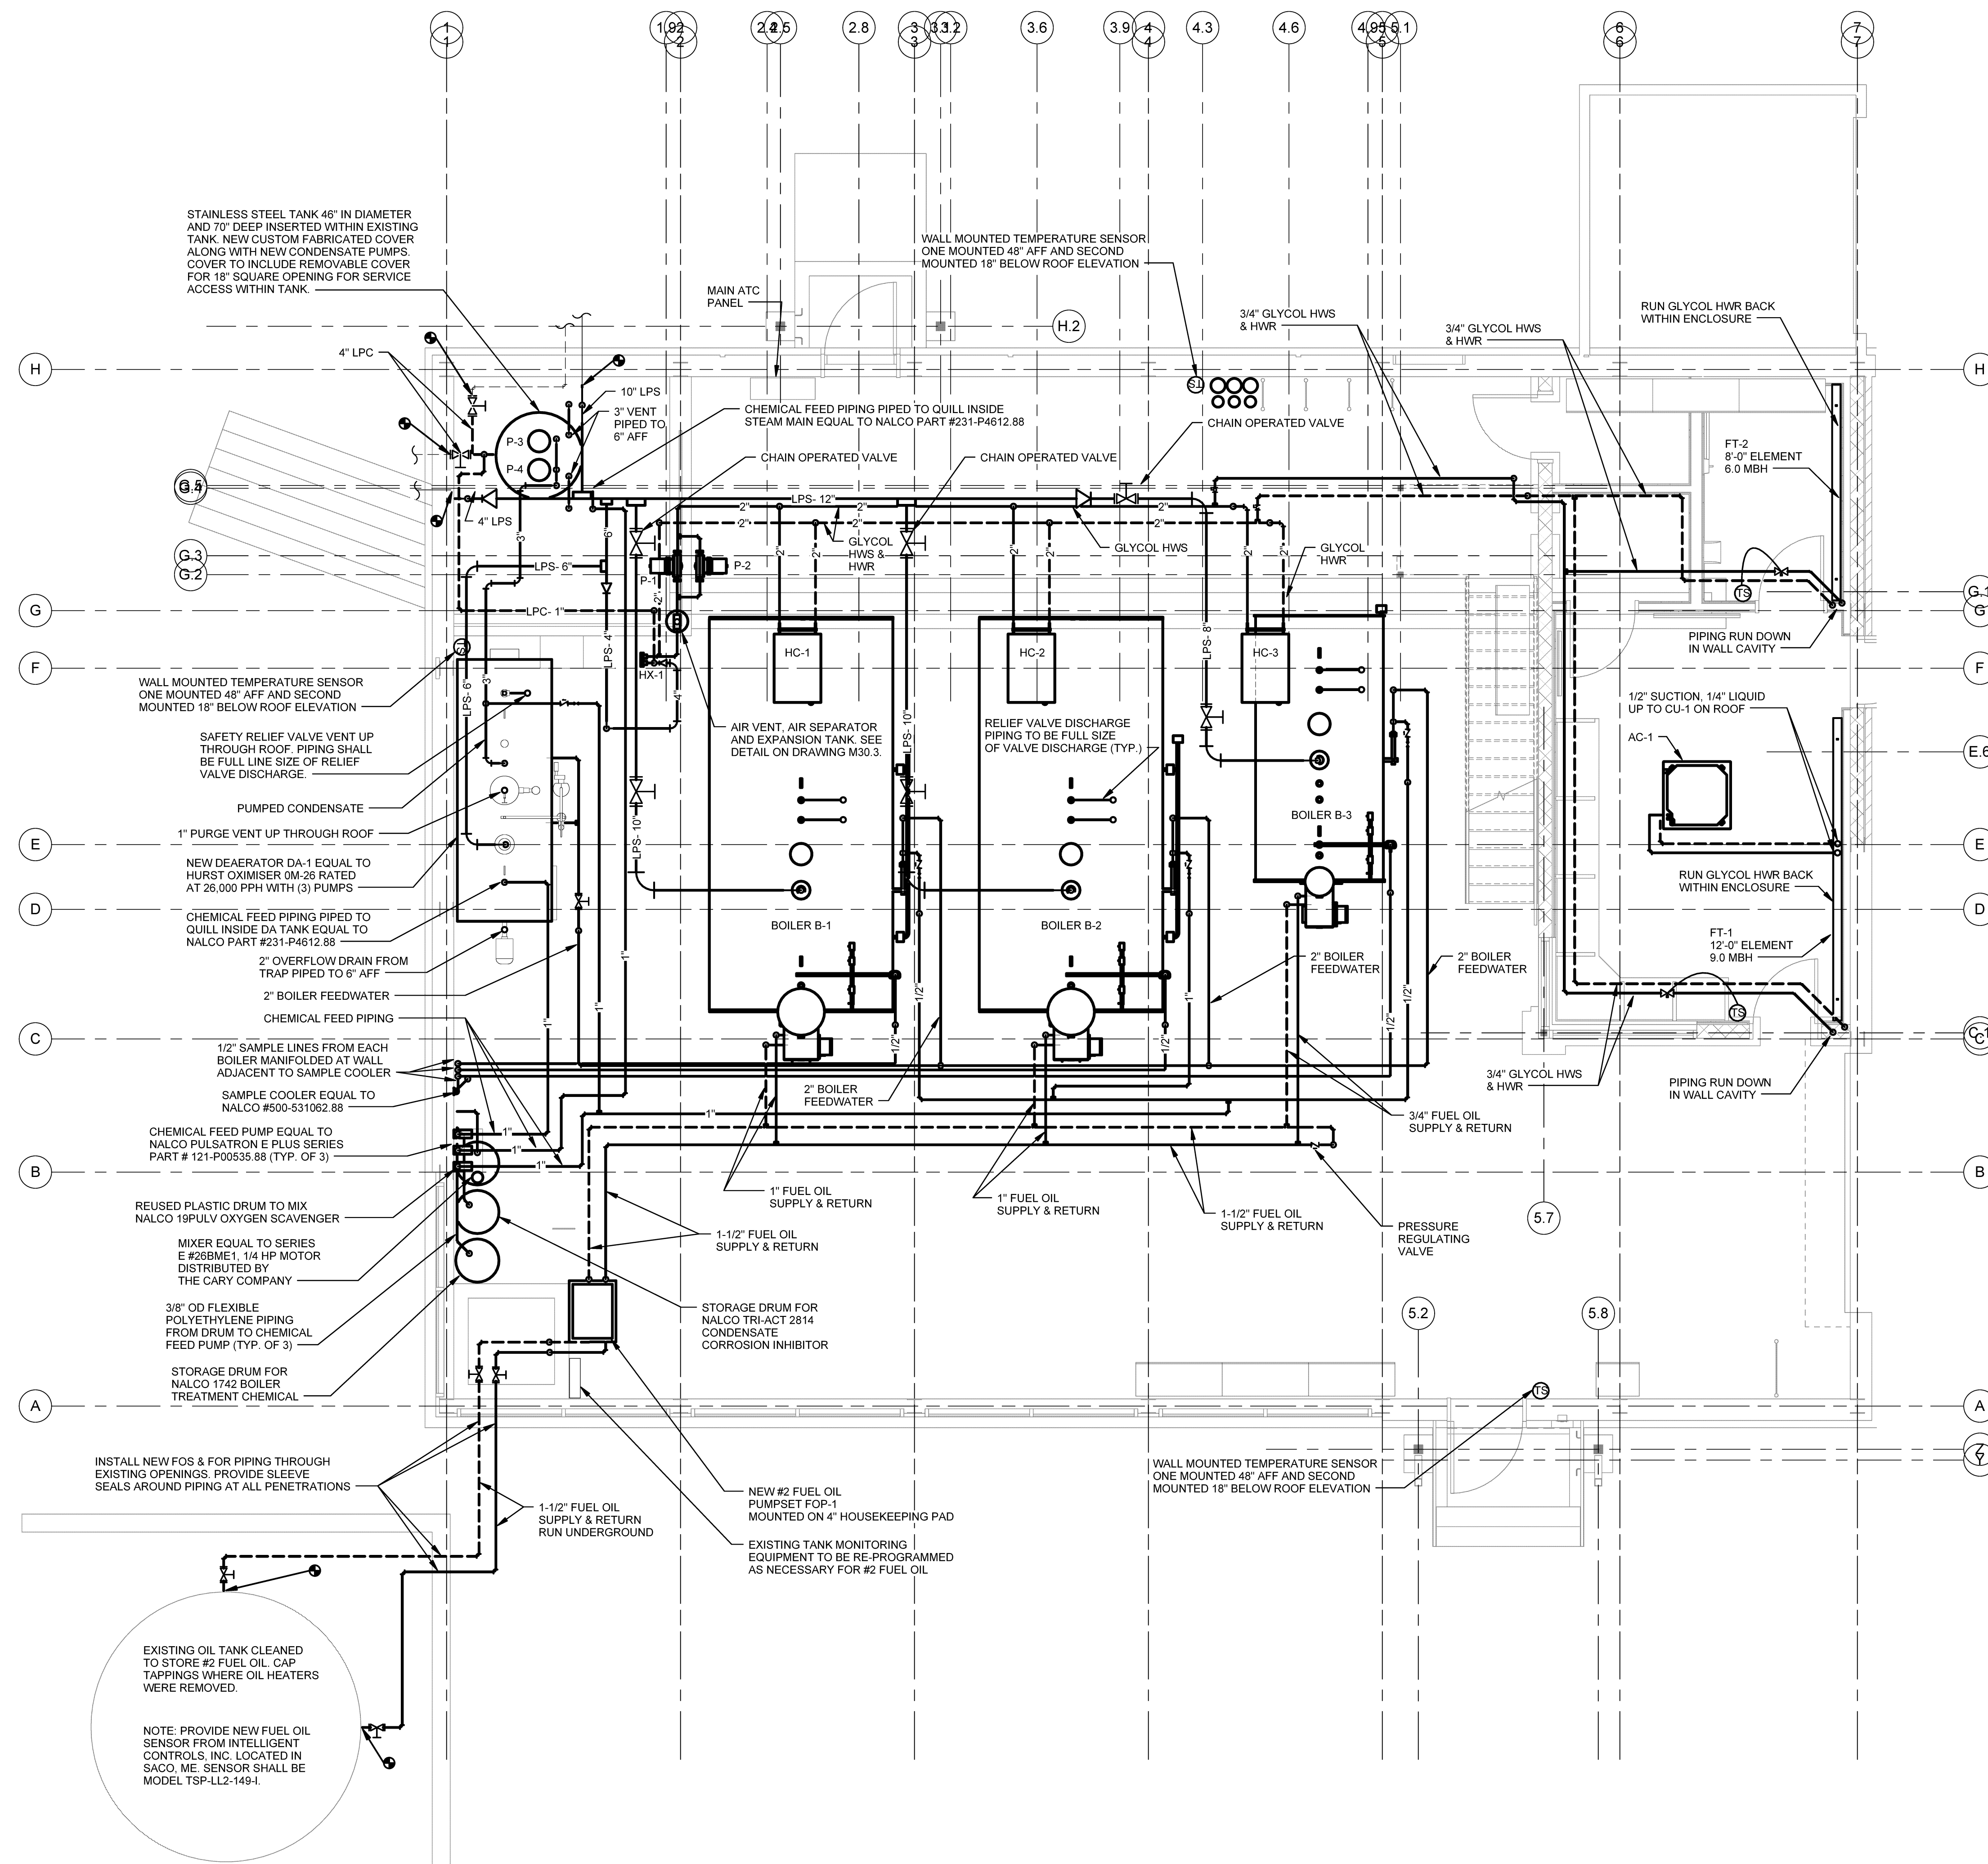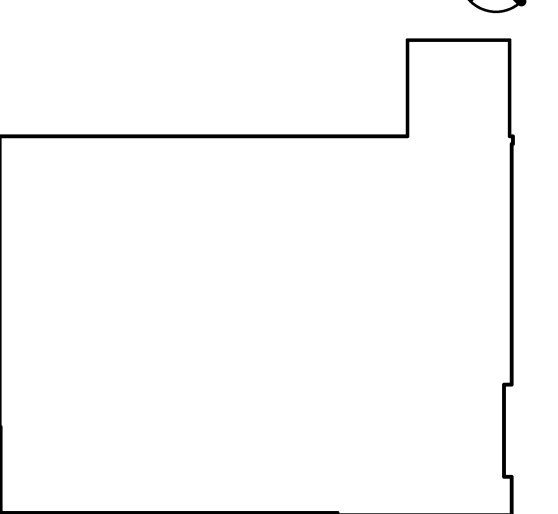

1 FIRST FLOOR PIPING SCALE: 1/4" = 1'-0"

Mark	Date	Description
	08-12-14	SCHEMATIC DESIGN
	08-25-14	REVISED SCHEMATIC DESIGN
	09-05-14	DESIGN DEVELOPMENT
	09-19-14	PROGRESS REVIEW
	09-26-14	PROGRESS REVIEW
	10-03-14	PROGRESS REVIEW
	10-10-14	FINAL REVIEW
	10-23-14	100% REVIEW
	10-31-14	ISSUED FOR BID

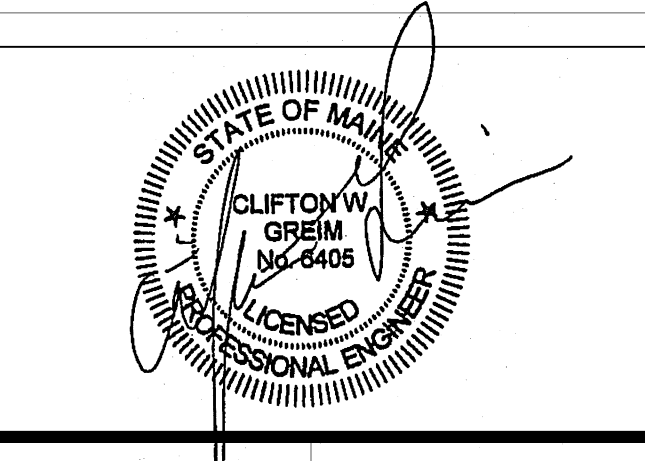

Mark	Date	Description
	08-12-14	SCHEMATIC DESIGN
	08-25-14	REVISED SCHEMATIC DESIGN
	09-05-14	DESIGN DEVELOPMENT
	09-19-14	PROGRESS REVIEW
	09-26-14	PROGRESS REVIEW
	10-03-14	PROGRESS REVIEW
	10-10-14	FINAL REVIEW
	10-23-14	100% REVIEW
	10-31-14	ISSUED FOR BID

FIRST FLOOR PIPING PLAN

M20.1

Plot Date: 10/29/2014 9:03:22 AM