

160 Veranda Street
 Portland, Maine 04103
 T: 207.221.2240
 F: 207.221.2246
 Web: www.allied-eng.com




**PAYSON-SMITH HALL
 CHEMISTRY LAB
 RENOVATION**

96 Falmouth Street, Portland ME
 04101


NO.	DESCRIPTION	DATE

CONTENT: MECHANICAL FLOOR PLANS	
DRAWN BY:	SGH
PROJECT NO.:	14-075-00
DATE:	01/09/2015
REVISED:	
SCALE:	AS NOTED
M1.0	
Project Phase BID DOCUMENTS	
<small>COPYRIGHT © 2014 BY LAVALLEE BRENSINGER PROFESSIONAL ASSOCIATION. ALL RIGHTS RESERVED. NO REPRODUCTION WITHOUT PERMISSION.</small>	

KEYED NOTES:
 1. 1" NG AT 2 PSI FROM BELOW. REDUCE GAS PRESSURE TO MUA-1 MANUFACTURER'S RECOMMENDATIONS.

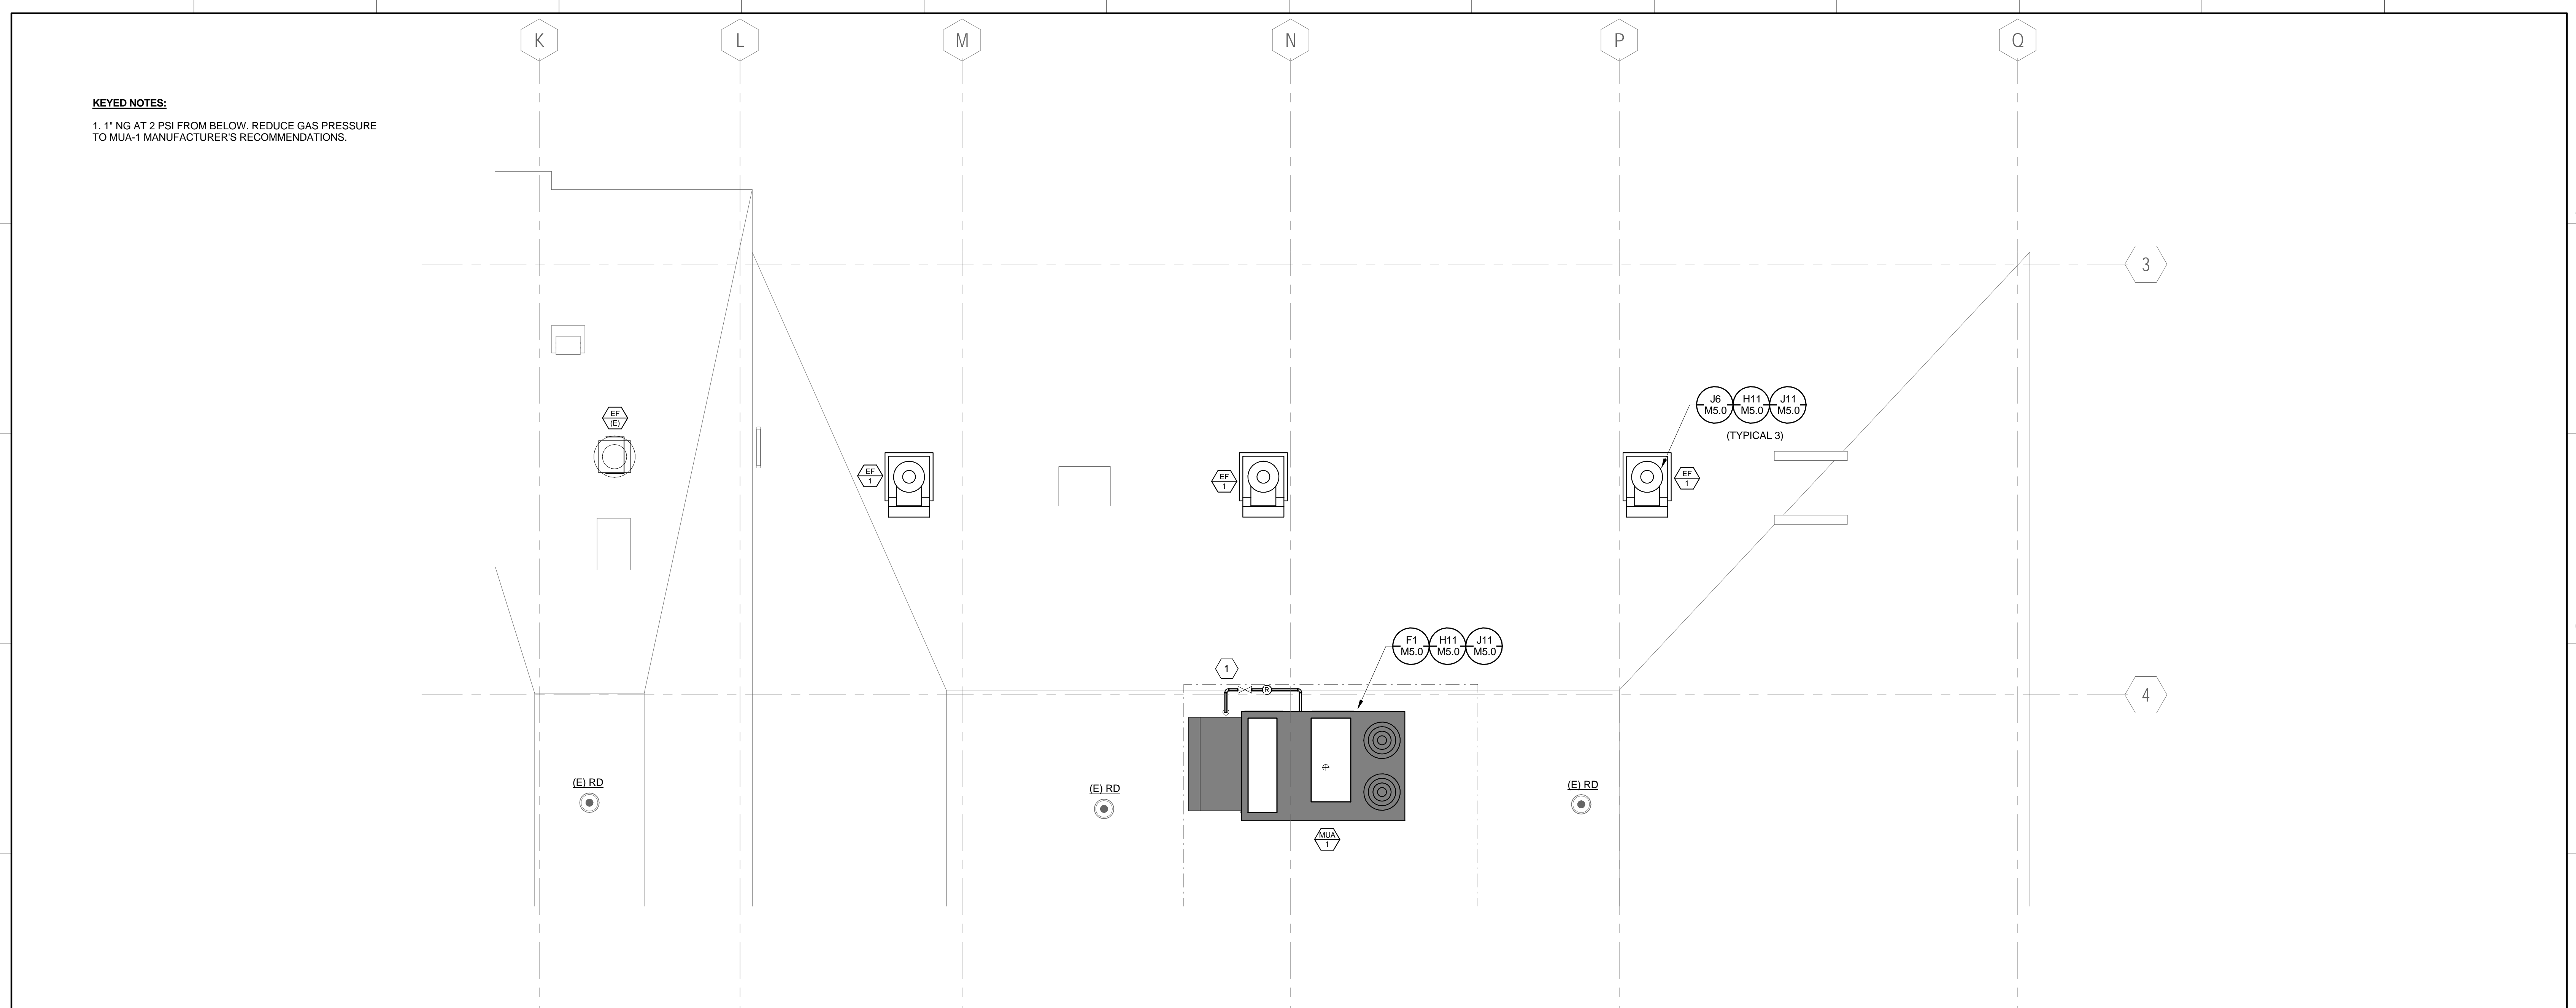

E1 ROOF FLOOR PLAN - HVAC
 1/4" = 1'-0"

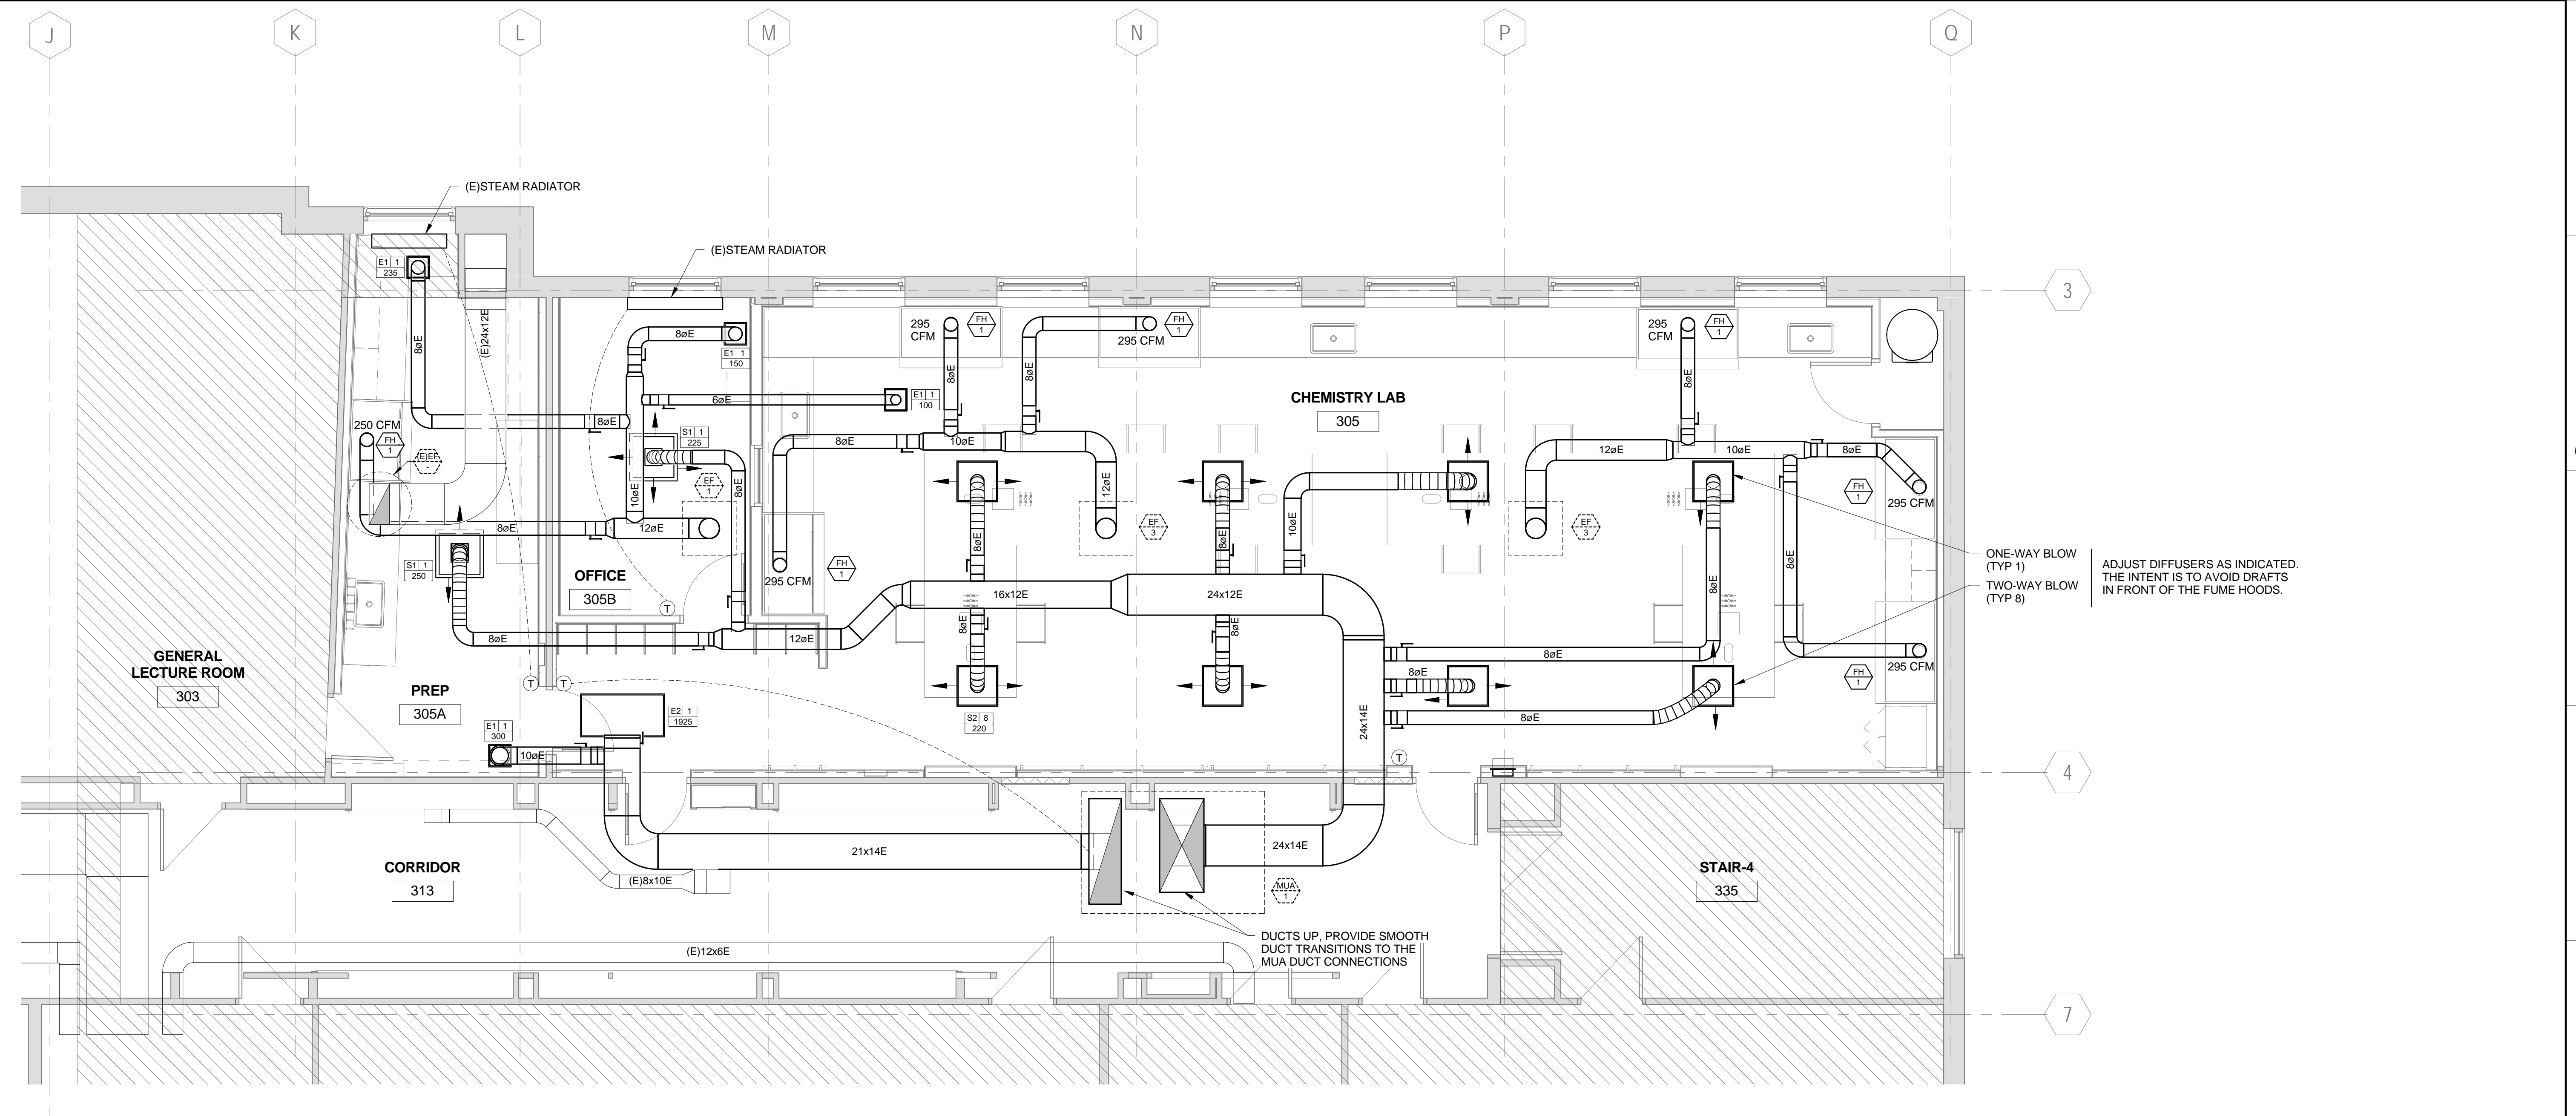

J1 THIRD FLOOR PLAN - HVAC1
 1/4" = 1'-0"

1/8/2015 9:28:25 AM N:\Projects\2014\14-075 - USM Payson 405 Laboratory Renovation\001 Drawing Files\140752M1.dwg