

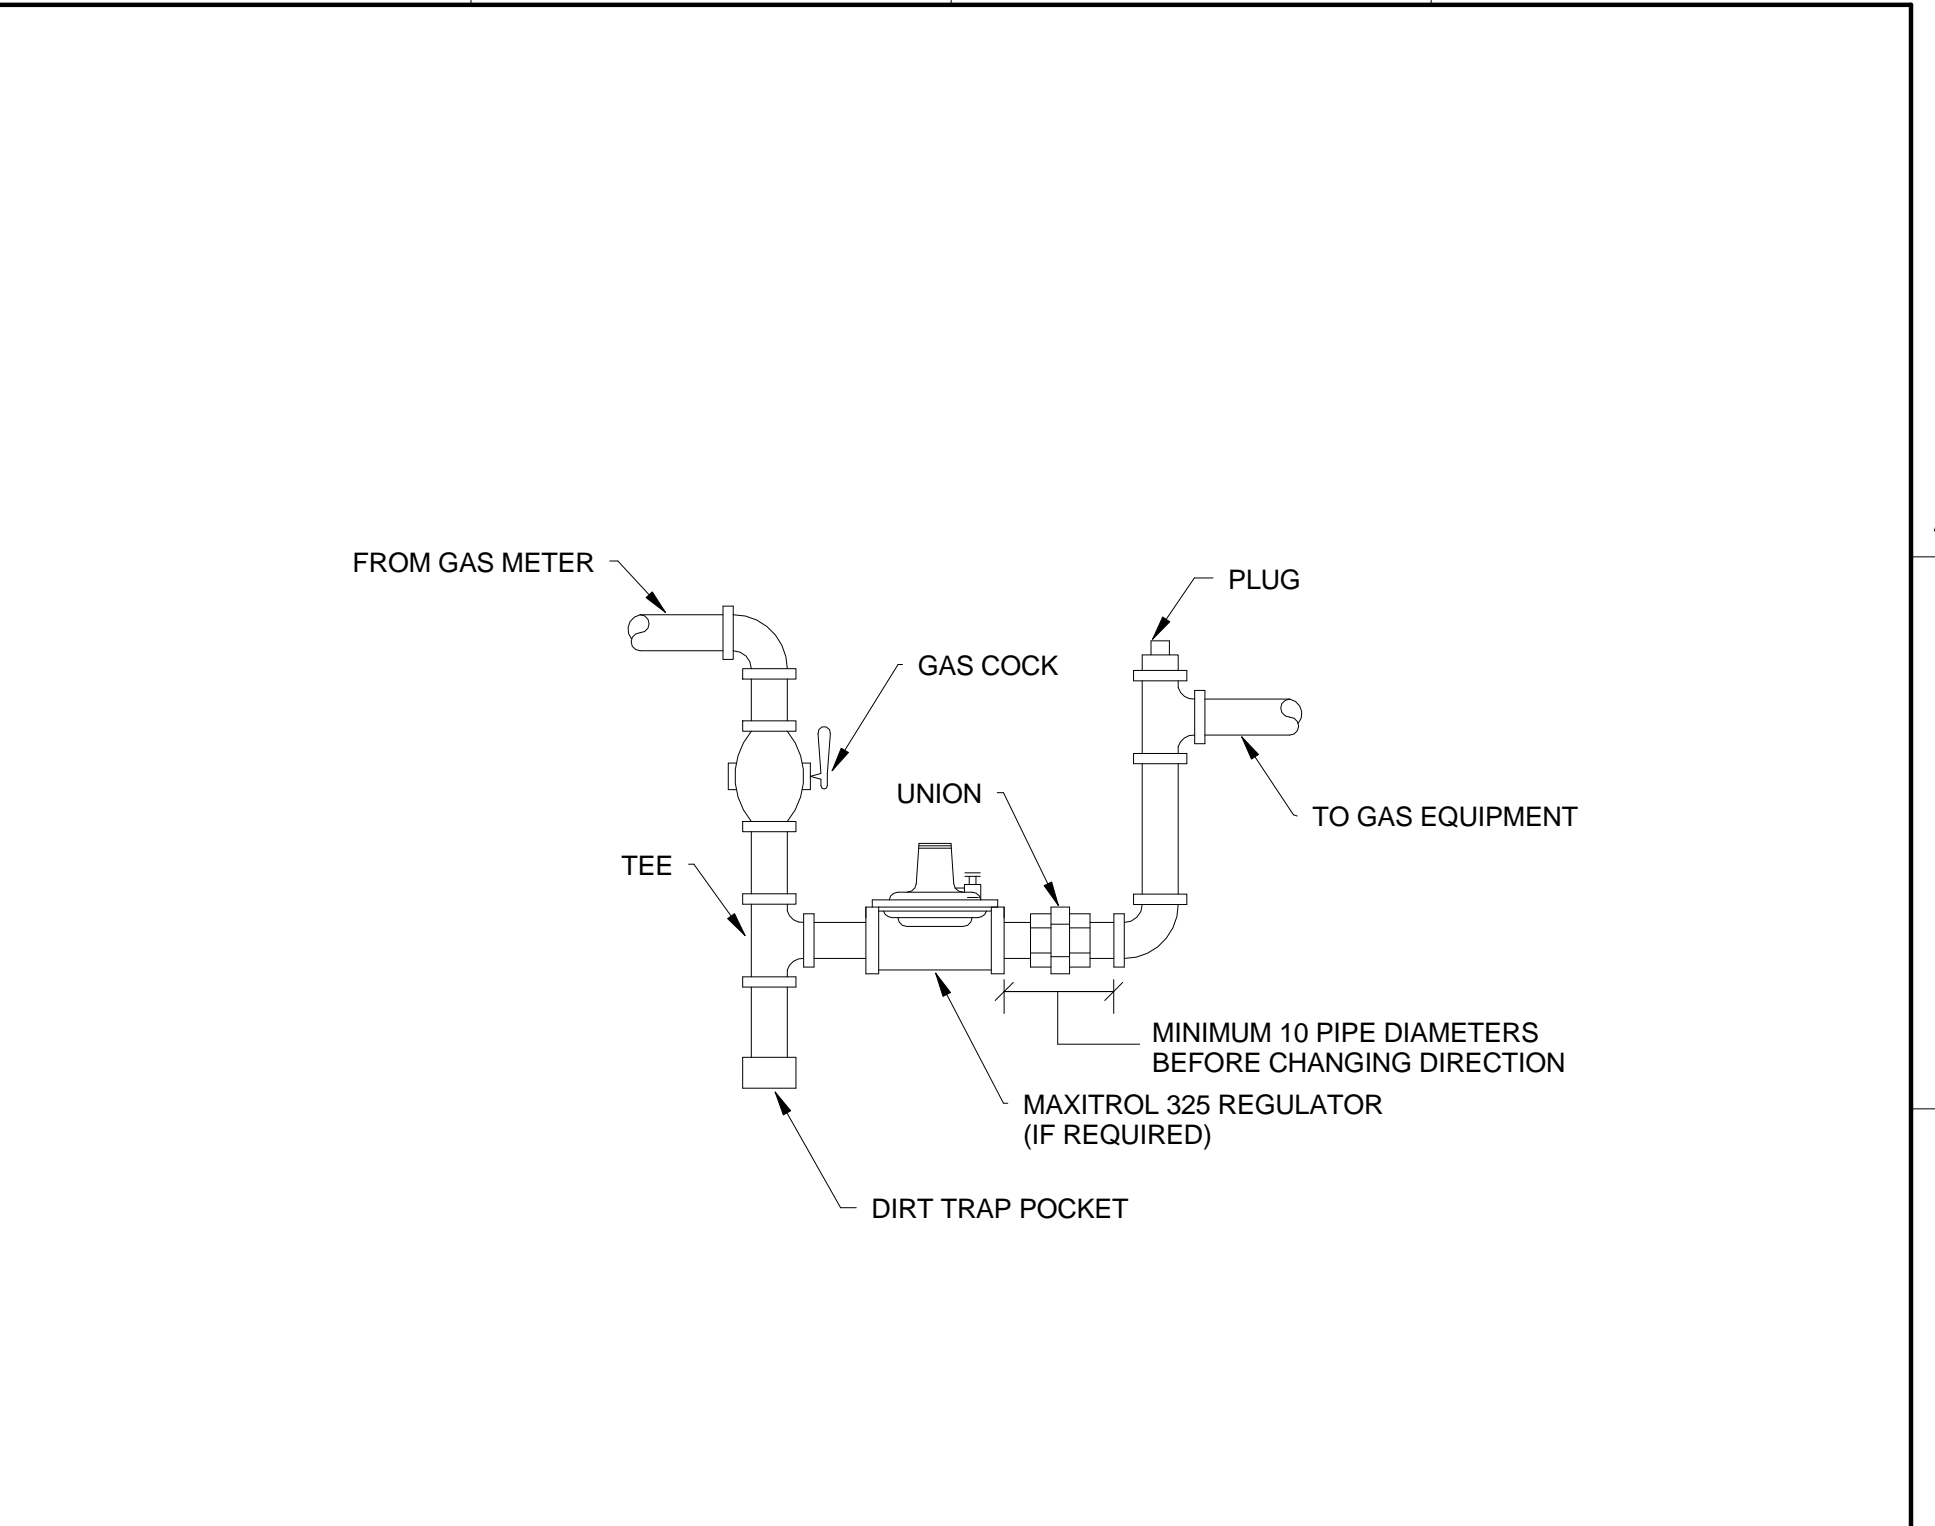
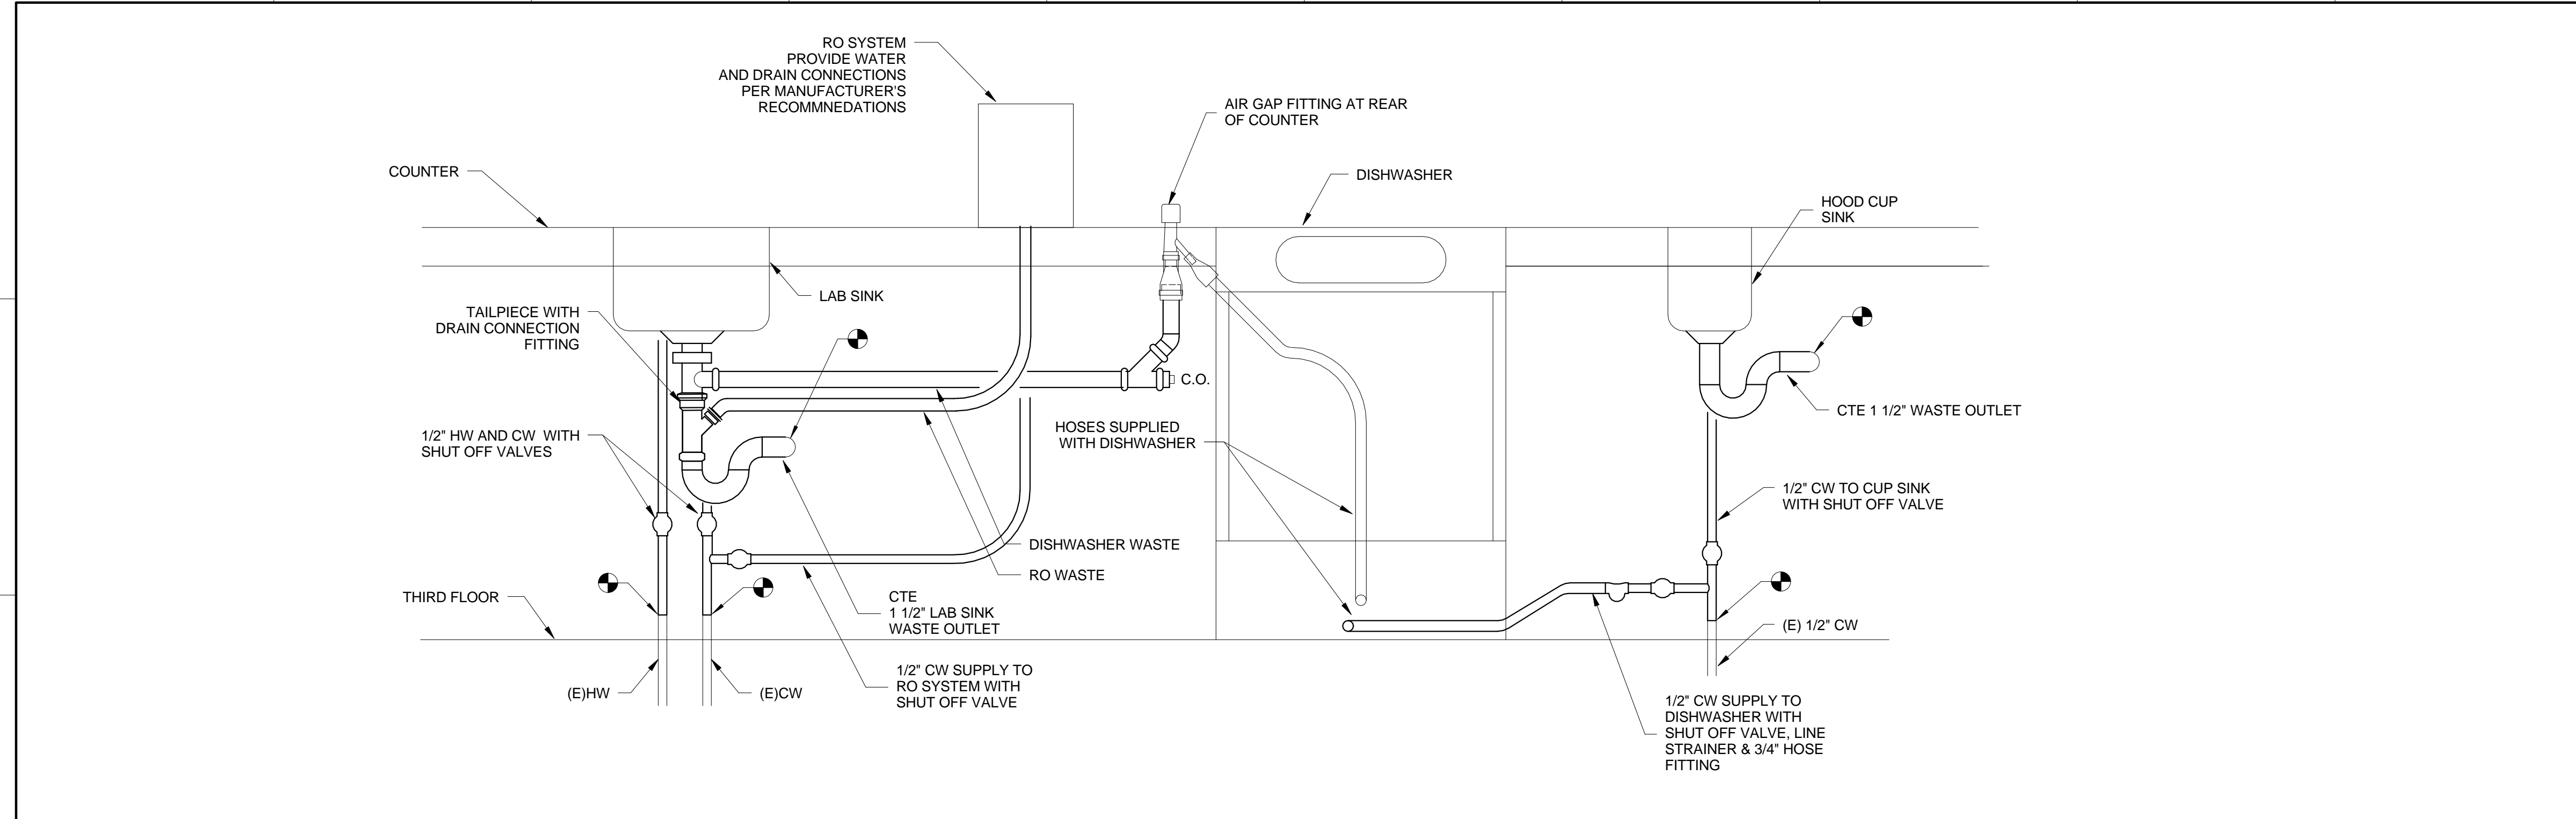


160 Veranda Street  
 Portland, Maine 04103  
 T: 207.221.2260  
 F: 207.221.2266  
 Web: www.allied-eng.com

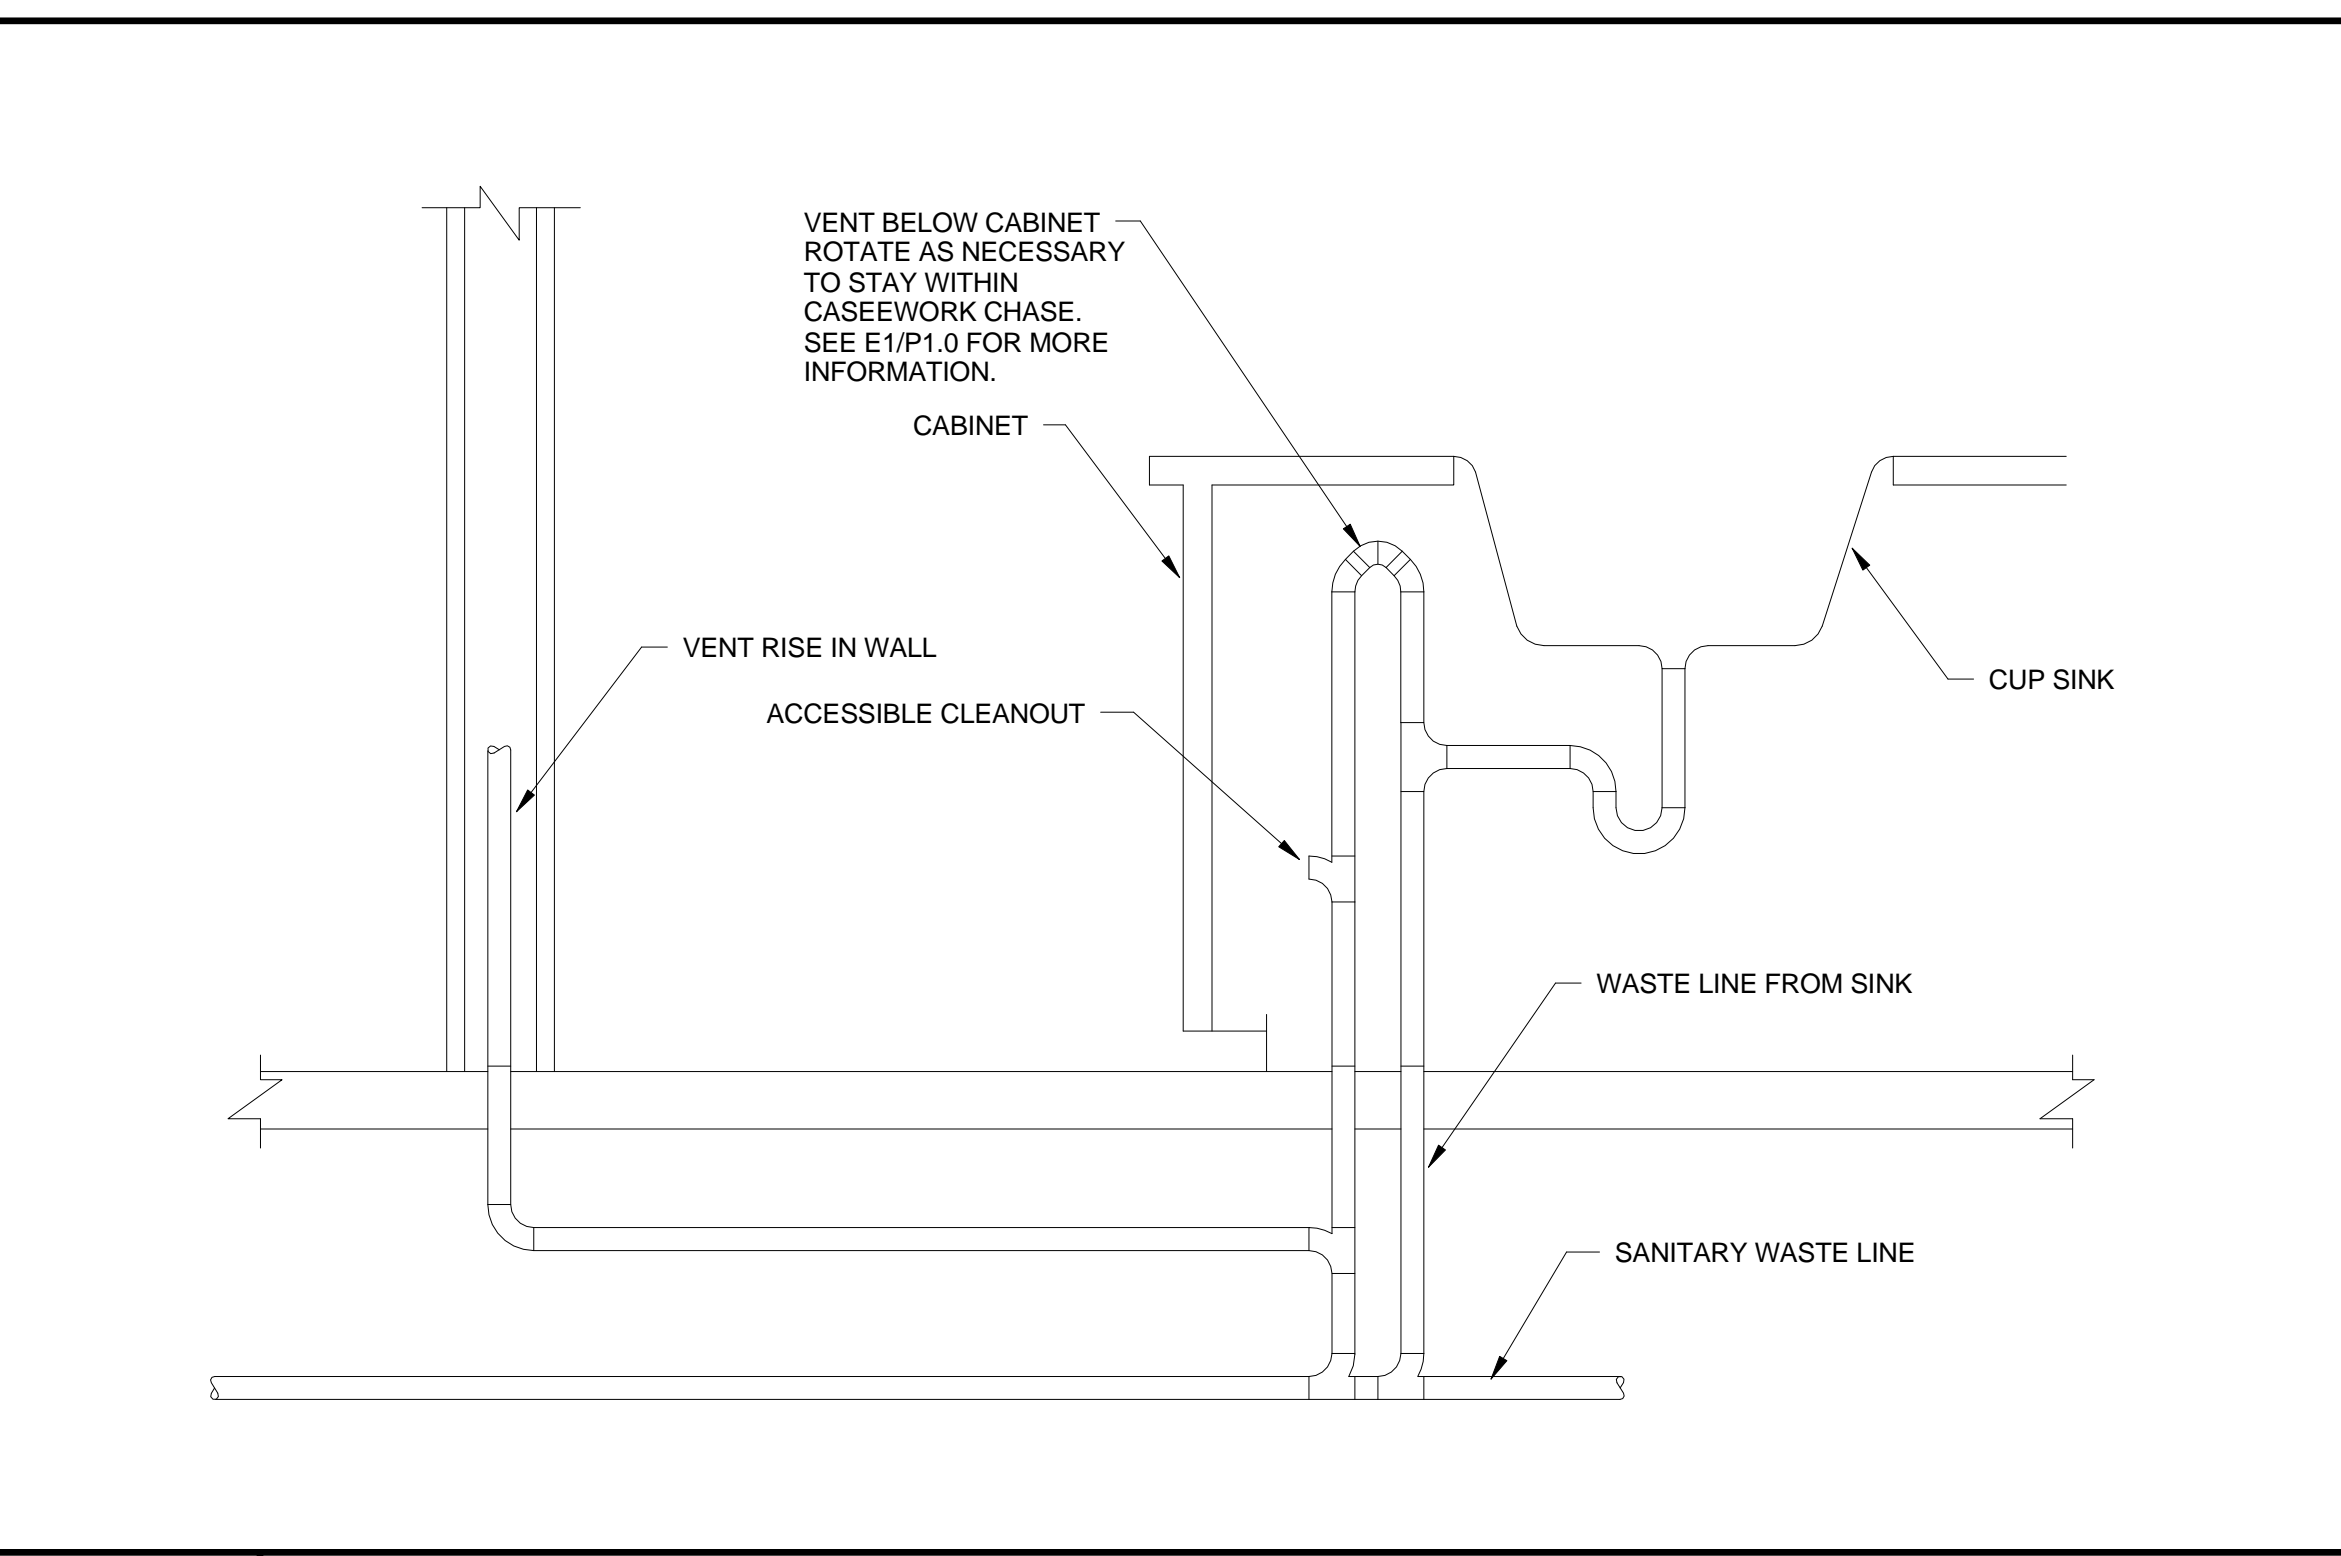



C1 DETAIL - PREP ROOM PLUMBING

C11 DETAIL - GAS EQUIPMENT CONNECTION

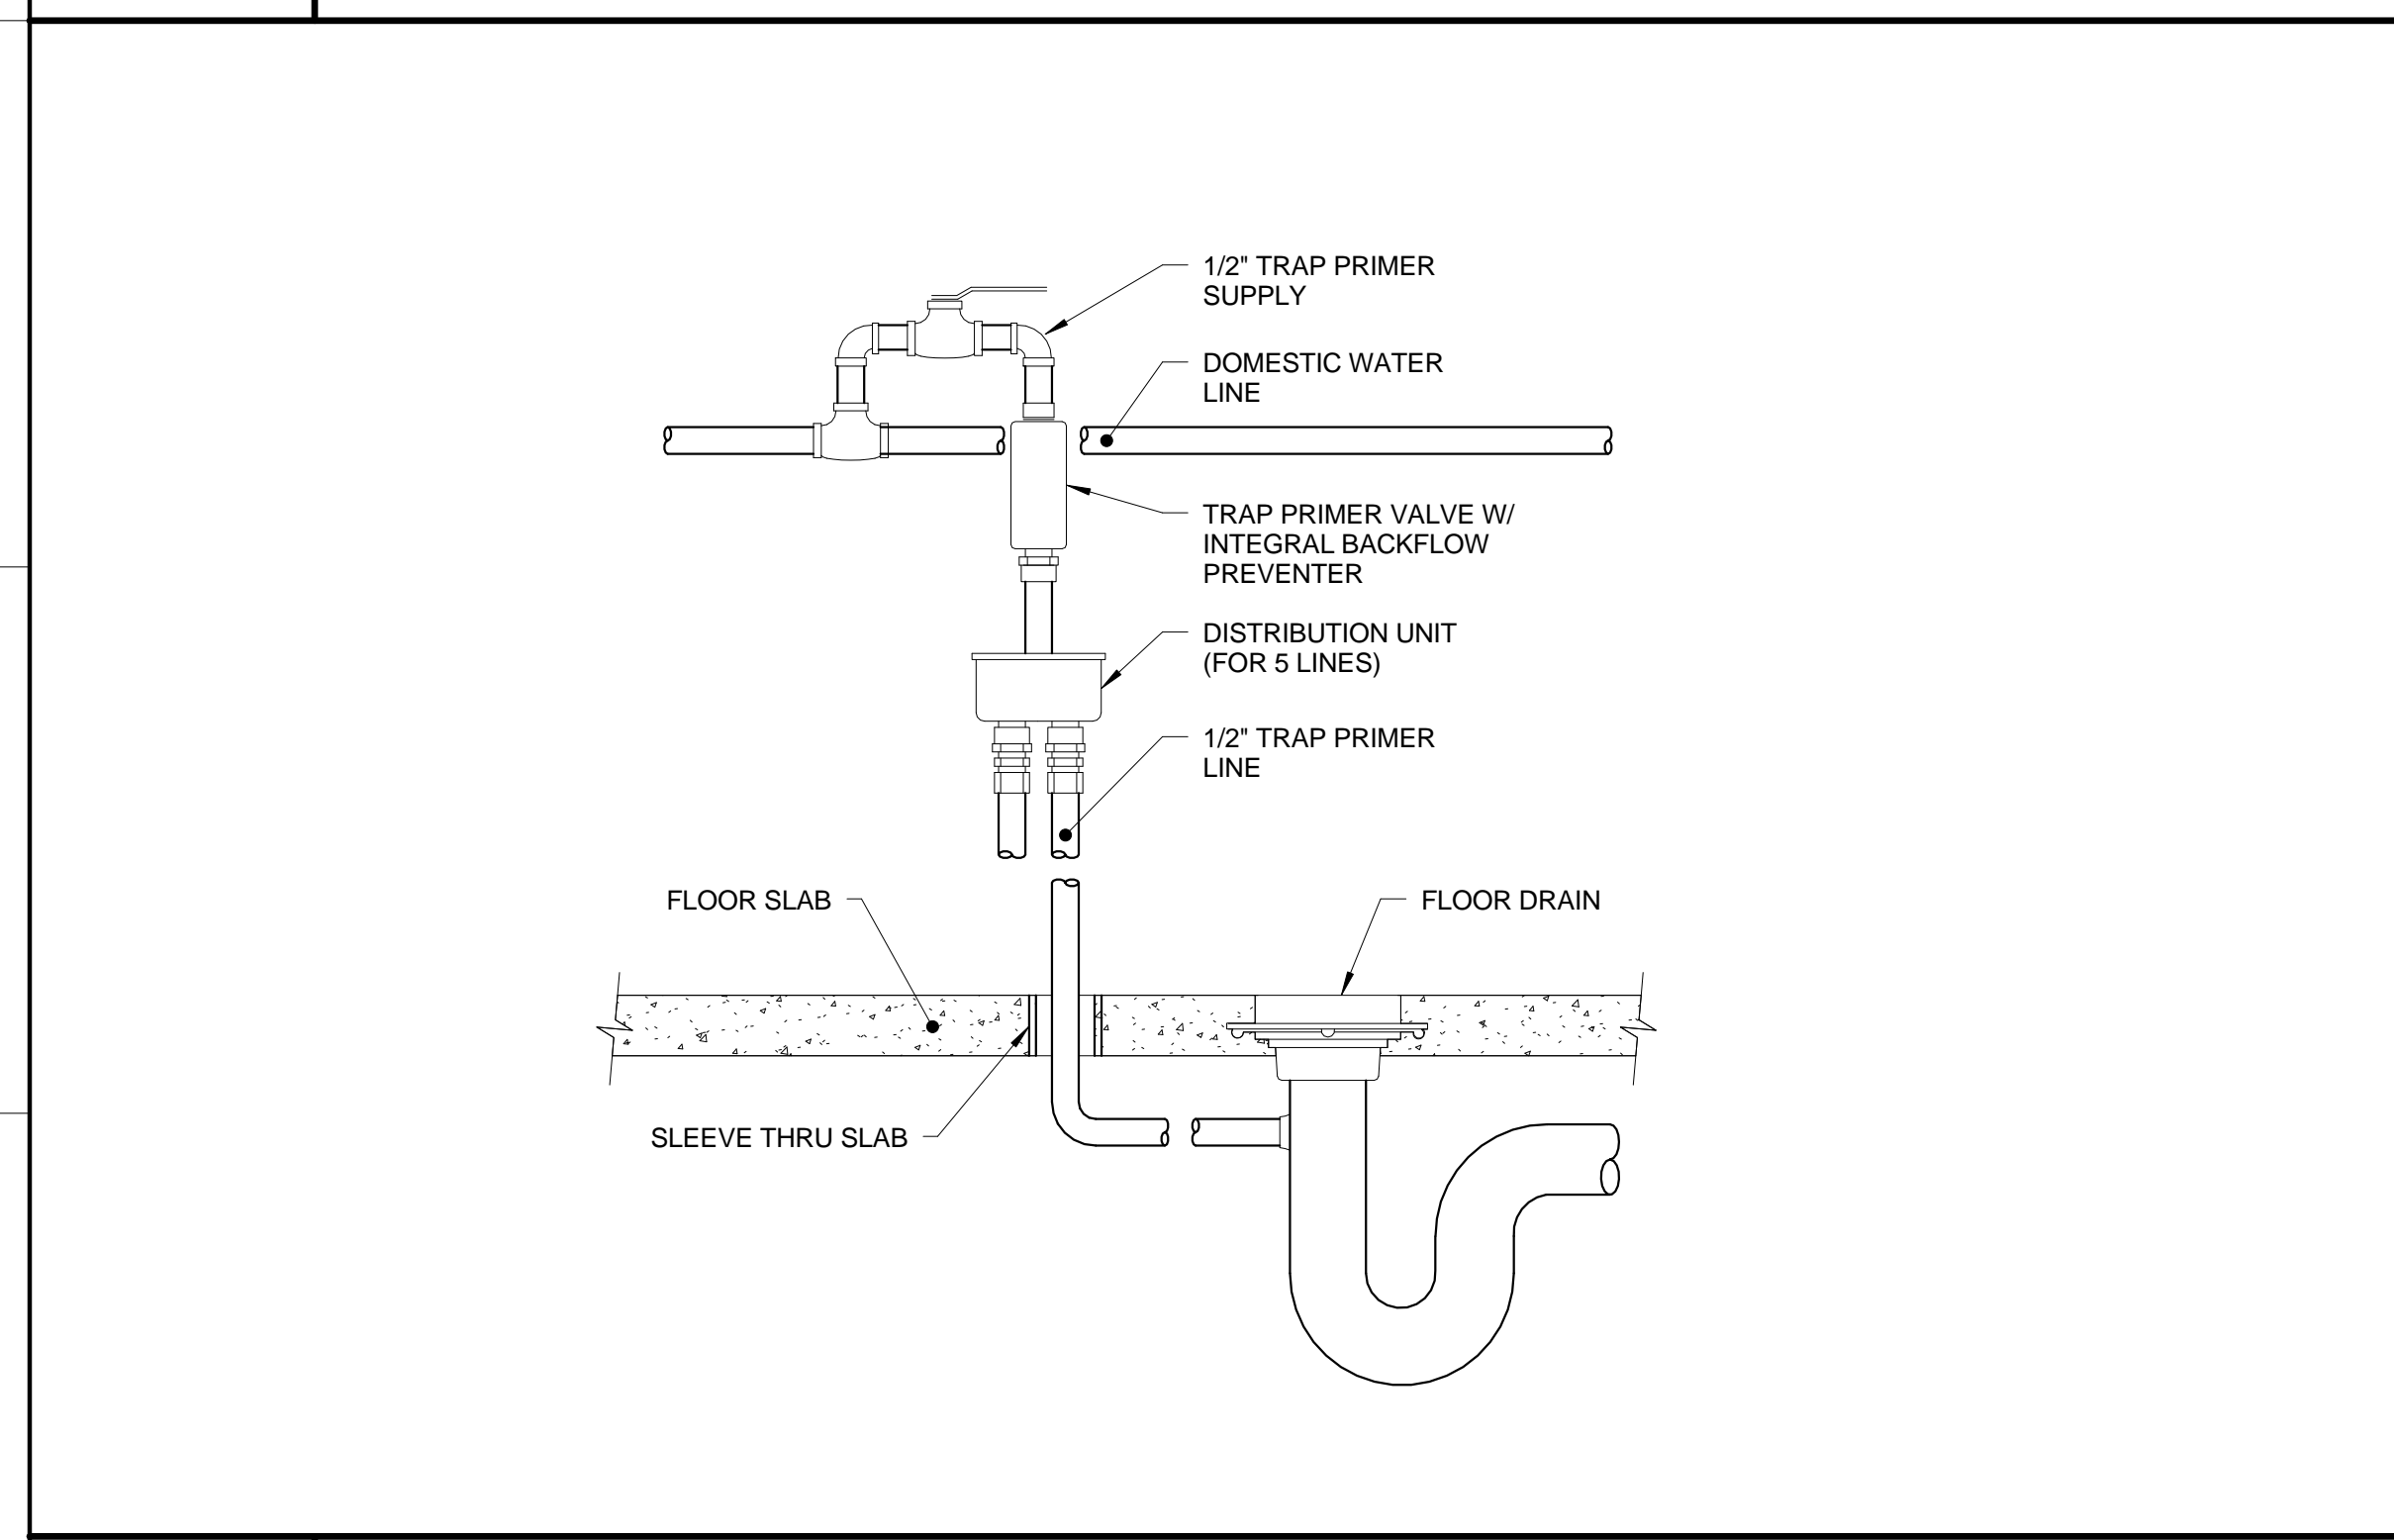


F1 DETAIL - AUTOMATIC TRAP PRIMER

F6 DETAIL - ISLAND VENT

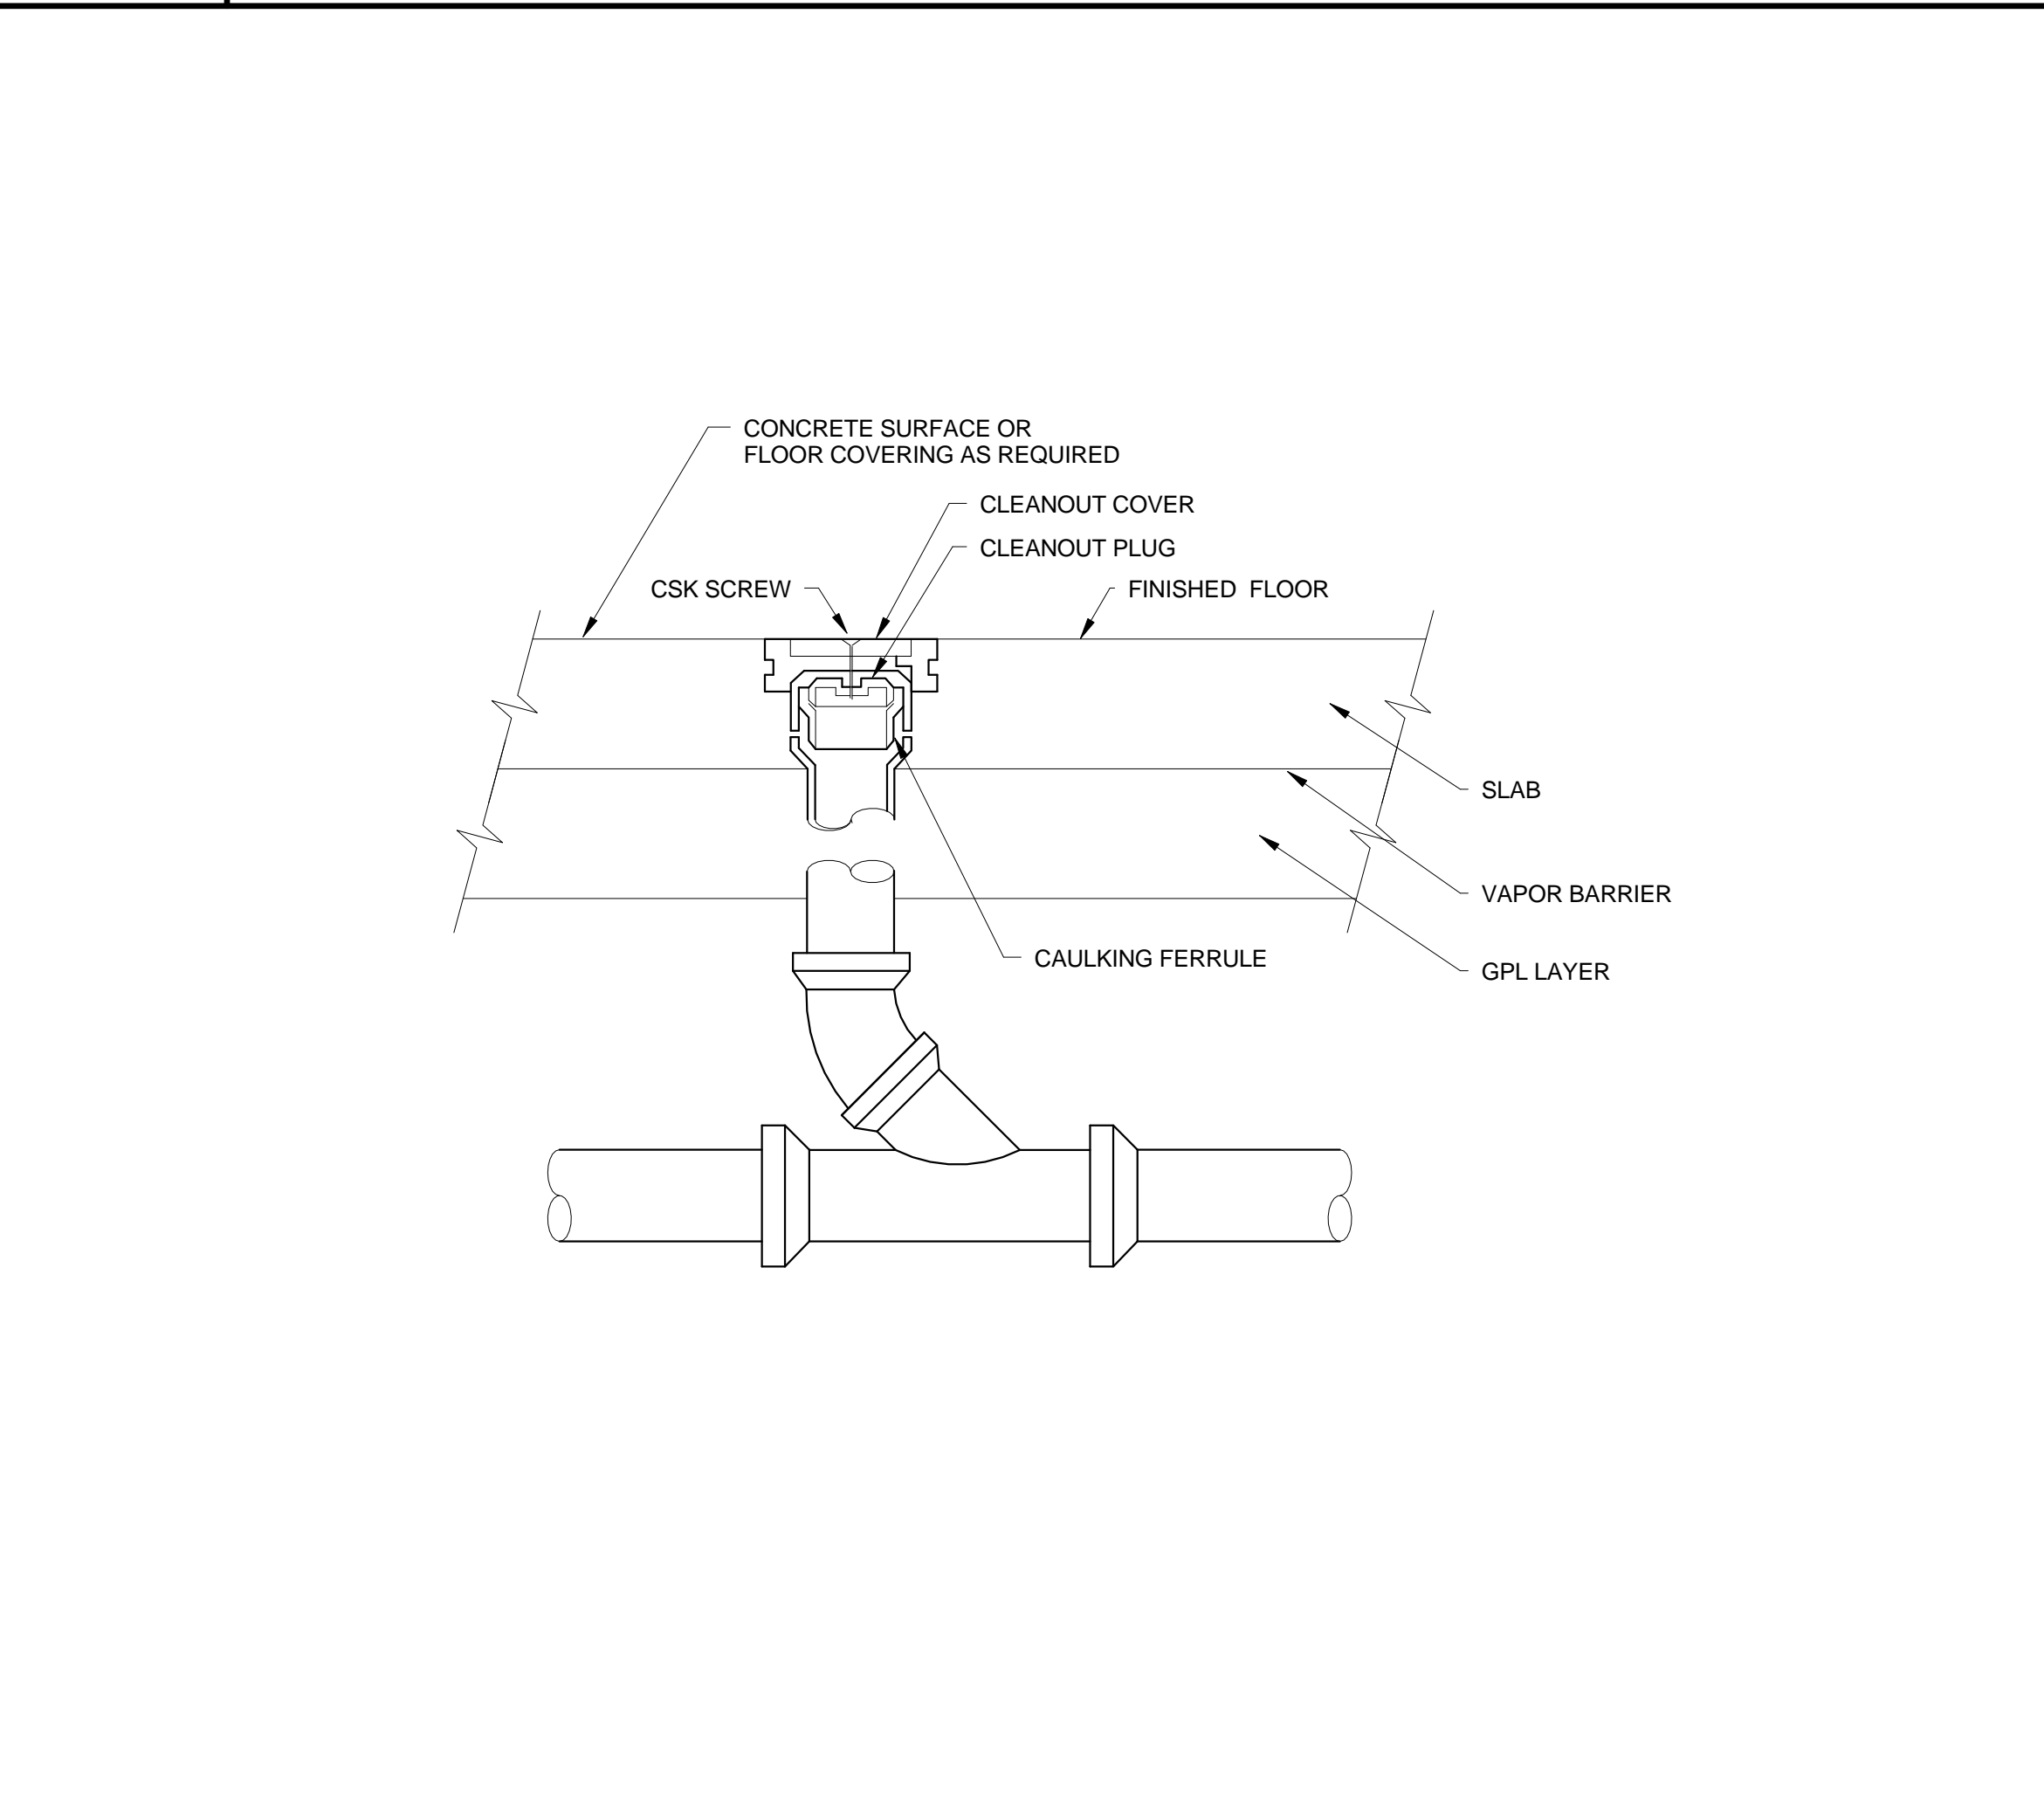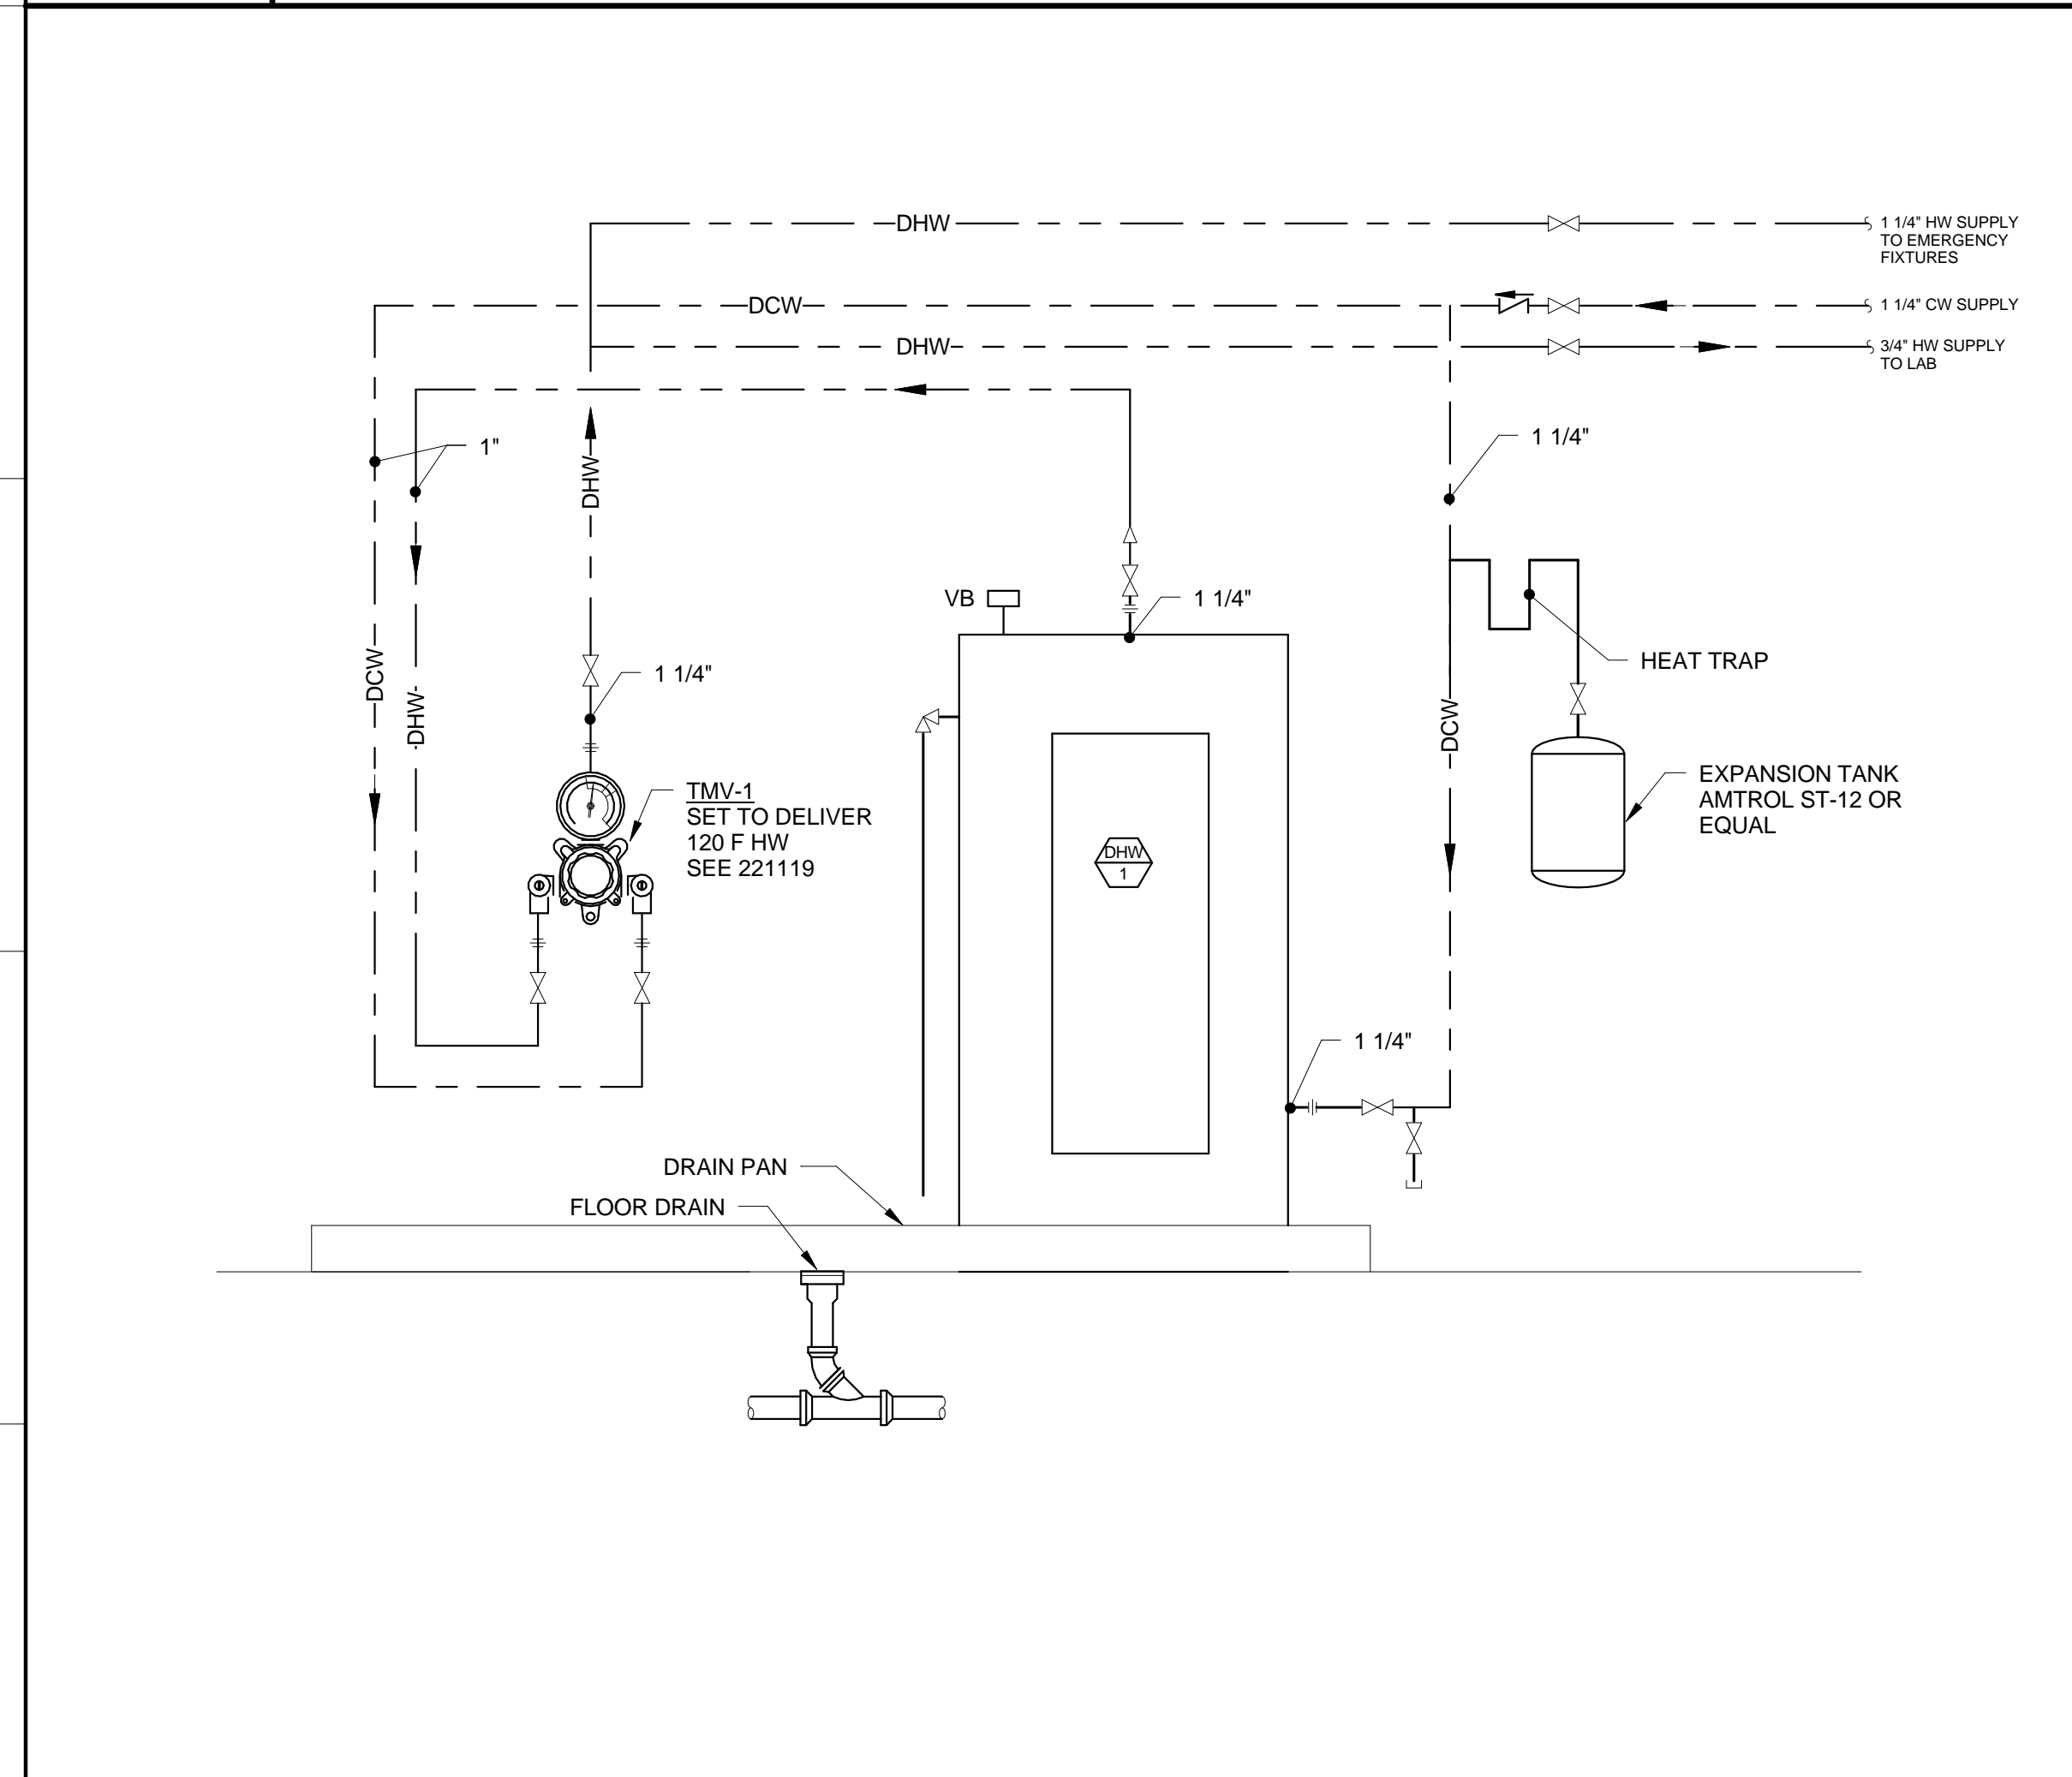

J1 DETAIL - ELECTRIC WATER HEATER

J6 DETAIL - FLOOR DRAIN

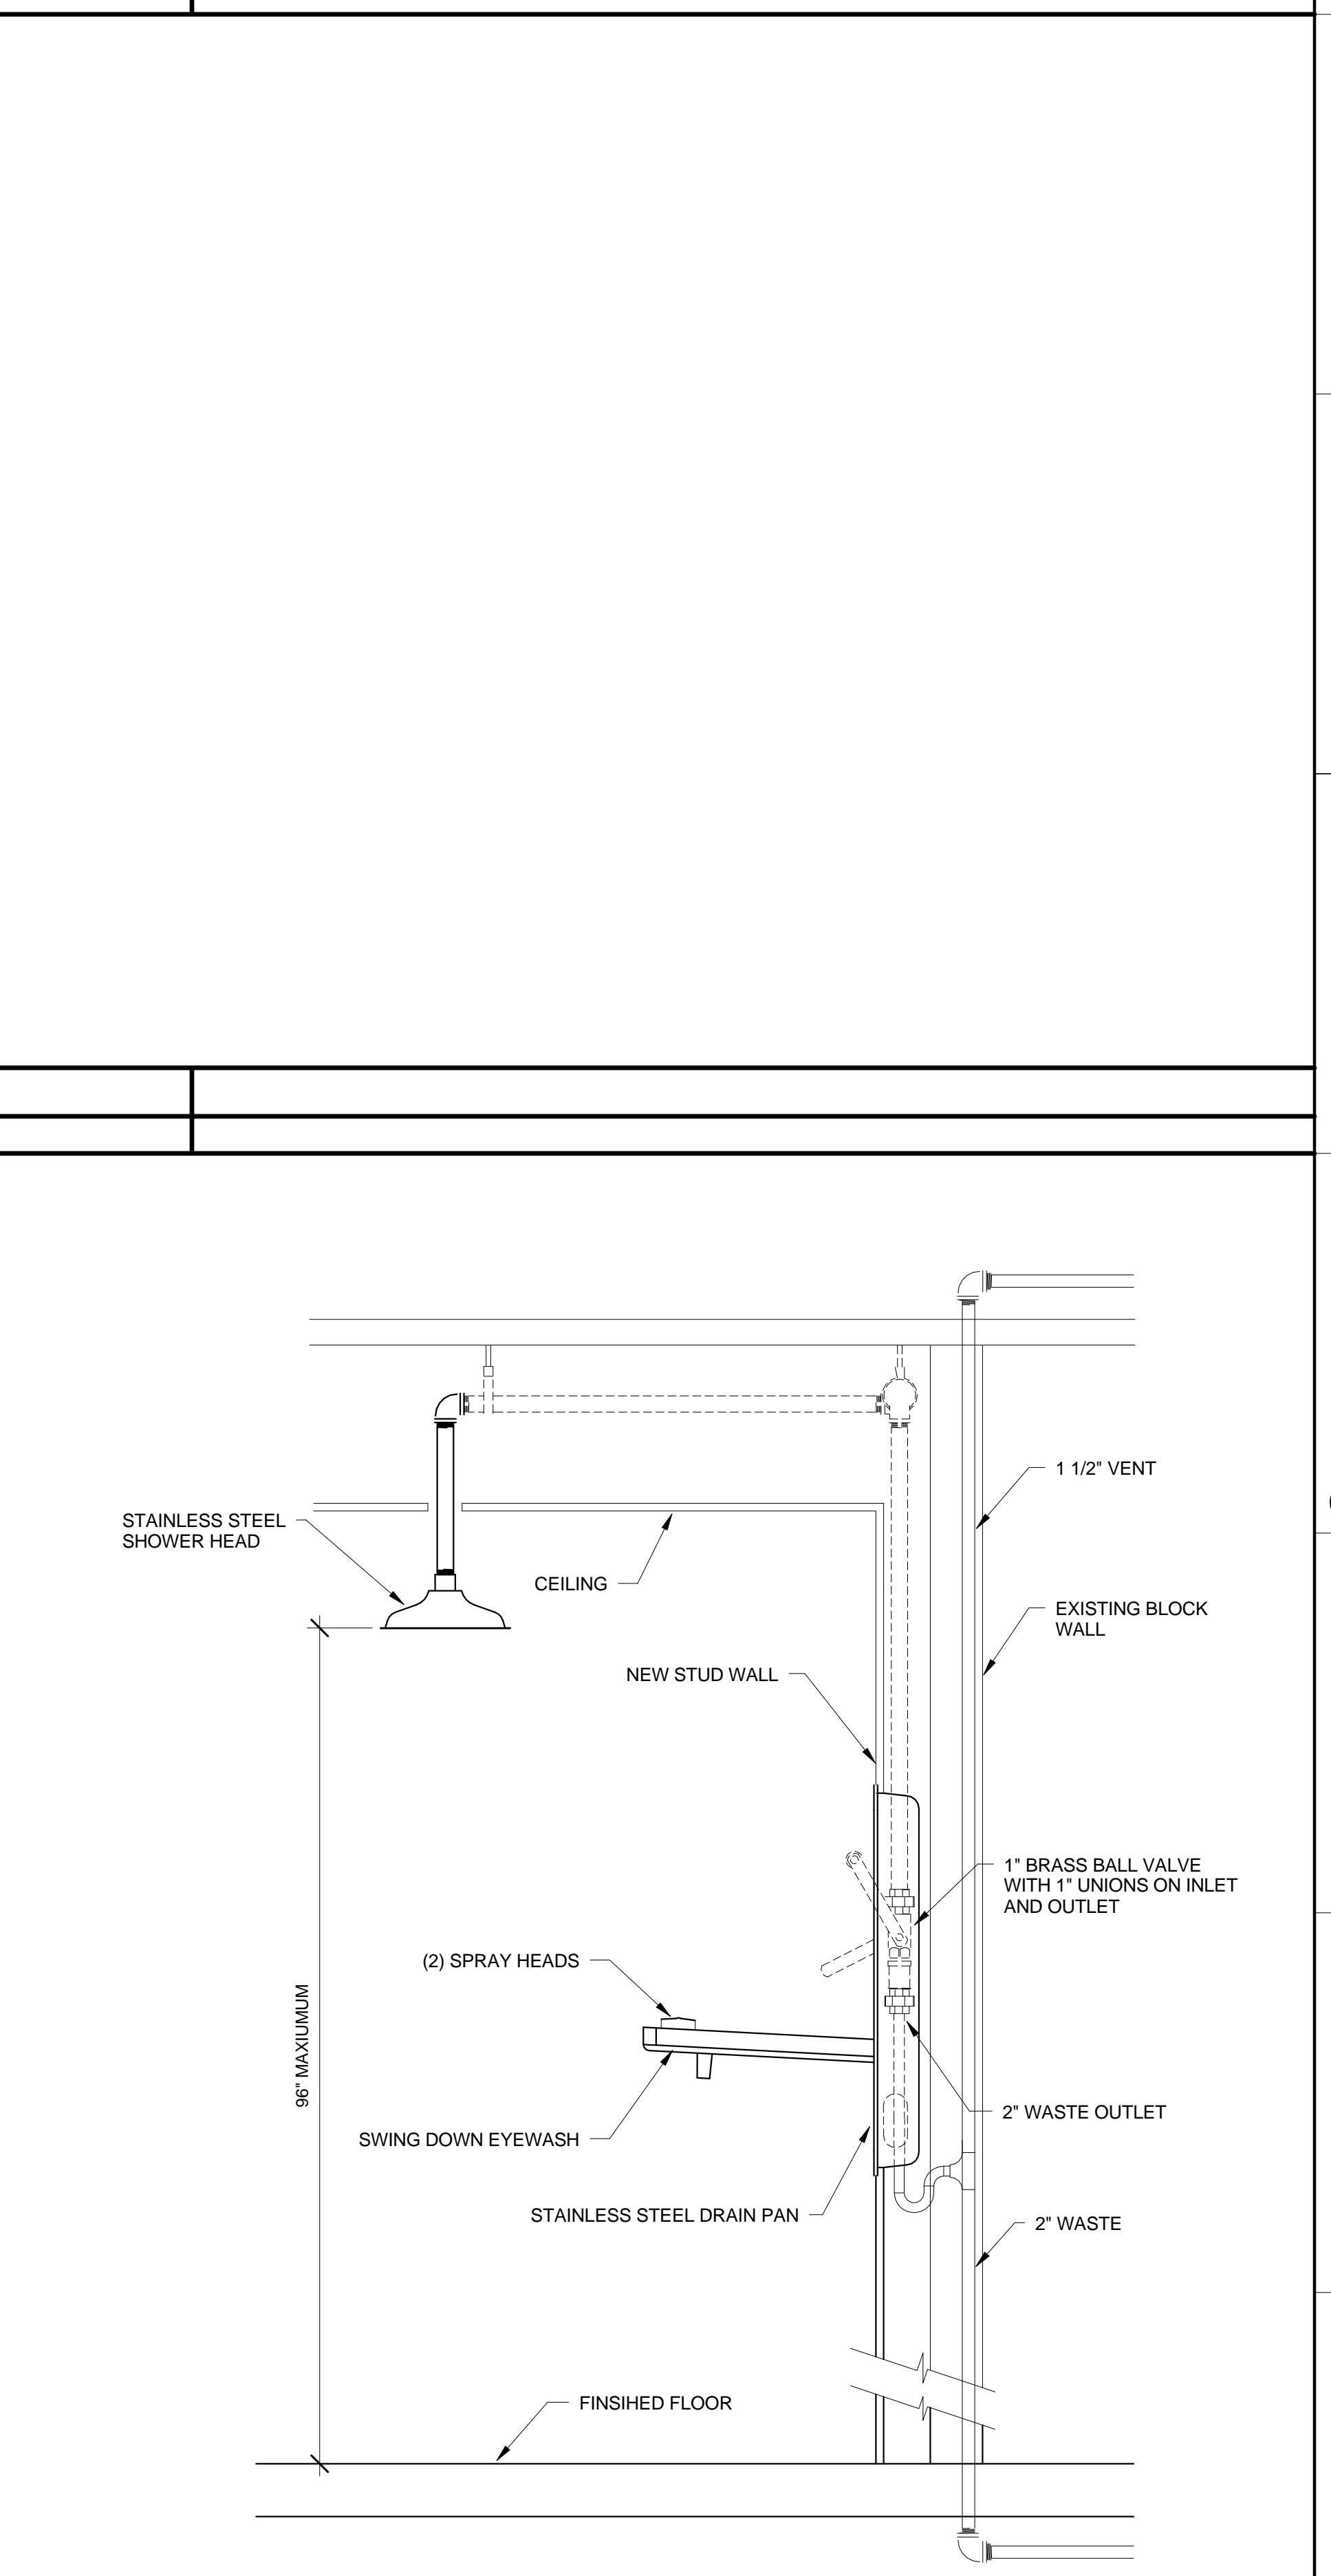

J11 DETAIL - SAFETY STATION SS-1

Owner

**PAYSON-SMITH HALL  
 CHEMISTRY LAB  
 RENOVATION**

96 Falmouth Street, Portland ME  
 04101

NO.	DESCRIPTION	DATE

CONTENT: PLUMBING DETAILS AND SCHEDULES	
DRAWN BY:	Author
PROJECT NO.:	14-075-00
DATE:	01/09/2015
REVISED:	
SCALE:	AS NOTED
<b>P5.0</b>	
Project Phase BID DOCUMENTS	
<small>COPYRIGHT © 2014 BY LAVALLEE BRENSINGER PROFESSIONAL ASSOCIATION. ALL RIGHTS RESERVED. NO REPRODUCTION WITHOUT PERMISSION.</small>	

1/8/2015 1:14:40 PM N:\Projects\2014\14-075 - USM Payson 405 Laboratory Renovation\00 Drawing Files\J11.DWG