



UNIVERSITY OF SOUTHERN MAINE

**SCIENCE BUILDING
 C300 CHEMISTRY LAB**






70 Falmouth Street Portland, Maine
 04101

NO.	DESCRIPTION	DATE



FOR ADDITIONAL INFORMATION, REFER TO PROJECT MANUAL.

CONTENT: REFLECTED CEILING PLAN - ALTERNATE NO. 1	
DRAWN BY:	Author
PROJECT NO.:	14-049-00
DATE:	07/21/2015
REVISED:	
SCALE:	As indicated
A1.4	
Project Phase PERMIT SET	
COPYRIGHT © 2015 BY LAVALLEE BRENSINGER PROFESSIONAL ASSOCIATION. ALL RIGHTS RESERVED. NO REPRODUCTION WITHOUT PERMISSION.	

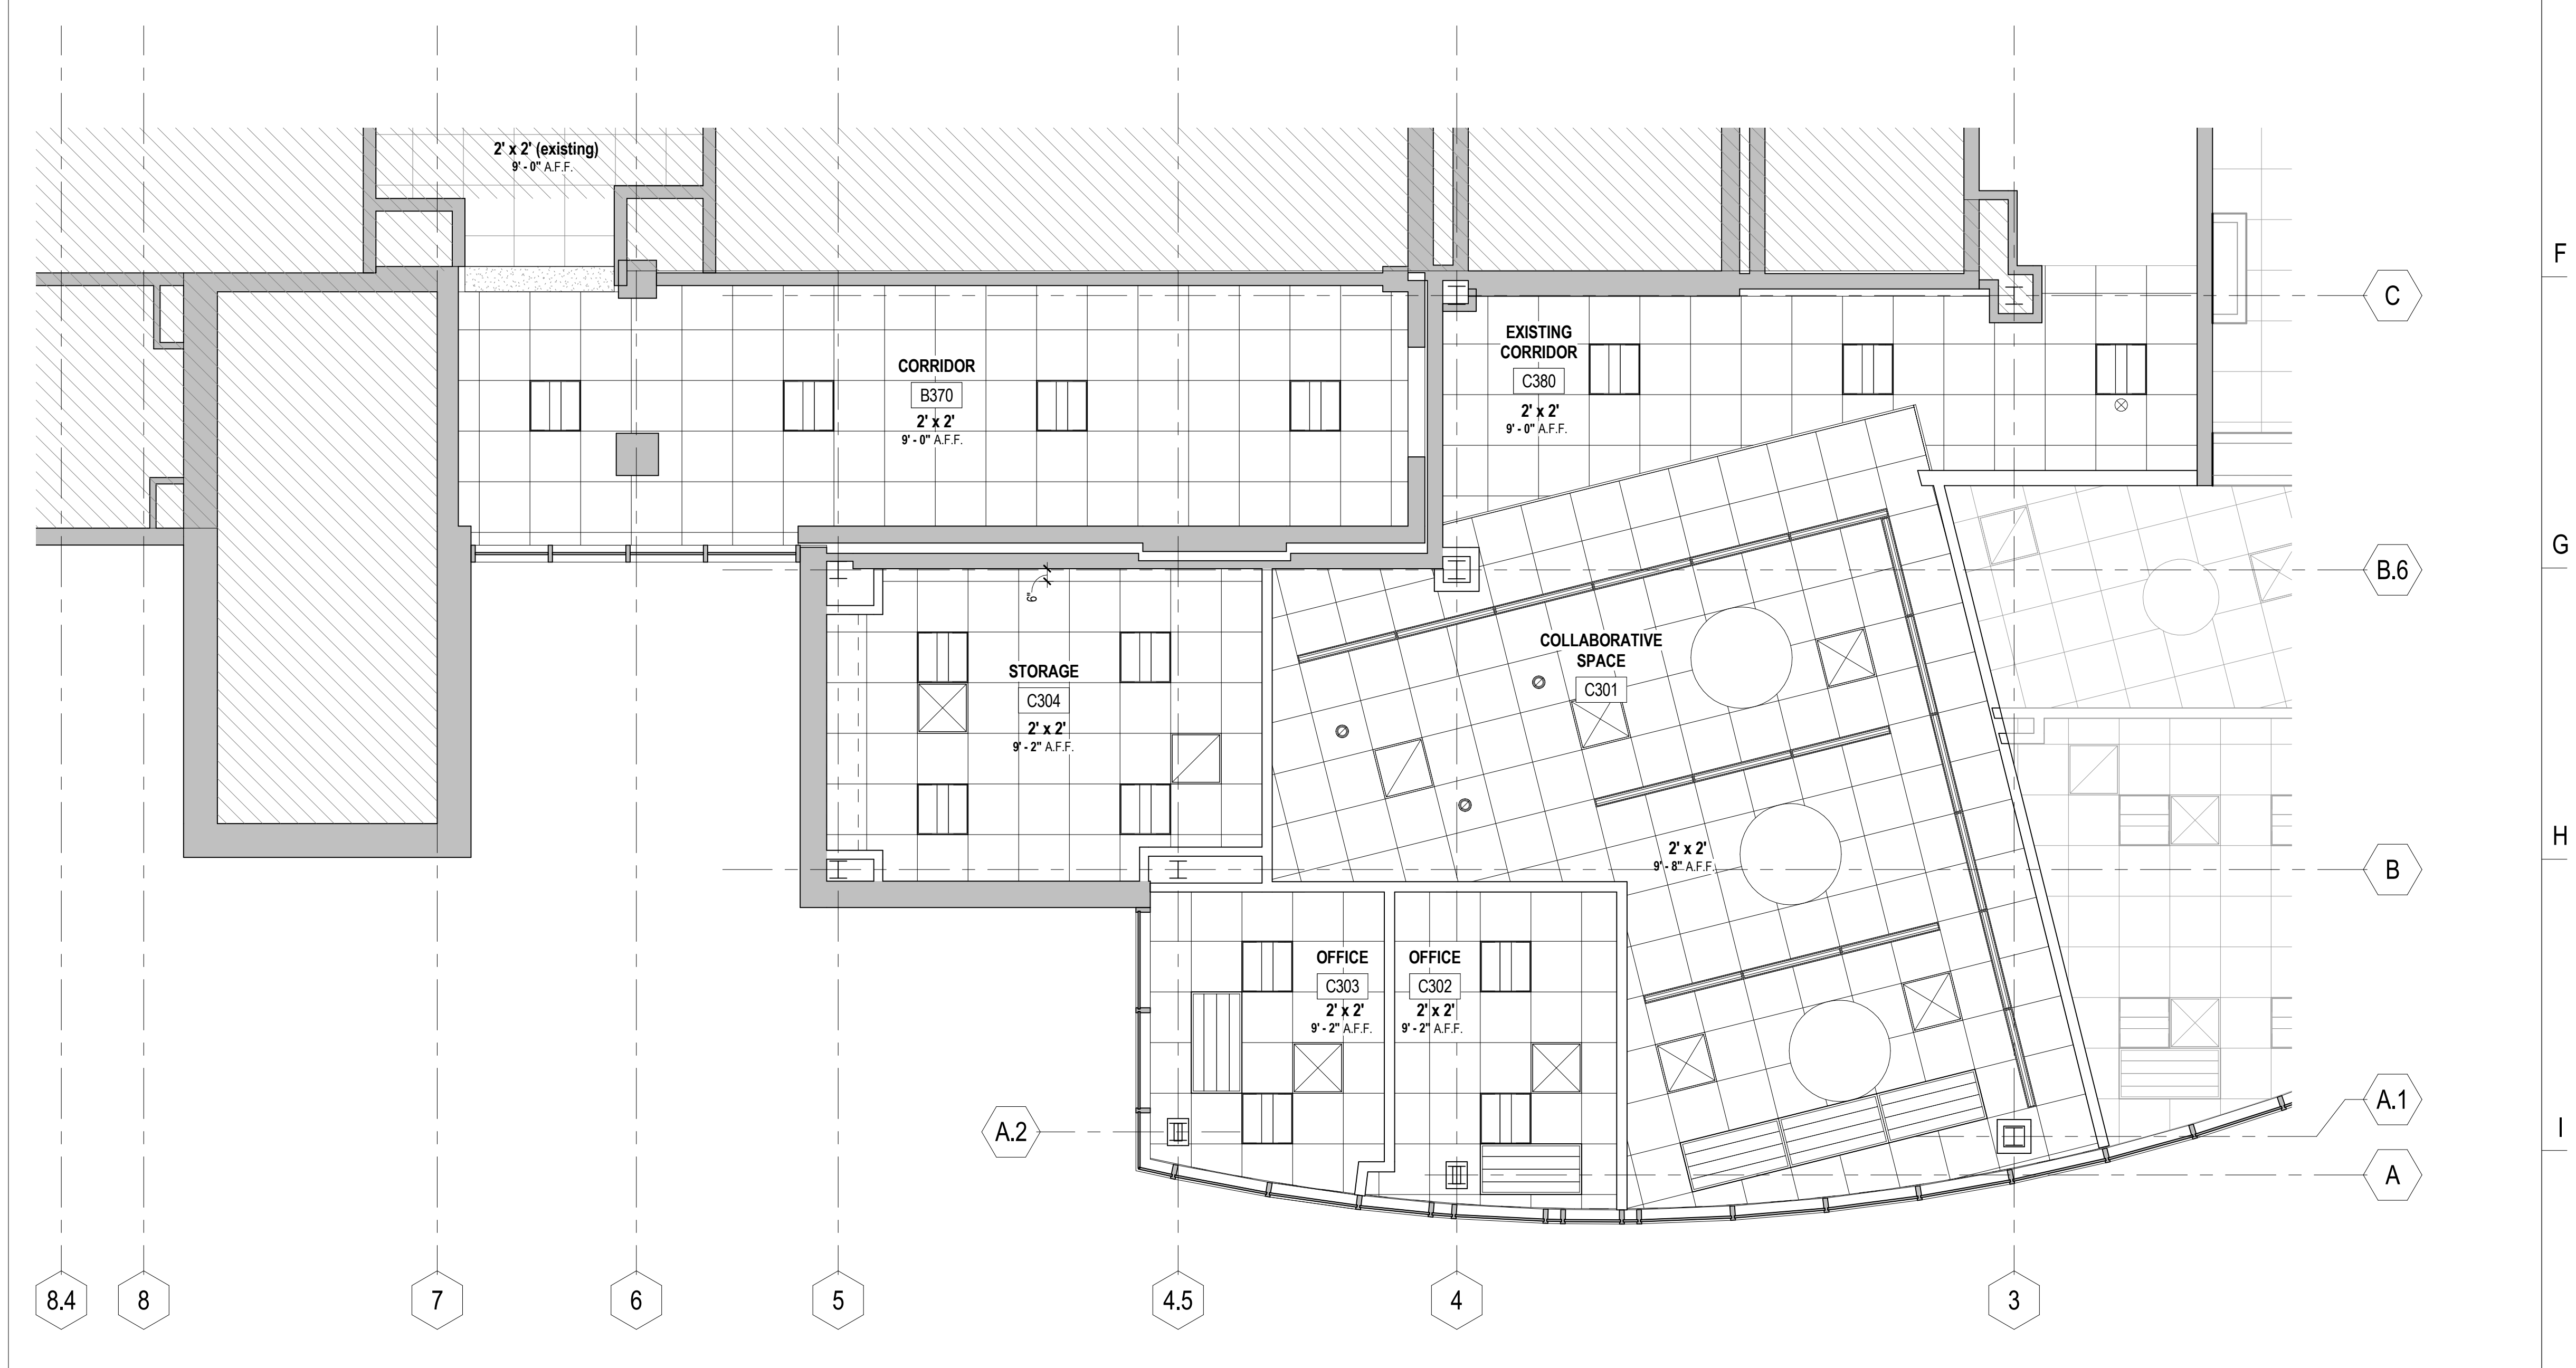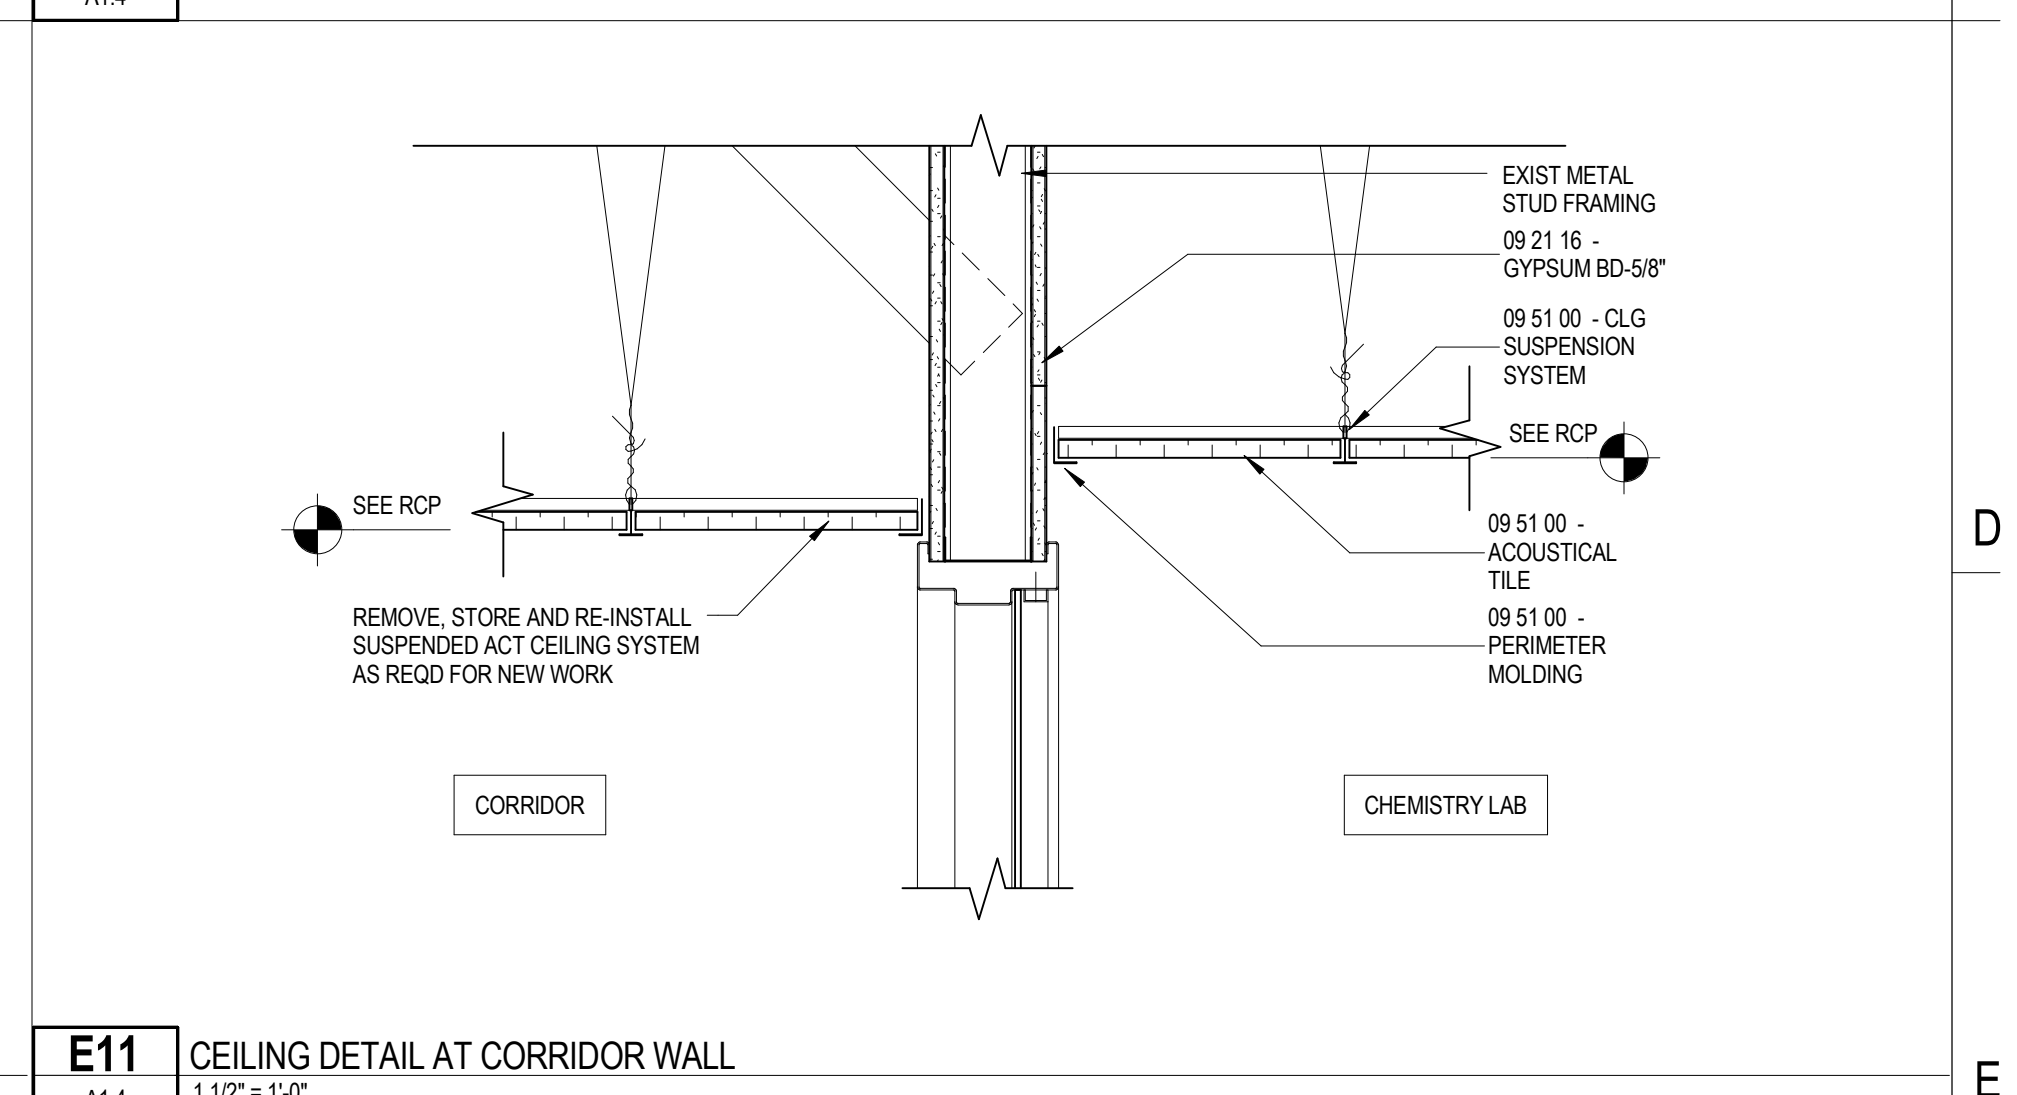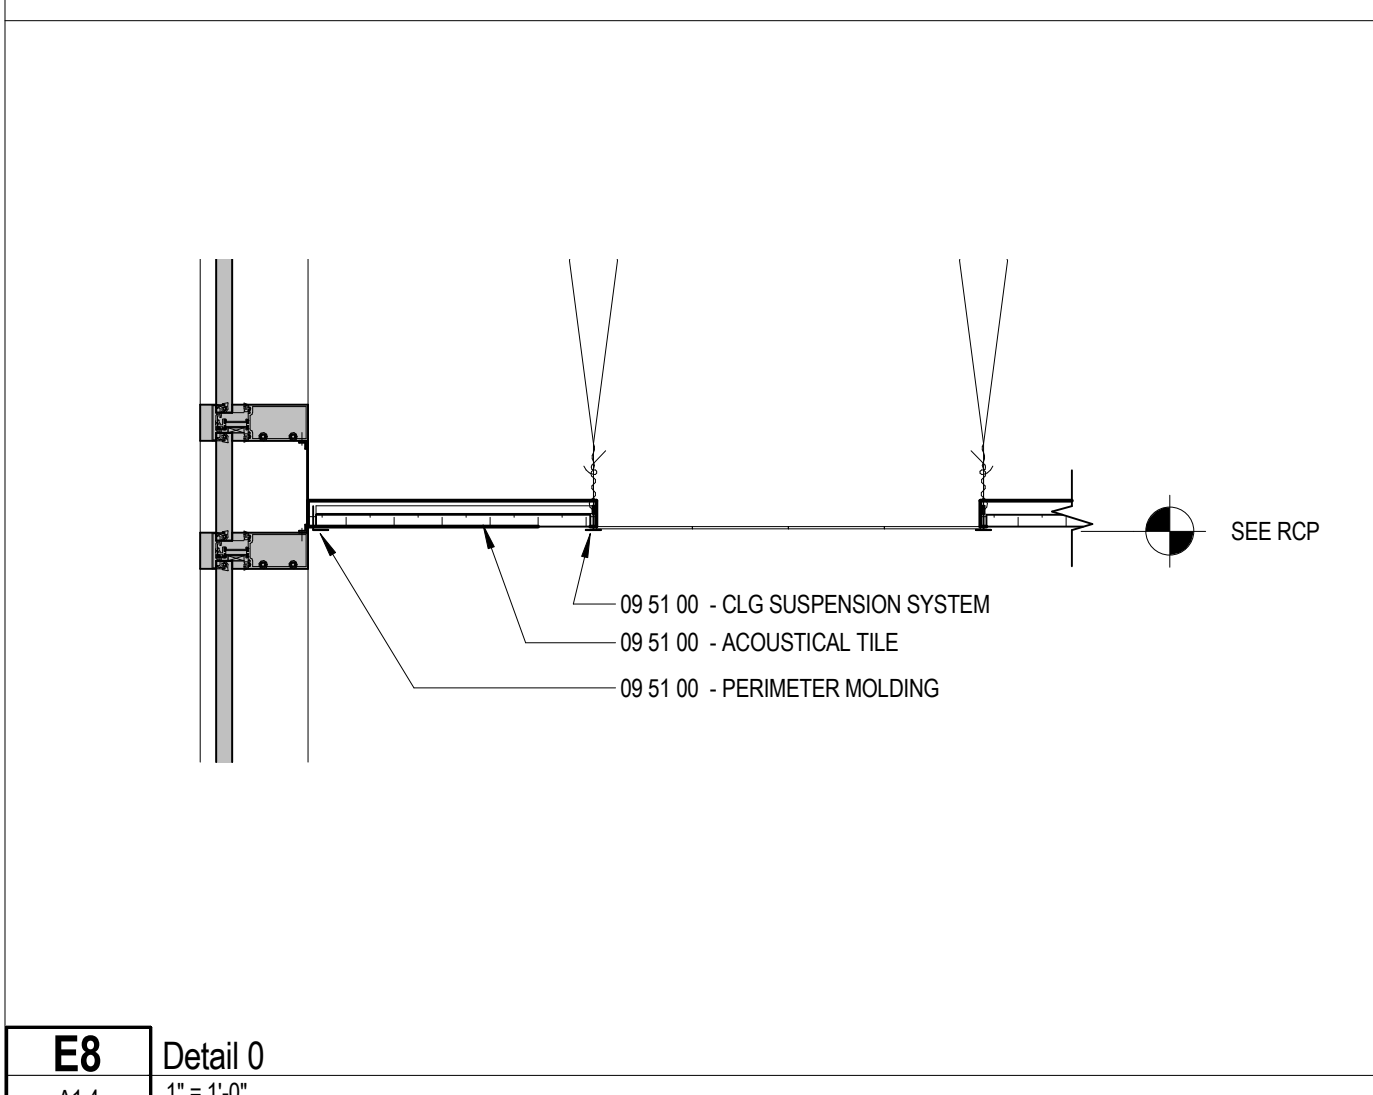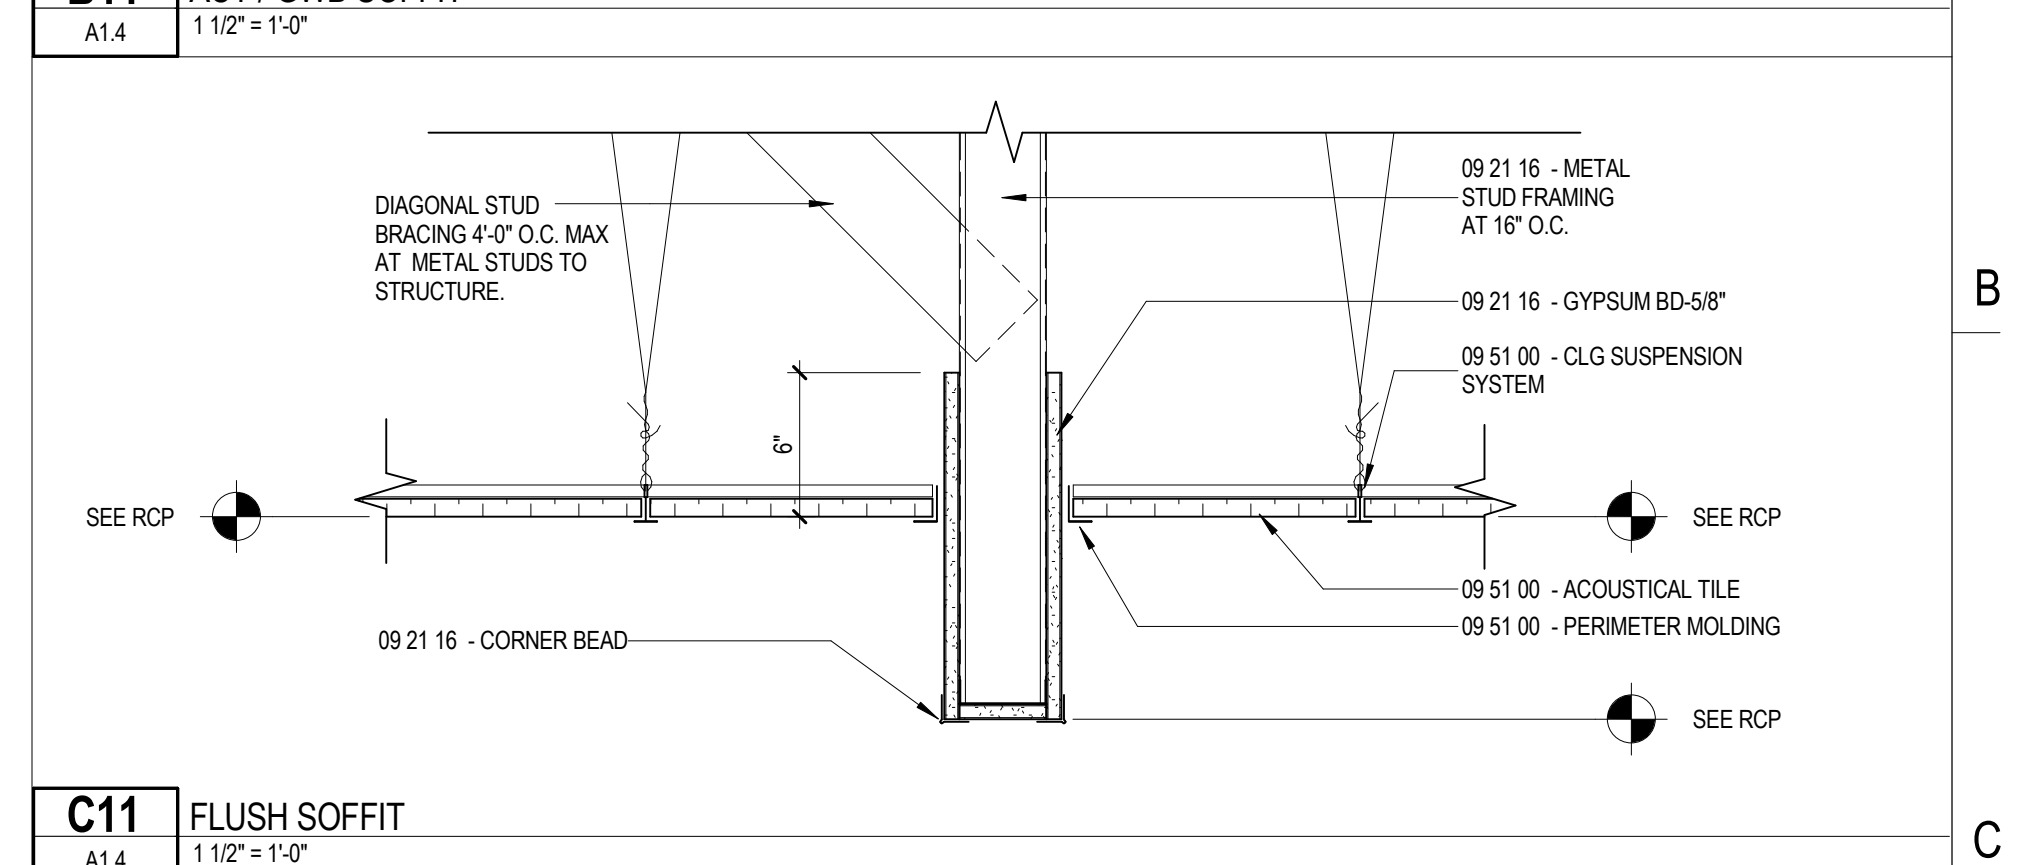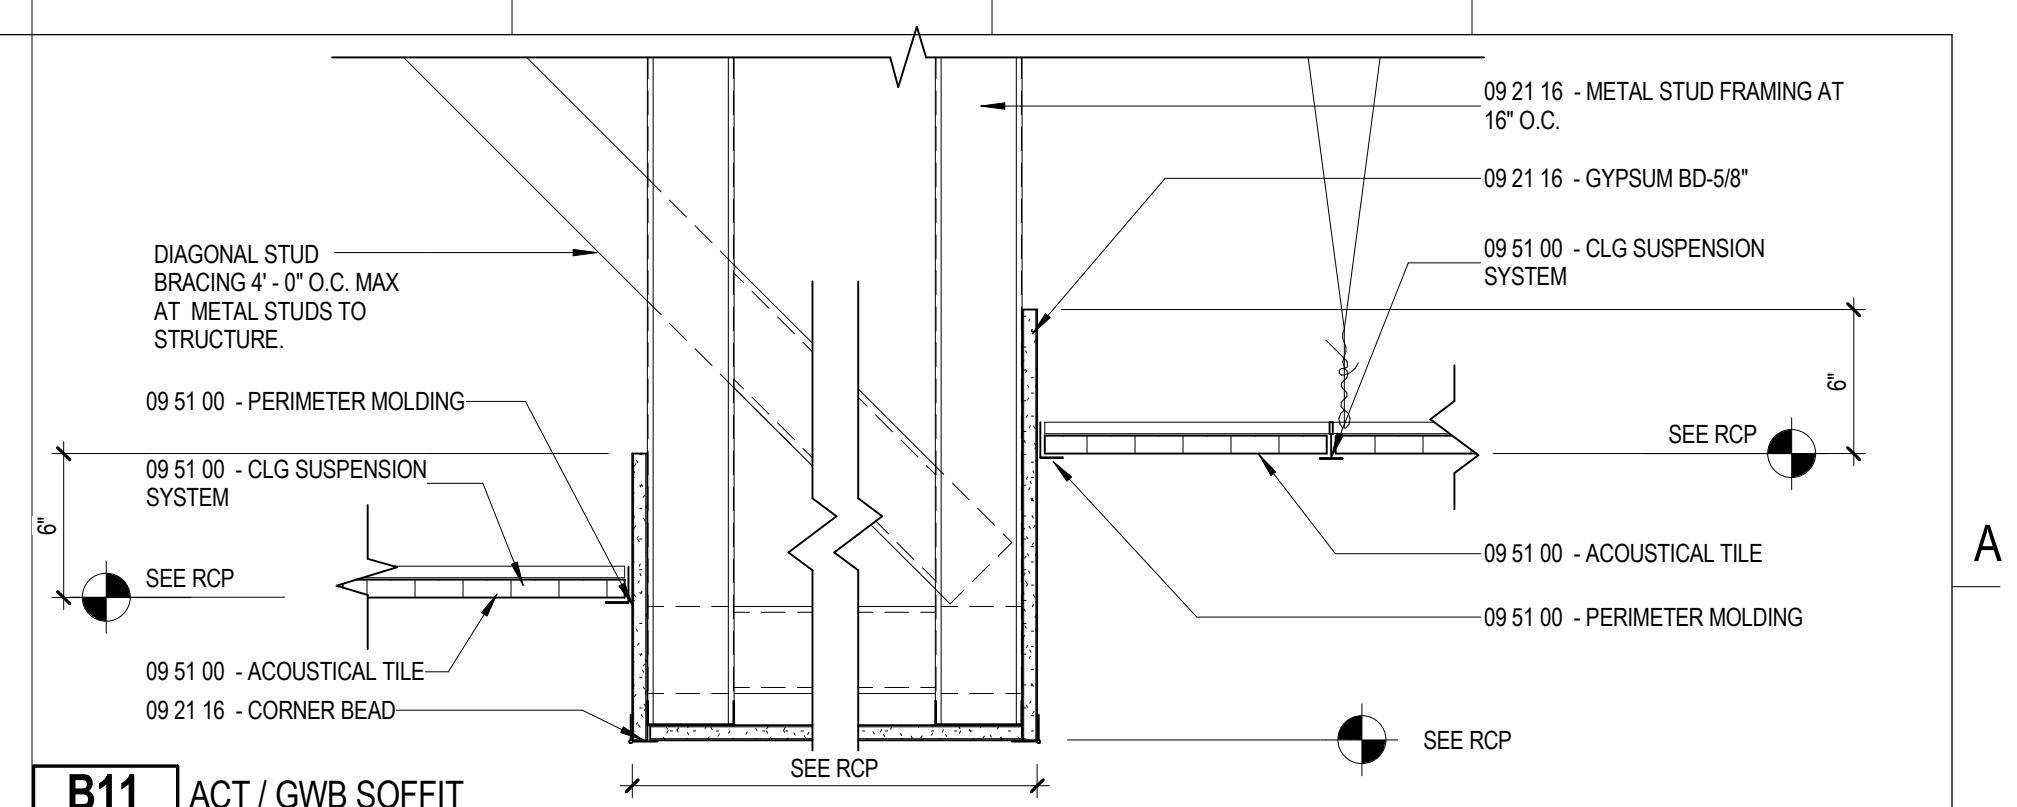

J5 LEVEL 3 - ALTERNATE NO. 1
 A1.4 1/4" = 1'-0"

7/22/2015 2:49:20 AM C:\Projects\14049\USM\C300 Chem Lab_Corridor Revit 2015.mcd\meham.rvt