


160 Veranda Street  
 Portland, Maine 04103  
 T: 207.231.2349  
 F: 207.231.2346  
 Web: www.allied-eng.com


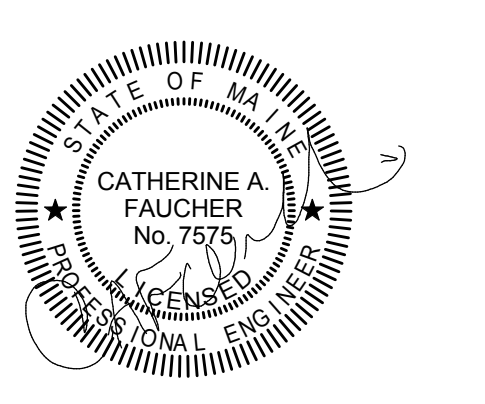


UNIVERSITY OF SOUTHERN MAINE

**SCIENCE BUILDING  
 C300 CHEMISTRY LAB**

96 Falmouth Street, Portland, Maine  
 04101

NO.	DESCRIPTION	DATE

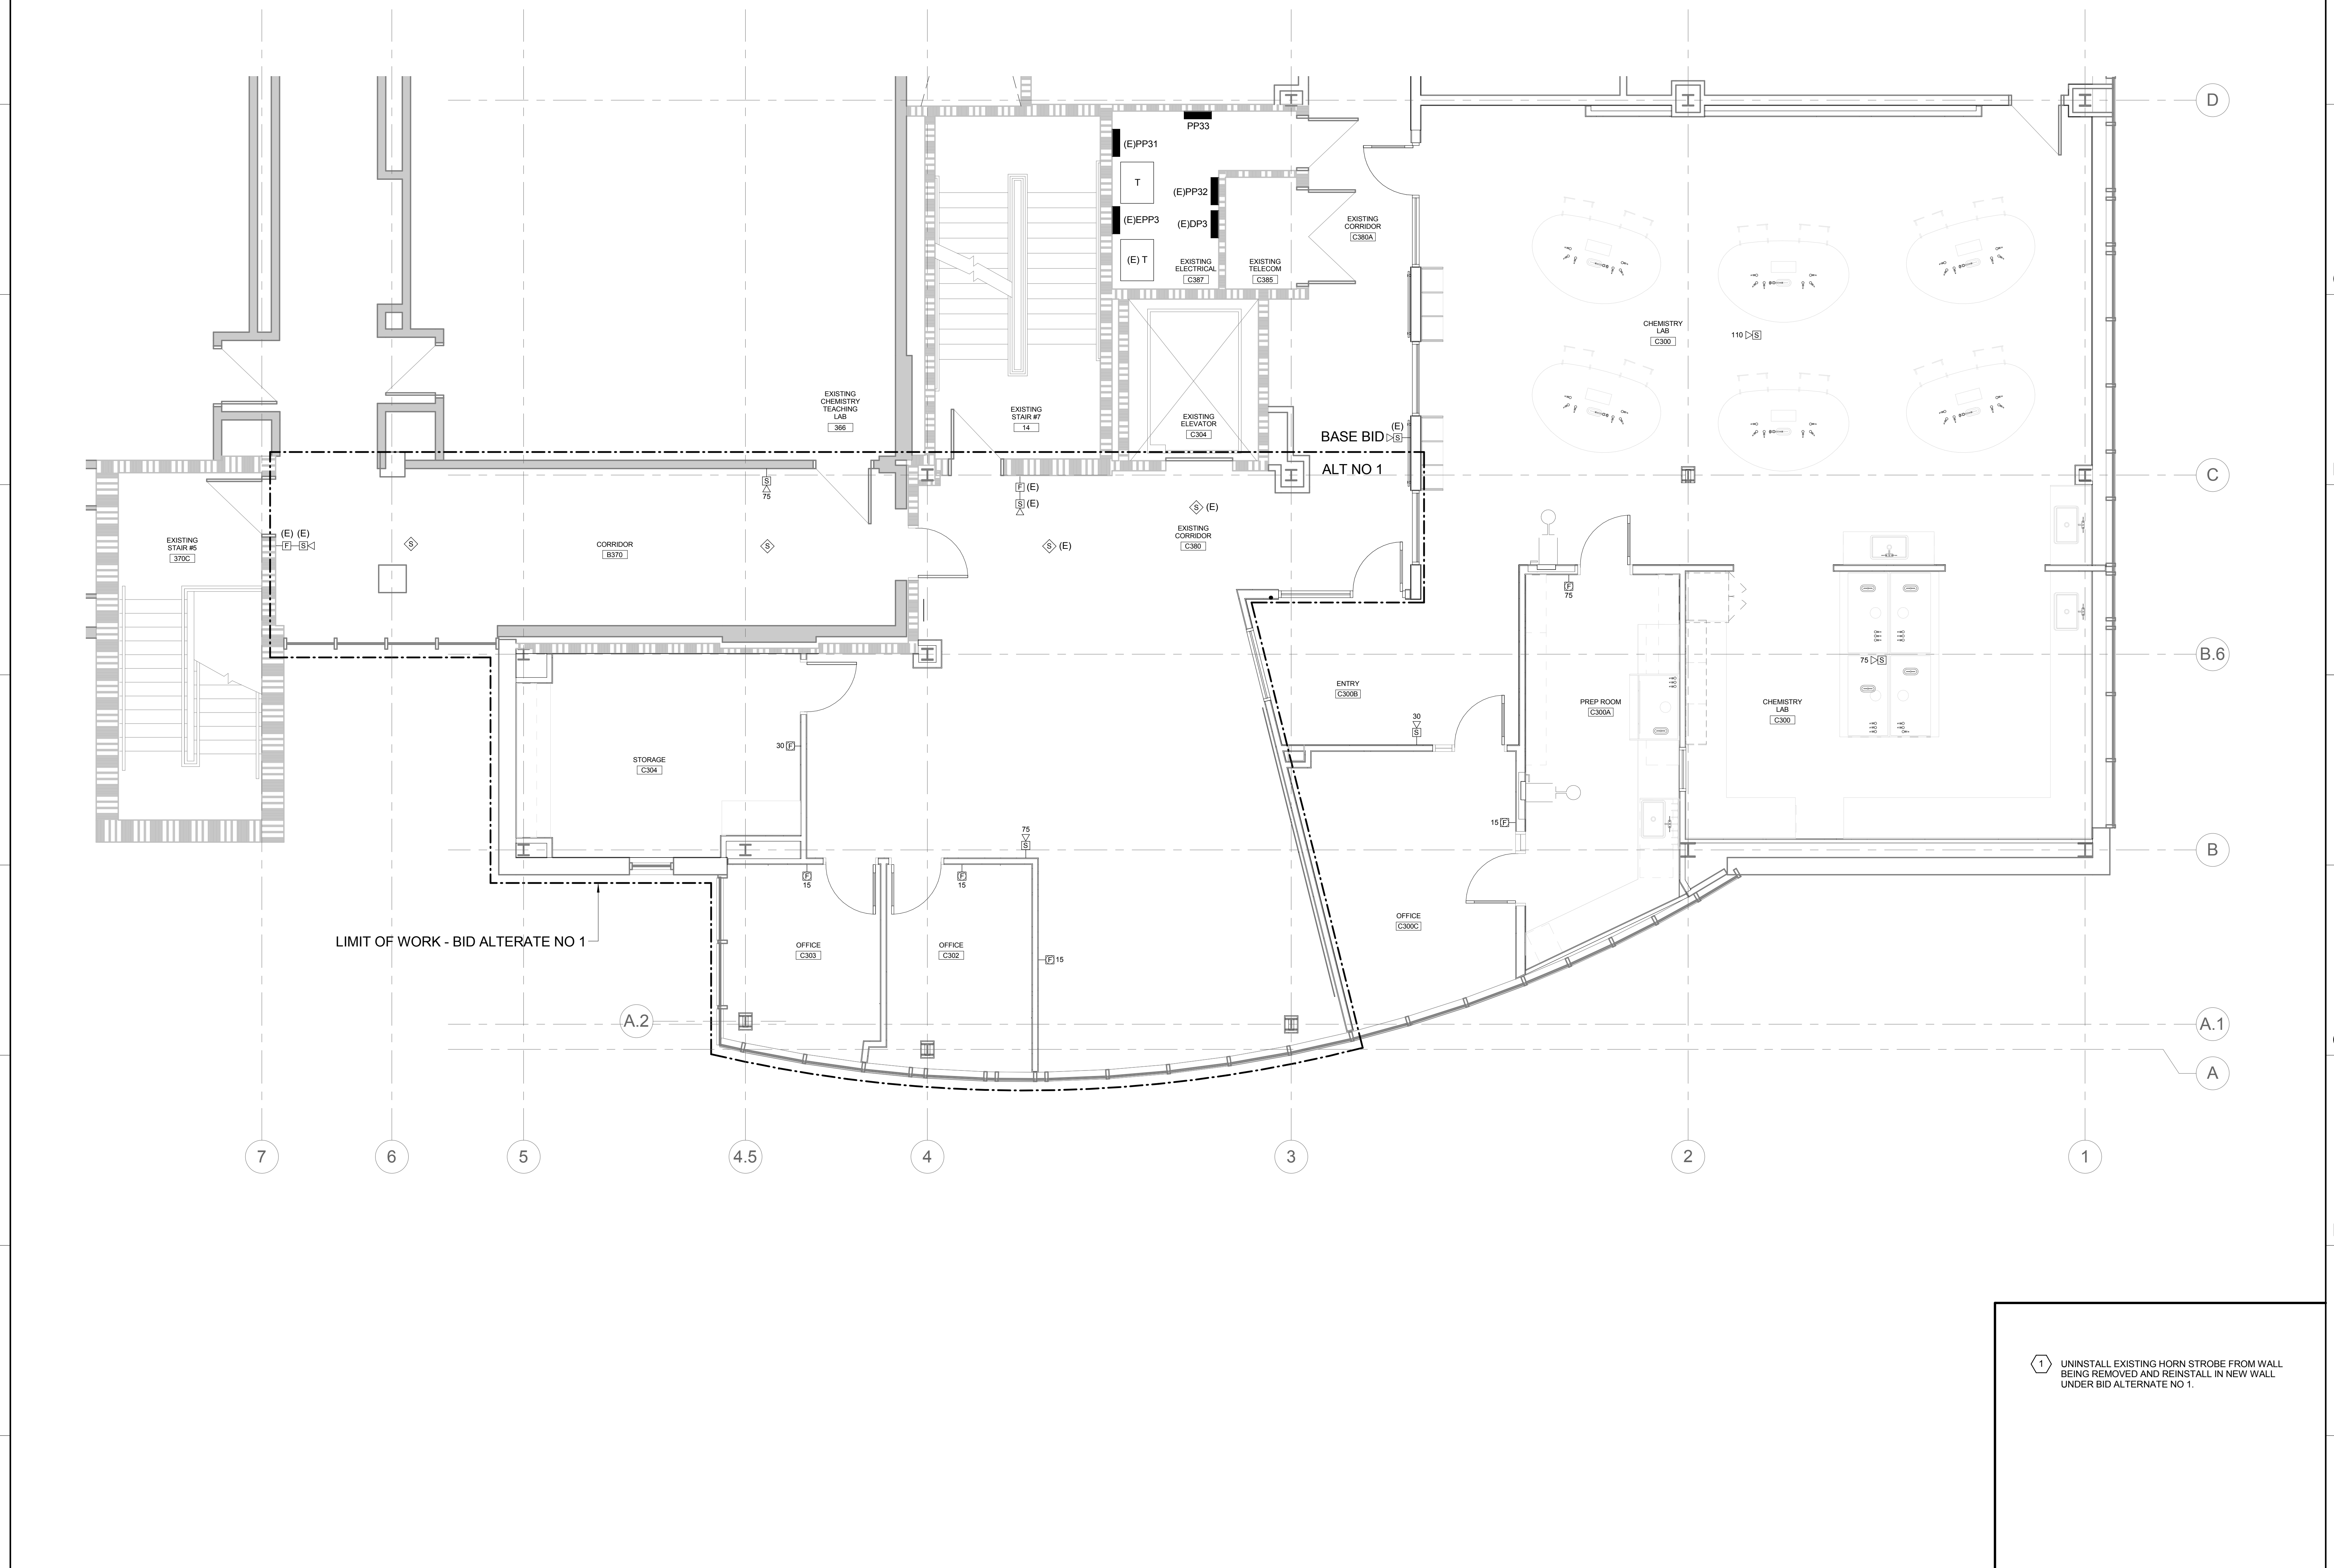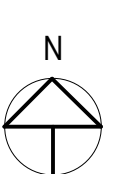

UNINSTALL EXISTING HORN STROBE FROM WALL BEING REMOVED AND REINSTALL IN NEW WALL UNDER BID ALTERNATE NO 1.

A1	FIRE ALARM SYSTEM - THIRD FLOOR PART PLAN	A13	KEY NOTES
1	2	3	4
5	6	7	8
9	10	11	12
13	14	15	16

CONTENT: FIRE ALARM PLAN	
DRAWN BY:	Author
PROJECT NO.:	15049
DATE:	JULY 21, 2015
REVISED:	
SCALE:	AS NOTED
<b>FA1.1</b>	
Project Phase PERMIT SET	
COPYRIGHT © 2015 BY LAVALLEE BRENSINGER PROFESSIONAL ASSOCIATION. ALL RIGHTS RESERVED. NO REPRODUCTION WITHOUT PERMISSION.	

7/20/2015 3:21:44 PM N:\Projects\2015\15049 - USM Science Building C300 Chemistry Lab - redesign from 4/07/2010 Drawing File\15049-FA1