


160 Veranda Street
Portland, Maine 04103
T: 207.221.2240
F: 207.221.2266
Web: www.allied-eng.com

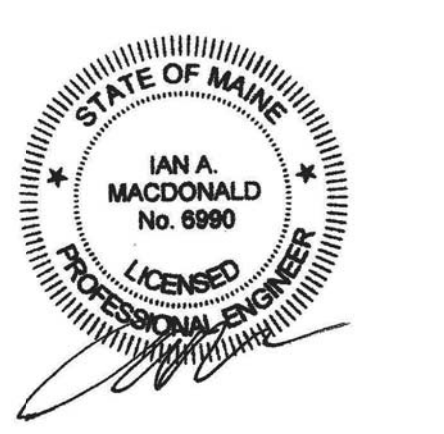


UNIVERSITY OF SOUTHERN MAINE

SCIENCE BUILDING C300 CHEMISTRY LAB

96 Falmouth Street, Portland, Maine
04101

NO.	DESCRIPTION	DATE

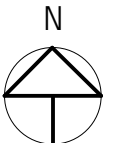


CONTENT:
FIRE PROTECTION
PART PLAN - THIRD FLOOR
SPRINKLER

DRAWN BY:	SGH
PROJECT NO.:	15049
DATE:	JULY 21, 2015
REVISED:	
SCALE:	AS NOTED

F1.2

Project Phase
PERMIT SET

COPYRIGHT © 2015 BY LAVALLEE|BRENSINGER PROFESSIONAL ASSOCIATION. ALL RIGHTS RESERVED. NO REPRODUCTION WITHOUT PERMISSION.

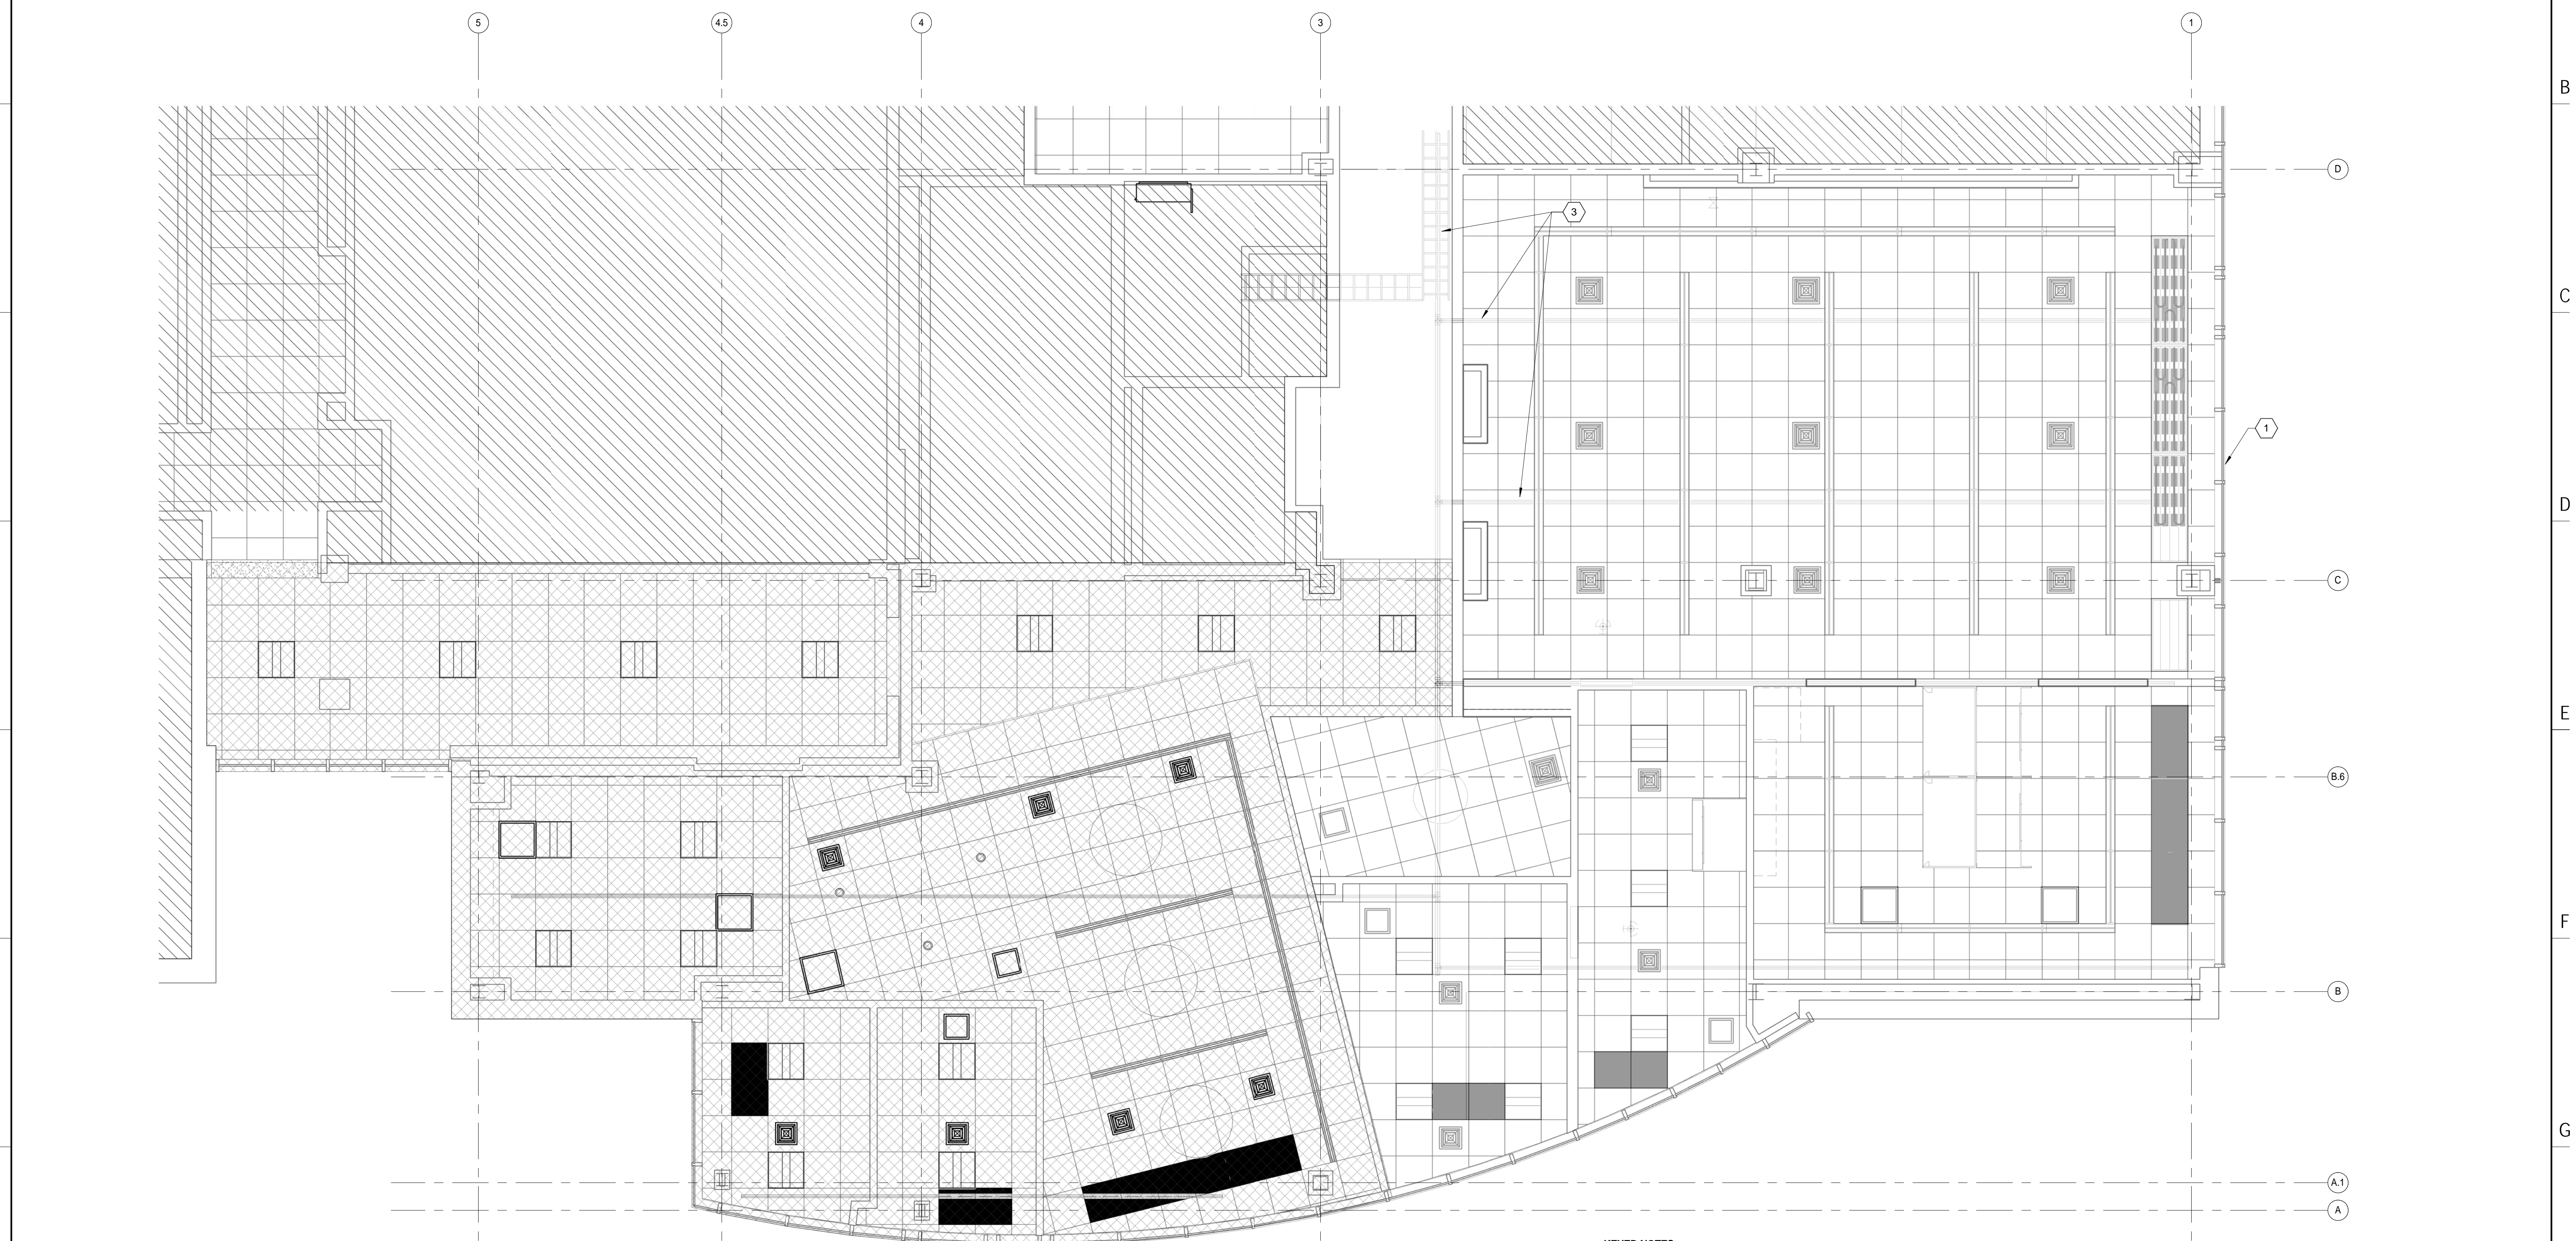

- KEYED NOTES:**
- 1 BASE BID
 - 2 ALTERNATE #1
 - 3 REUSE (E) SPRINKLER PIPING, TYP. REMOVE UPRIGHT HEADS AND REPLACE WITH PENDANT HEADS. SEE SPEC SECTION 211000.

7/20/2015 4:30:06 PM N:\Projects\2015\15049 - USM Science Building C300 Chemistry Lab - redesign from 14075000 Drawing Files\15049.rvt