



HARRIMAN

AUBURN PORTLAND MANCHESTER

UNIVERSITY OF SOUTHERN MAINE DEPARTMENT REORGANIZATION PROJECT 2015-011

PORTLAND, MAINE

Harriman Project No. 15457

Key Plan

Proj North




True North



Issues and Revisions

Mark	Date	Description
07-23-15	100% REVIEW	
08-03-15	OWNER REVIEW	
08-10-15	ISSUED FOR BID	

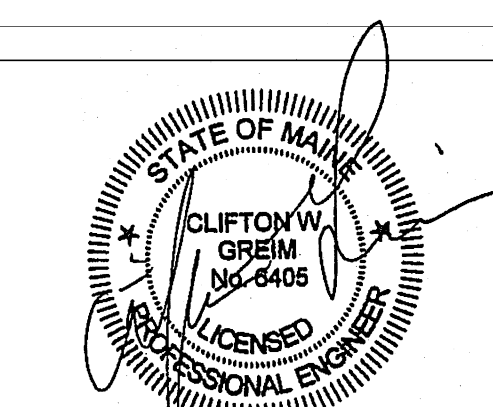


Drawing Scales	0	2'	4'	6'
1/8" = 1'-0"				
1/4" = 1'-0"				

PA / PE: CG	© 2015
Drawn By: MAM	Harriman Associates

ALTERNATE 2 PLUMBING PLAN - LUTHER BONNEY

P10.1

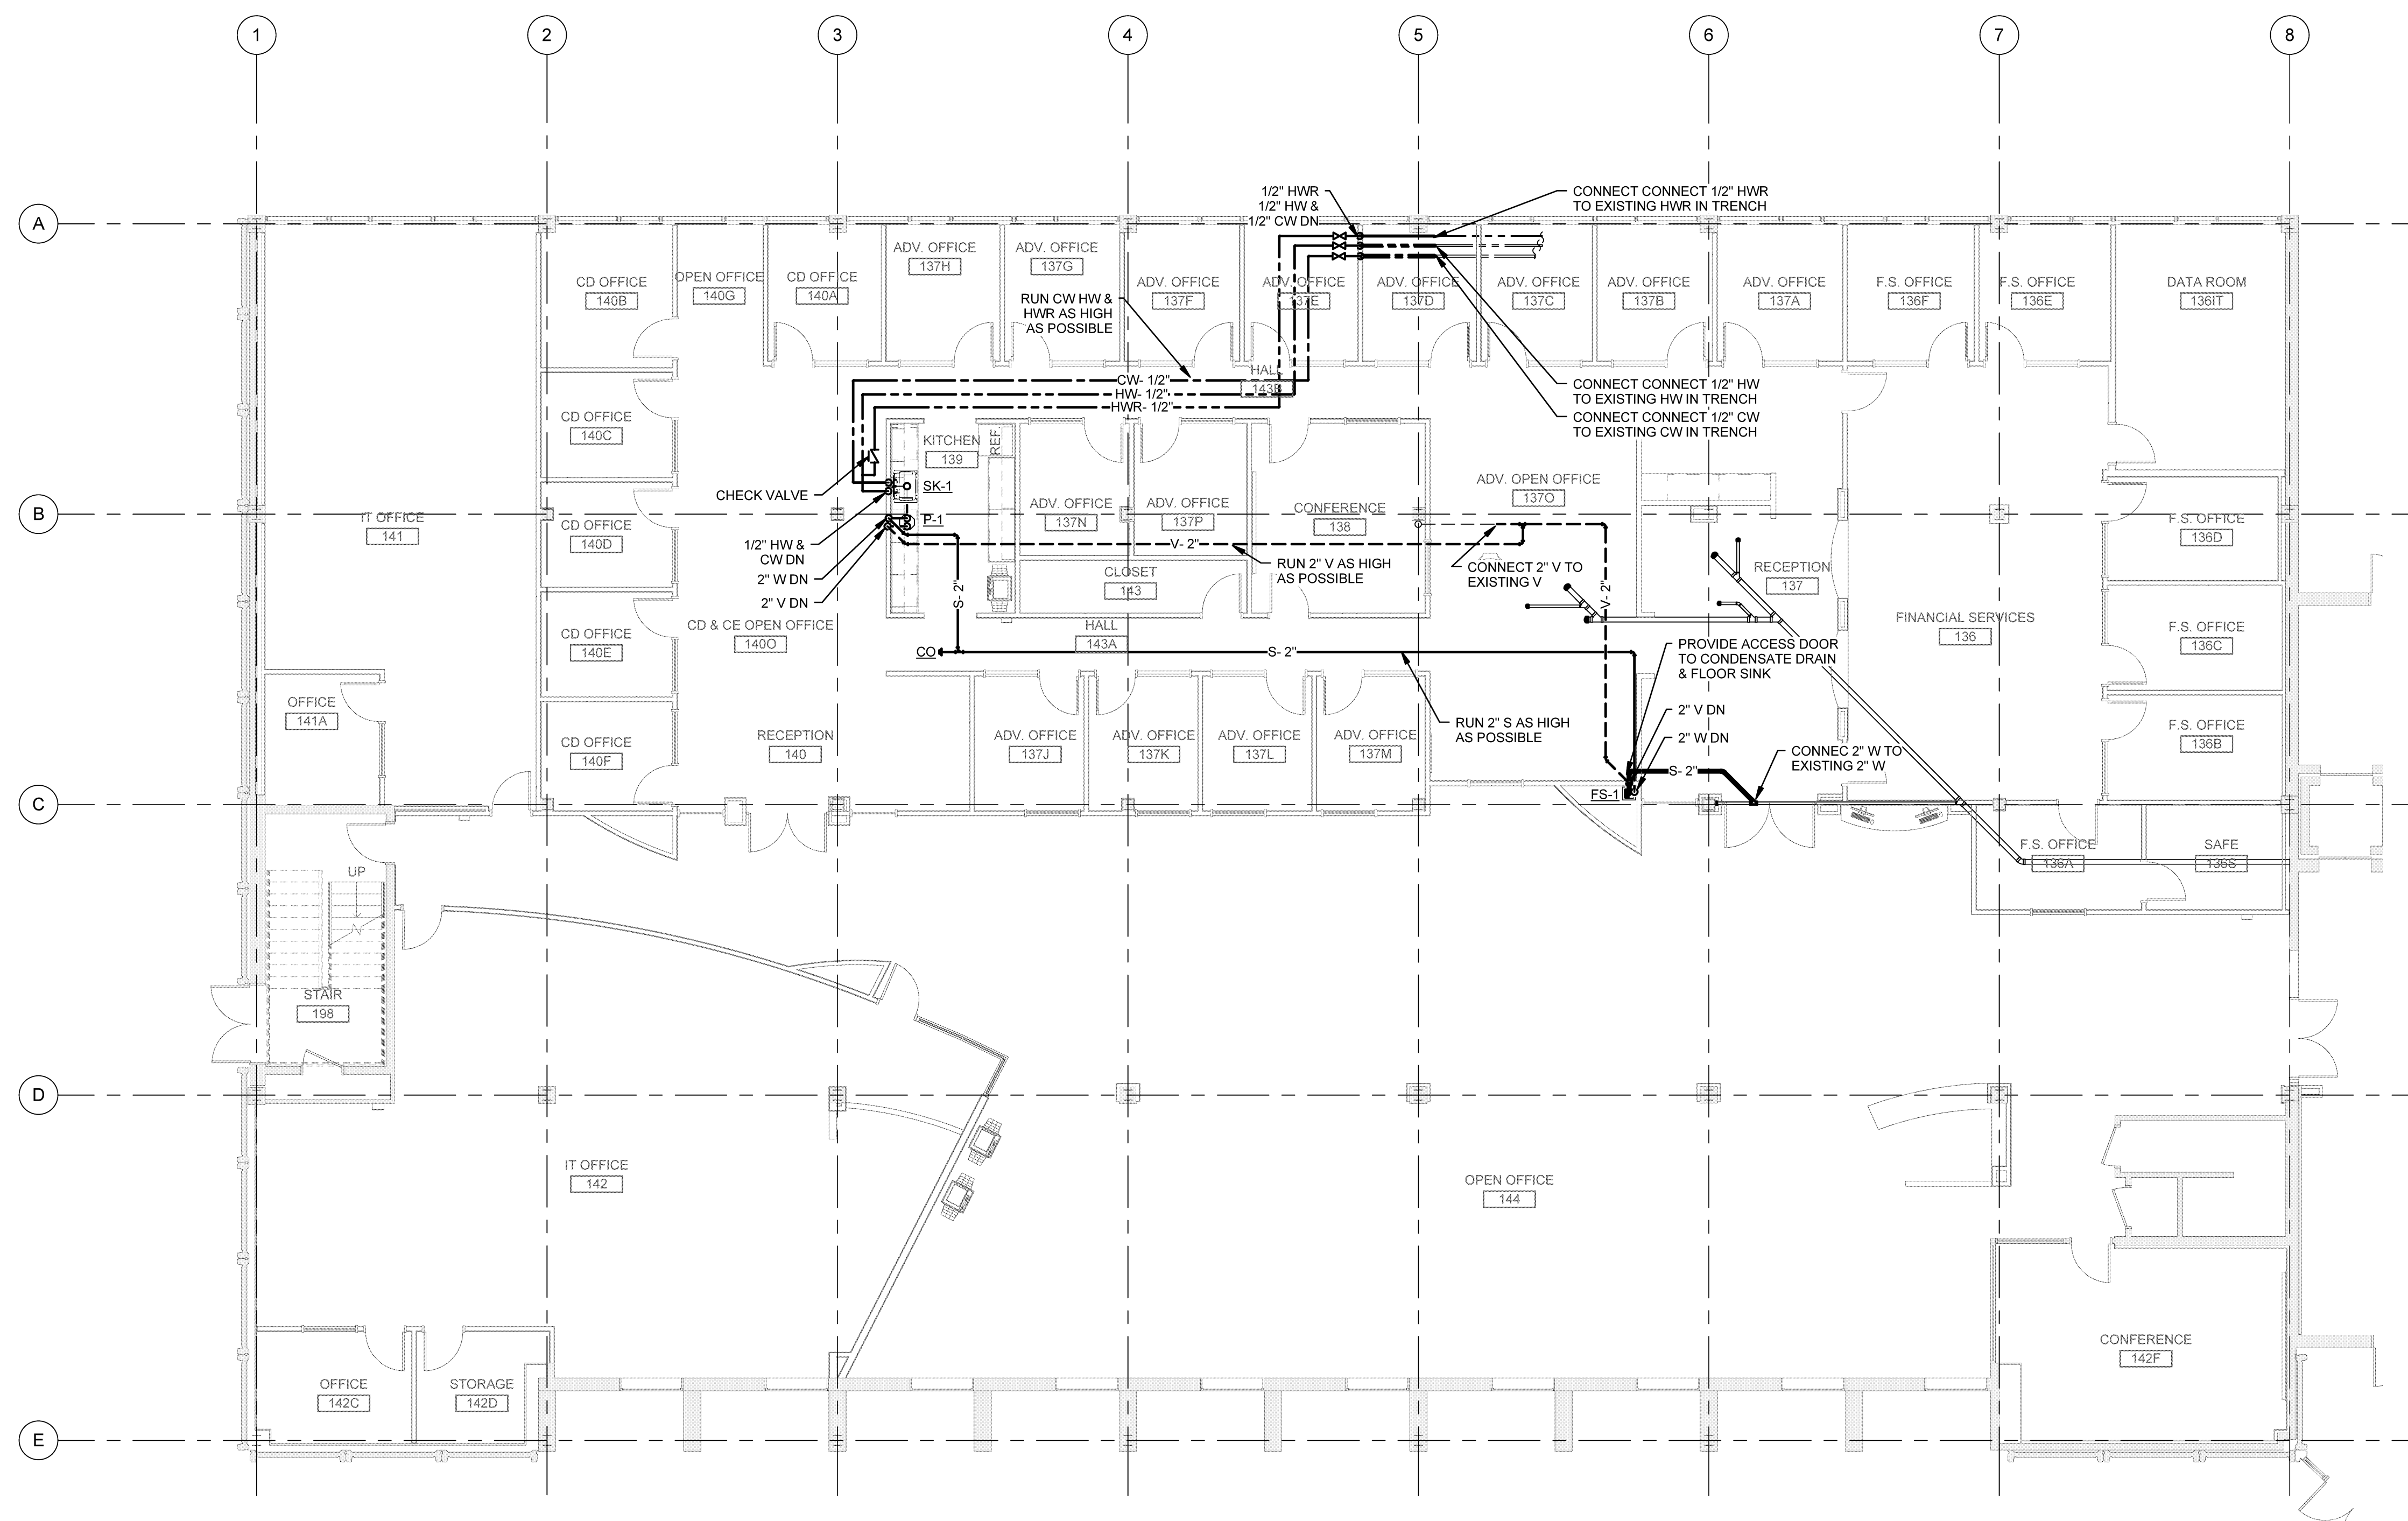

1 ALTERNATE 2A PLUMBING PLAN SCALE: 1/8" = 1'-0"