

HARRIMAN

AUBURN PORTLAND MANCHESTER

UNIVERSITY OF SOUTHERN MAINE DEPARTMENT REORGANIZATION PROJECT 2015-011

PORTLAND, MAINE

Harriman Project No. 15457

Key Plan

Proj North




True North



Issues and Revisions

Mark	Date	Description
1	09-25-15	ISSUED FOR PERMIT

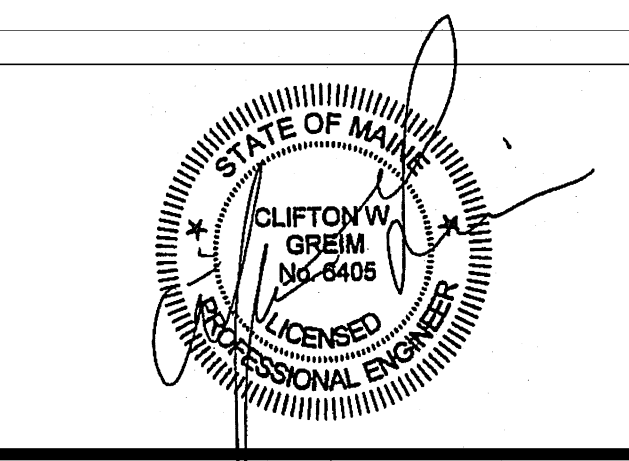


Drawing Scales	0	4'	8'	12'
As indicated				

Drawing Scales	0	2'	4'	6'
As indicated				

PA / PE: CG	© 2015
Drawn By: MAM	Harriman Associates


PLUMBING PART PLANS - LUTHER BONNEY

P10.0

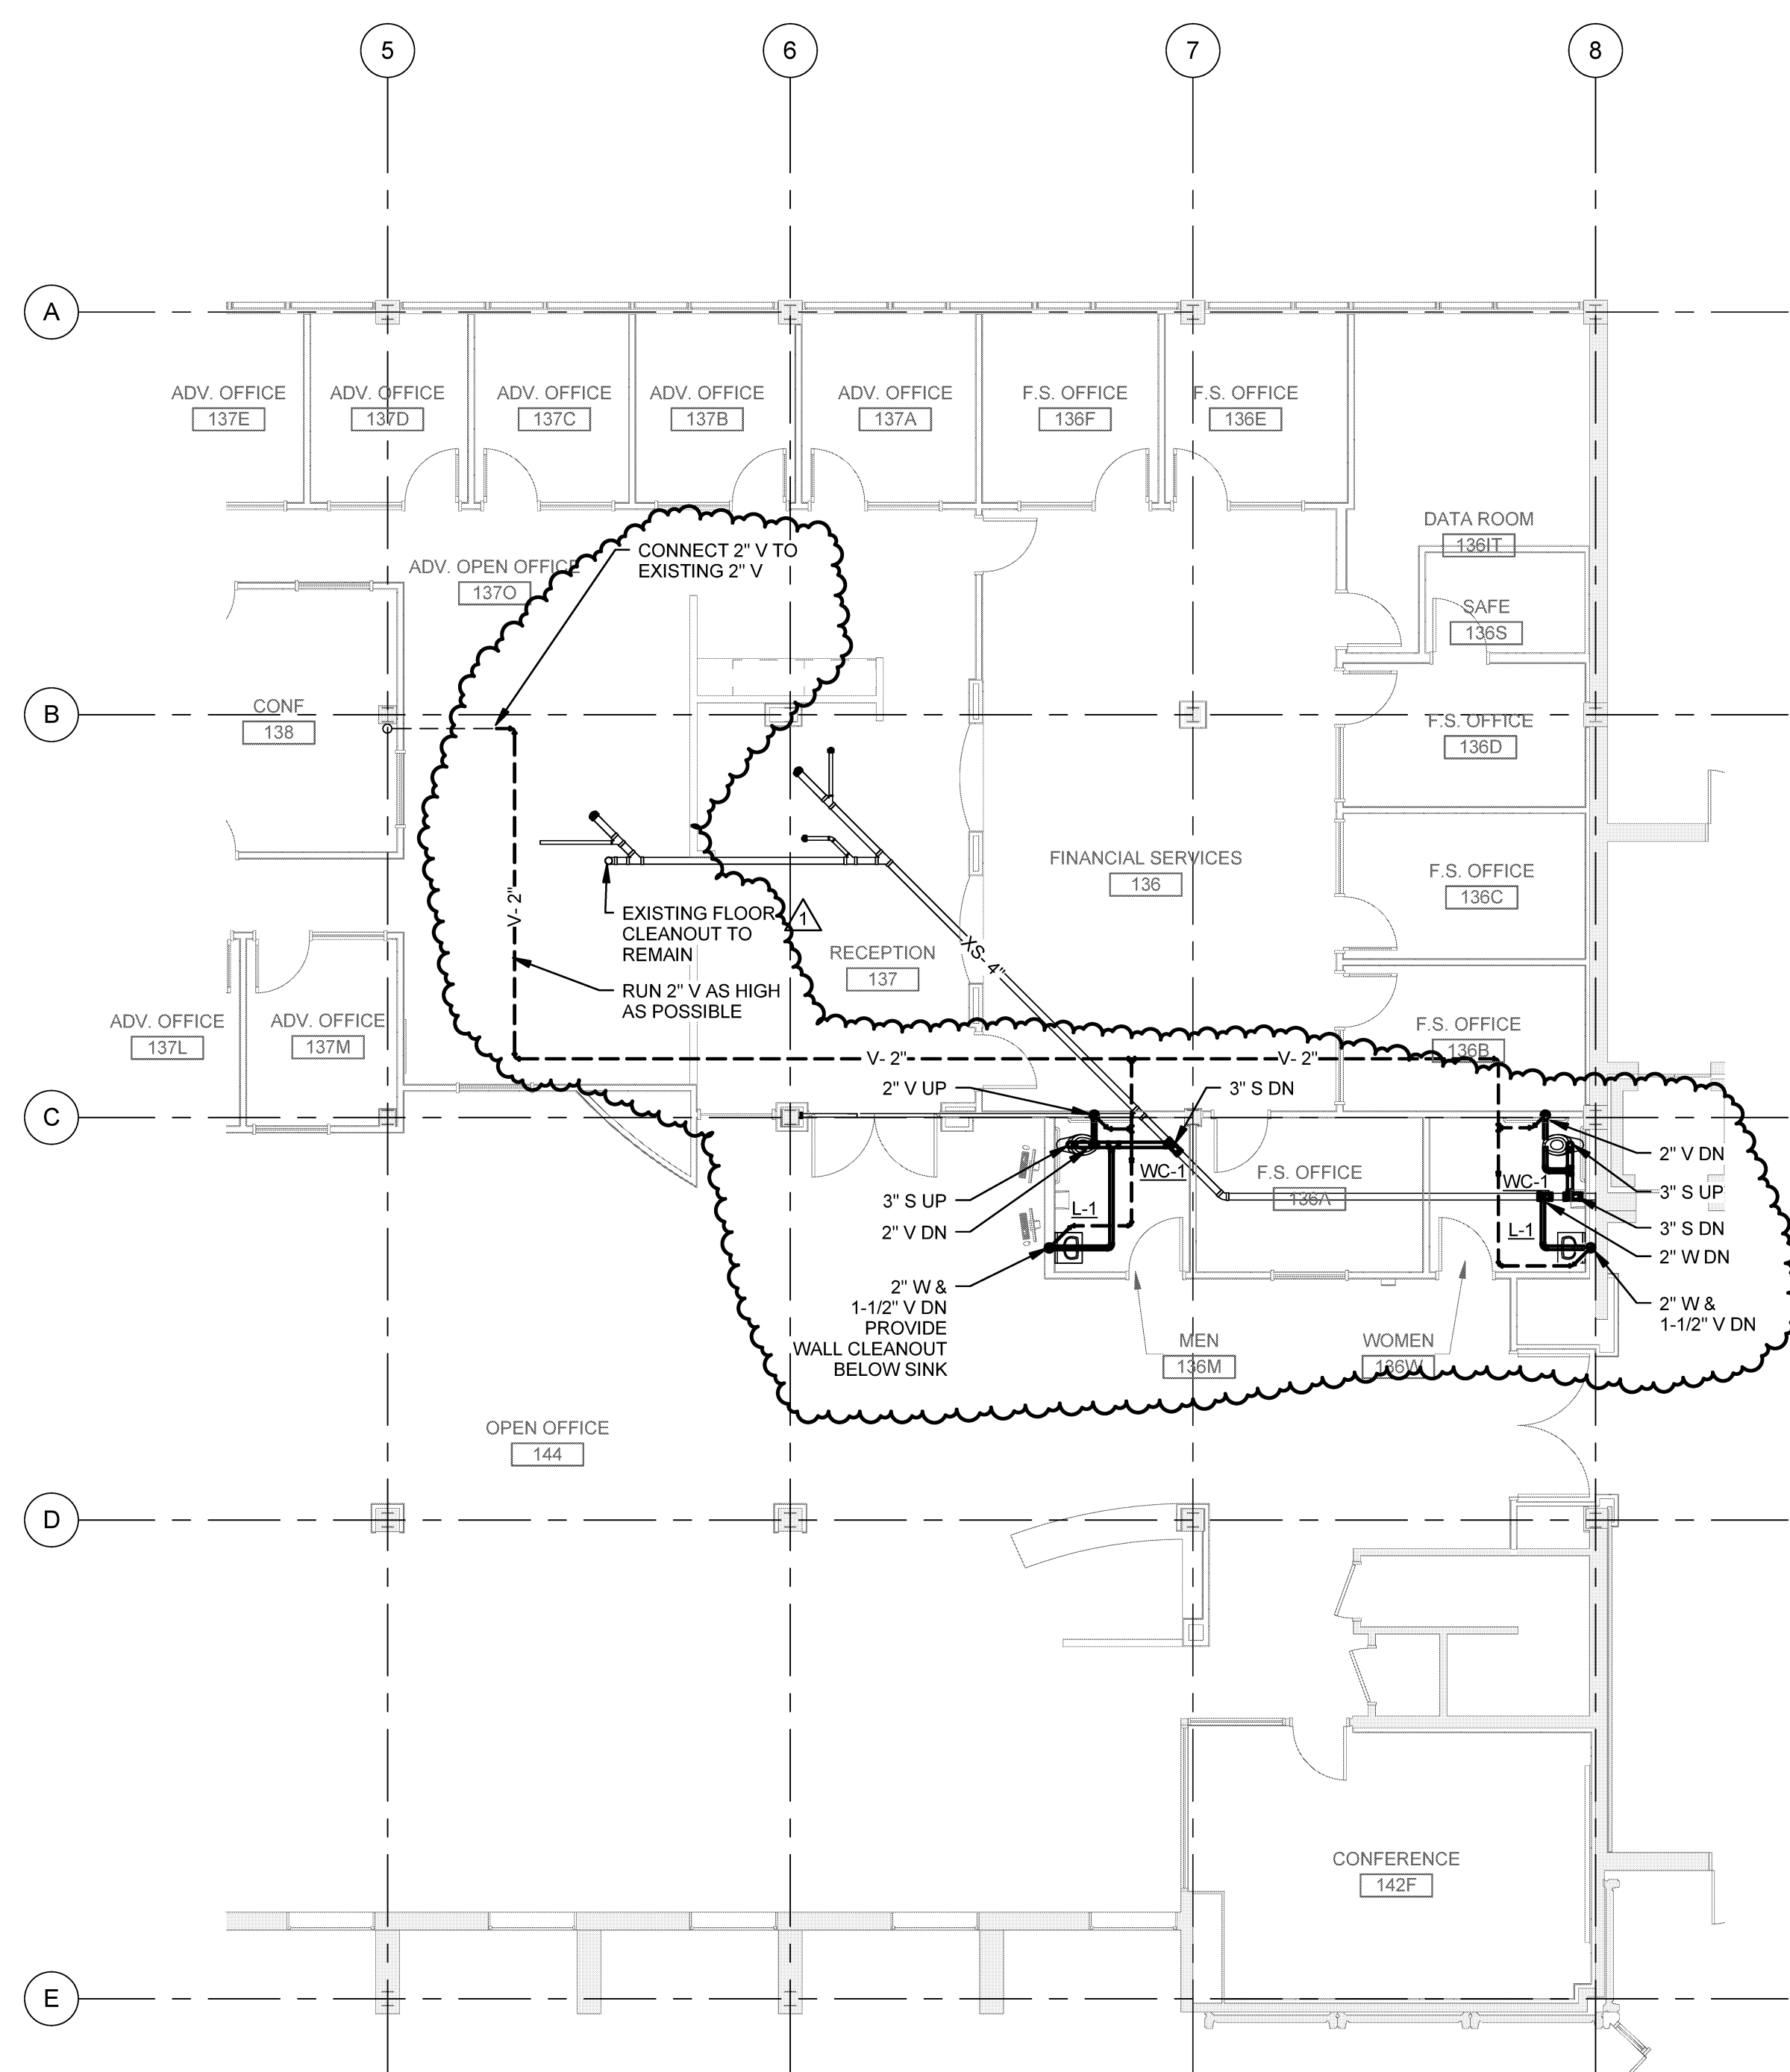

1 DRAINAGE PLAN

SCALE: 1/8" = 1'-0"

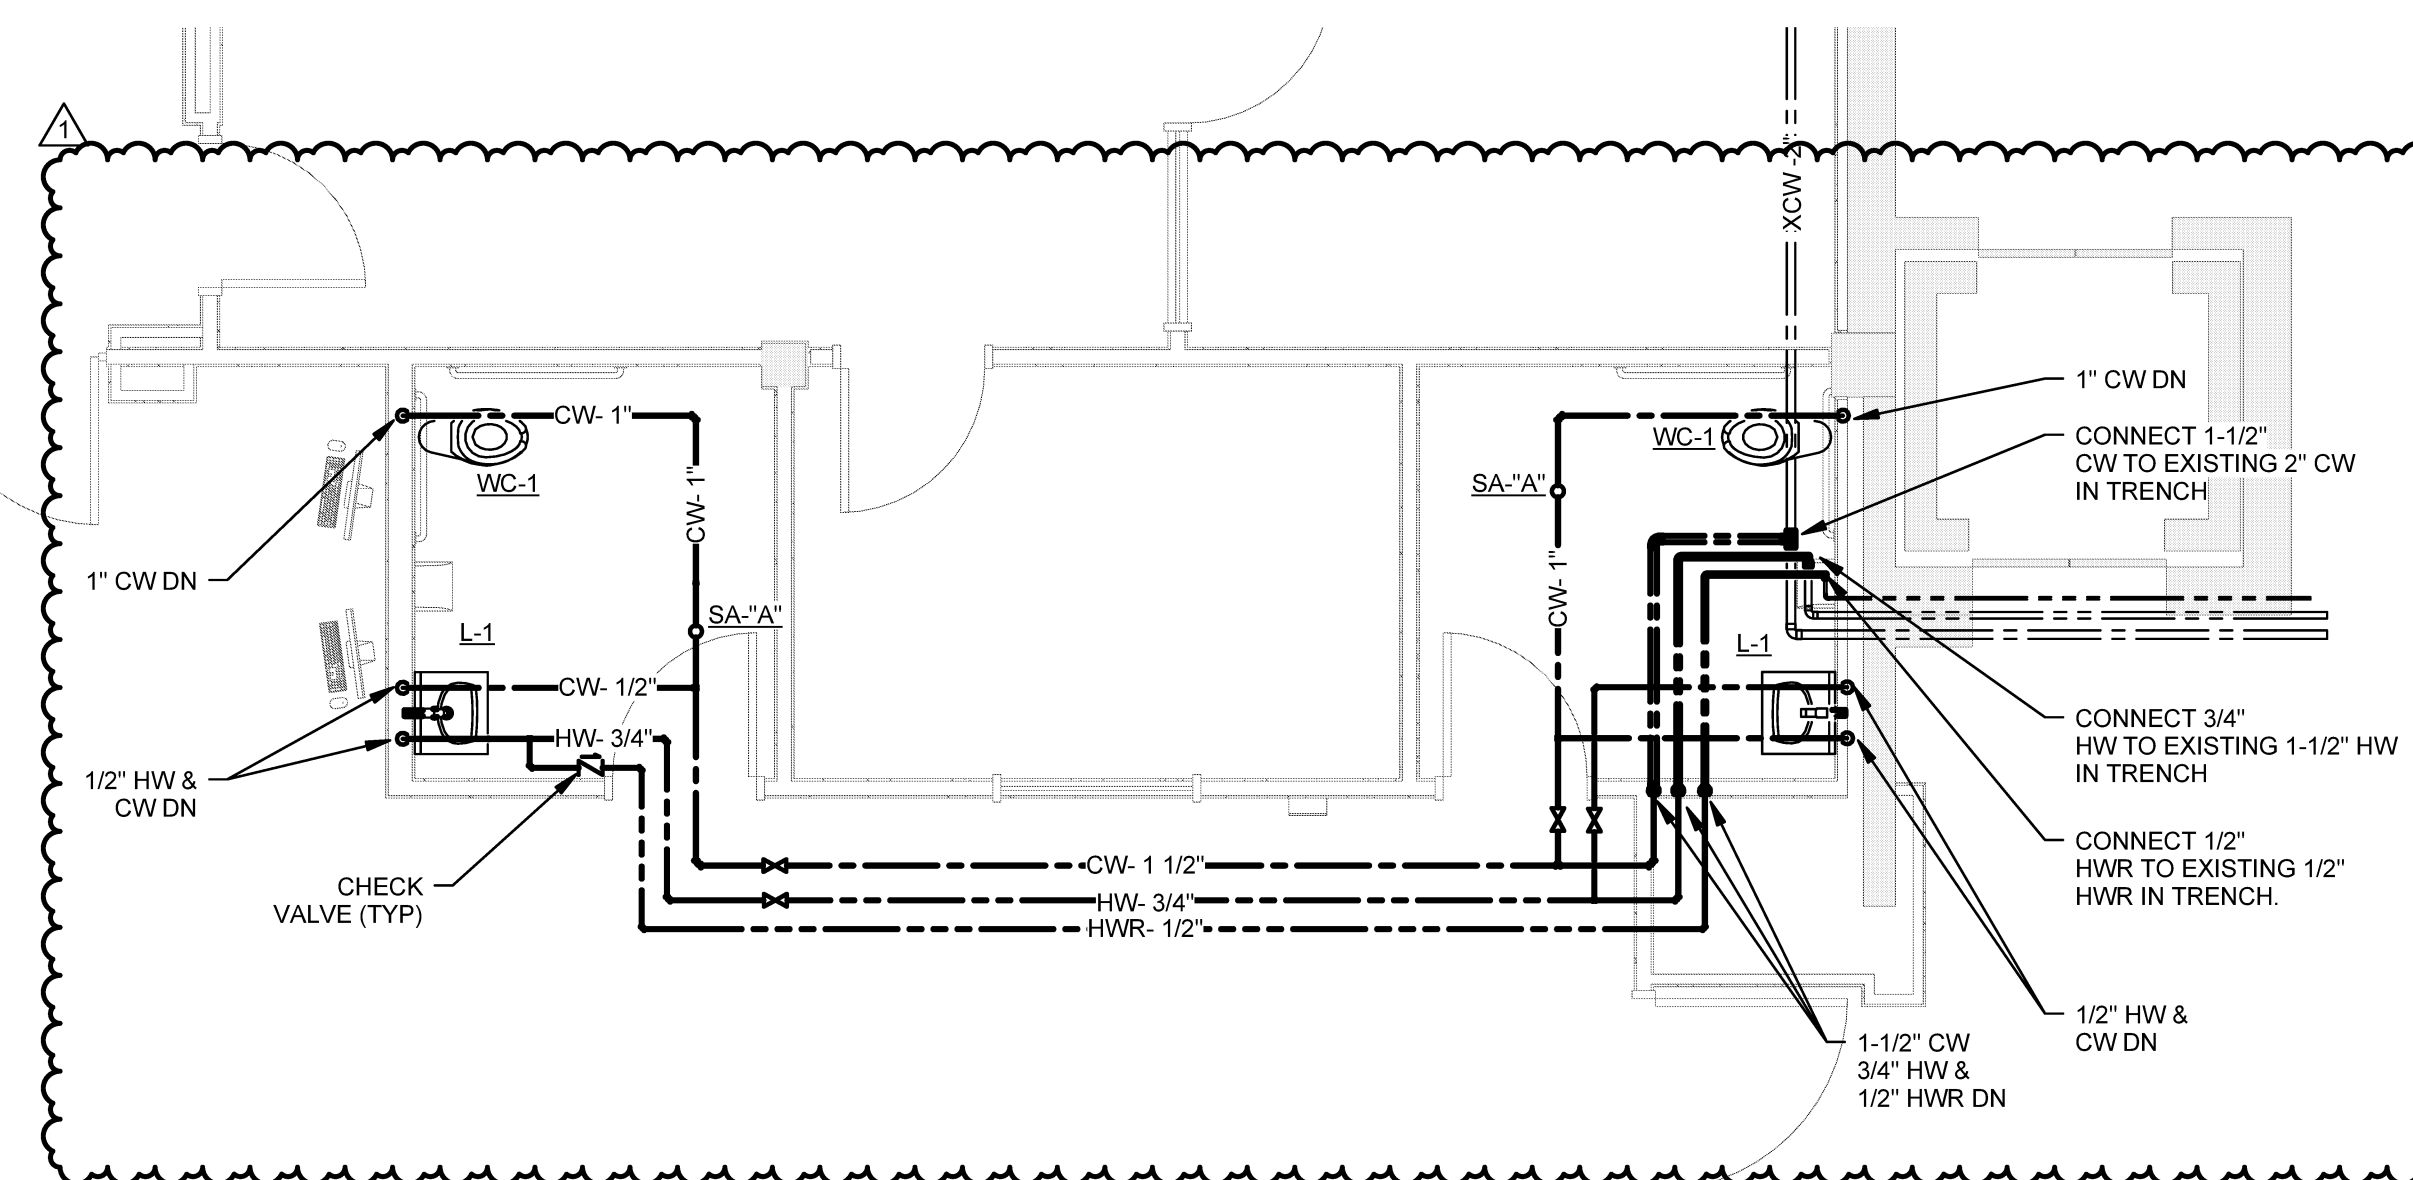

4 ENLARGED SUPPLY PLAN

SCALE: 1/4" = 1'-0"

PLUMBING FIXTURE INSTALLATION SCHEDULE								
FURNISHED AND INSTALLED BY PLUMBING CONTRACTOR								
TAG	DESCRIPTION	BRANCH SIZE				FIXTURE SPECIFICATIONS	SUPPLY FITTING SPECIFICATIONS	MOUNTING HEIGHT
		VENT	WASTE	HW	CW			
WC-1	WATER CLOSET FLOOR MOUNTED	2"	3"	1"	1"	AMERICAN STANDARD MADERA FLOWISE MODEL 3461.001, PROVIDE CHURCH MODEL 9500CT TOILET SEAT	SLOAN ROYAL MODEL 111-1.28	16 1/2"
L-1	LAVATORY	1 1/2"	2"	1/2"	1/2"	AMERICAN STANDARD LUCERNE MODEL 0356.921, PROVIDE TRU BRO LAVATORY GUARD	ZURN MODEL Z81101-17M-XL	34"