
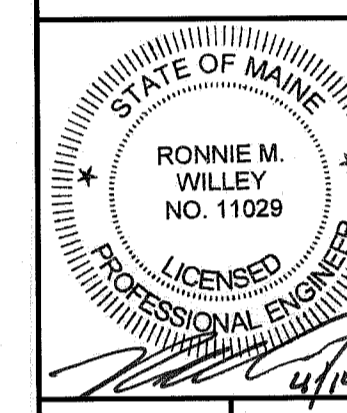
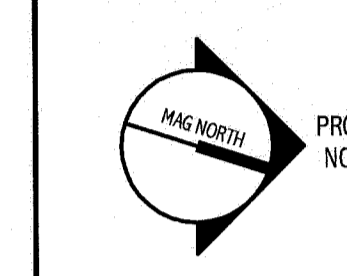


**NOTE:**  
 1. SEE SHEET M-001 FOR LEGEND AND ABBREVIATIONS.

144 Fore Street/P.O. Box 618  
 Portland, Maine 04104  
 Tel: (207) 772-3846  
 Fax: (207) 772-1070  
 www.smartrc.com

ARCHITECTURE  
 ENGINEERING  
 PLANNING  
 INTERIOR DESIGN  
 COMMISSIONING

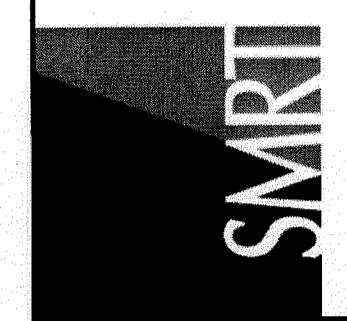



UNIVERSITY OF SOUTHERN MAINE  
 SIMULATION LABORATORY  
 PORTLAND, MAINE  
 ISSUED FOR BIDDING & CONSTRUCTION  
 4-15-11

REV	DESCRIPTION	DATE
0	ISSUED FOR BIDDING, PERMITS & CONSTRUCTION	4-15-11

GRAPHIC SCALE:  
 0" 1"  
 SCALE: 1/4"=1'-0"  
 PROJECT MANAGER: SLB  
 I/C/DRAWN BY: BAL  
 A/E OF RECORD: RMW  
 CAD FILE: MP101-10150  
 PROJECT NO: 10150-00  
 DATE: 4-15-11  
 SHEET TITLE:

FIRST FLOOR HVAC  
 PIPING PLAN

SHEET No.  
**MP101**  
 © COPYRIGHT 2009 SMARTRC INC.

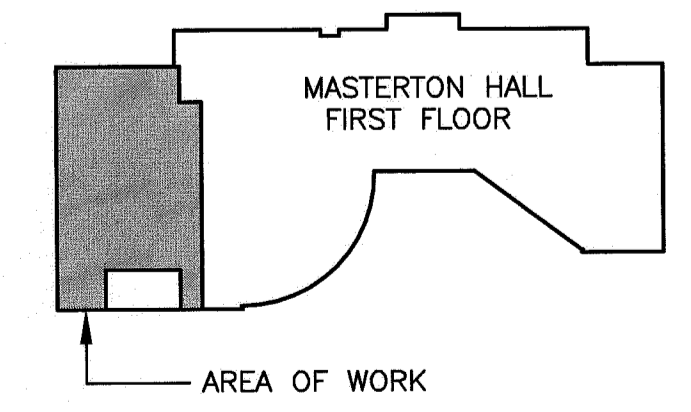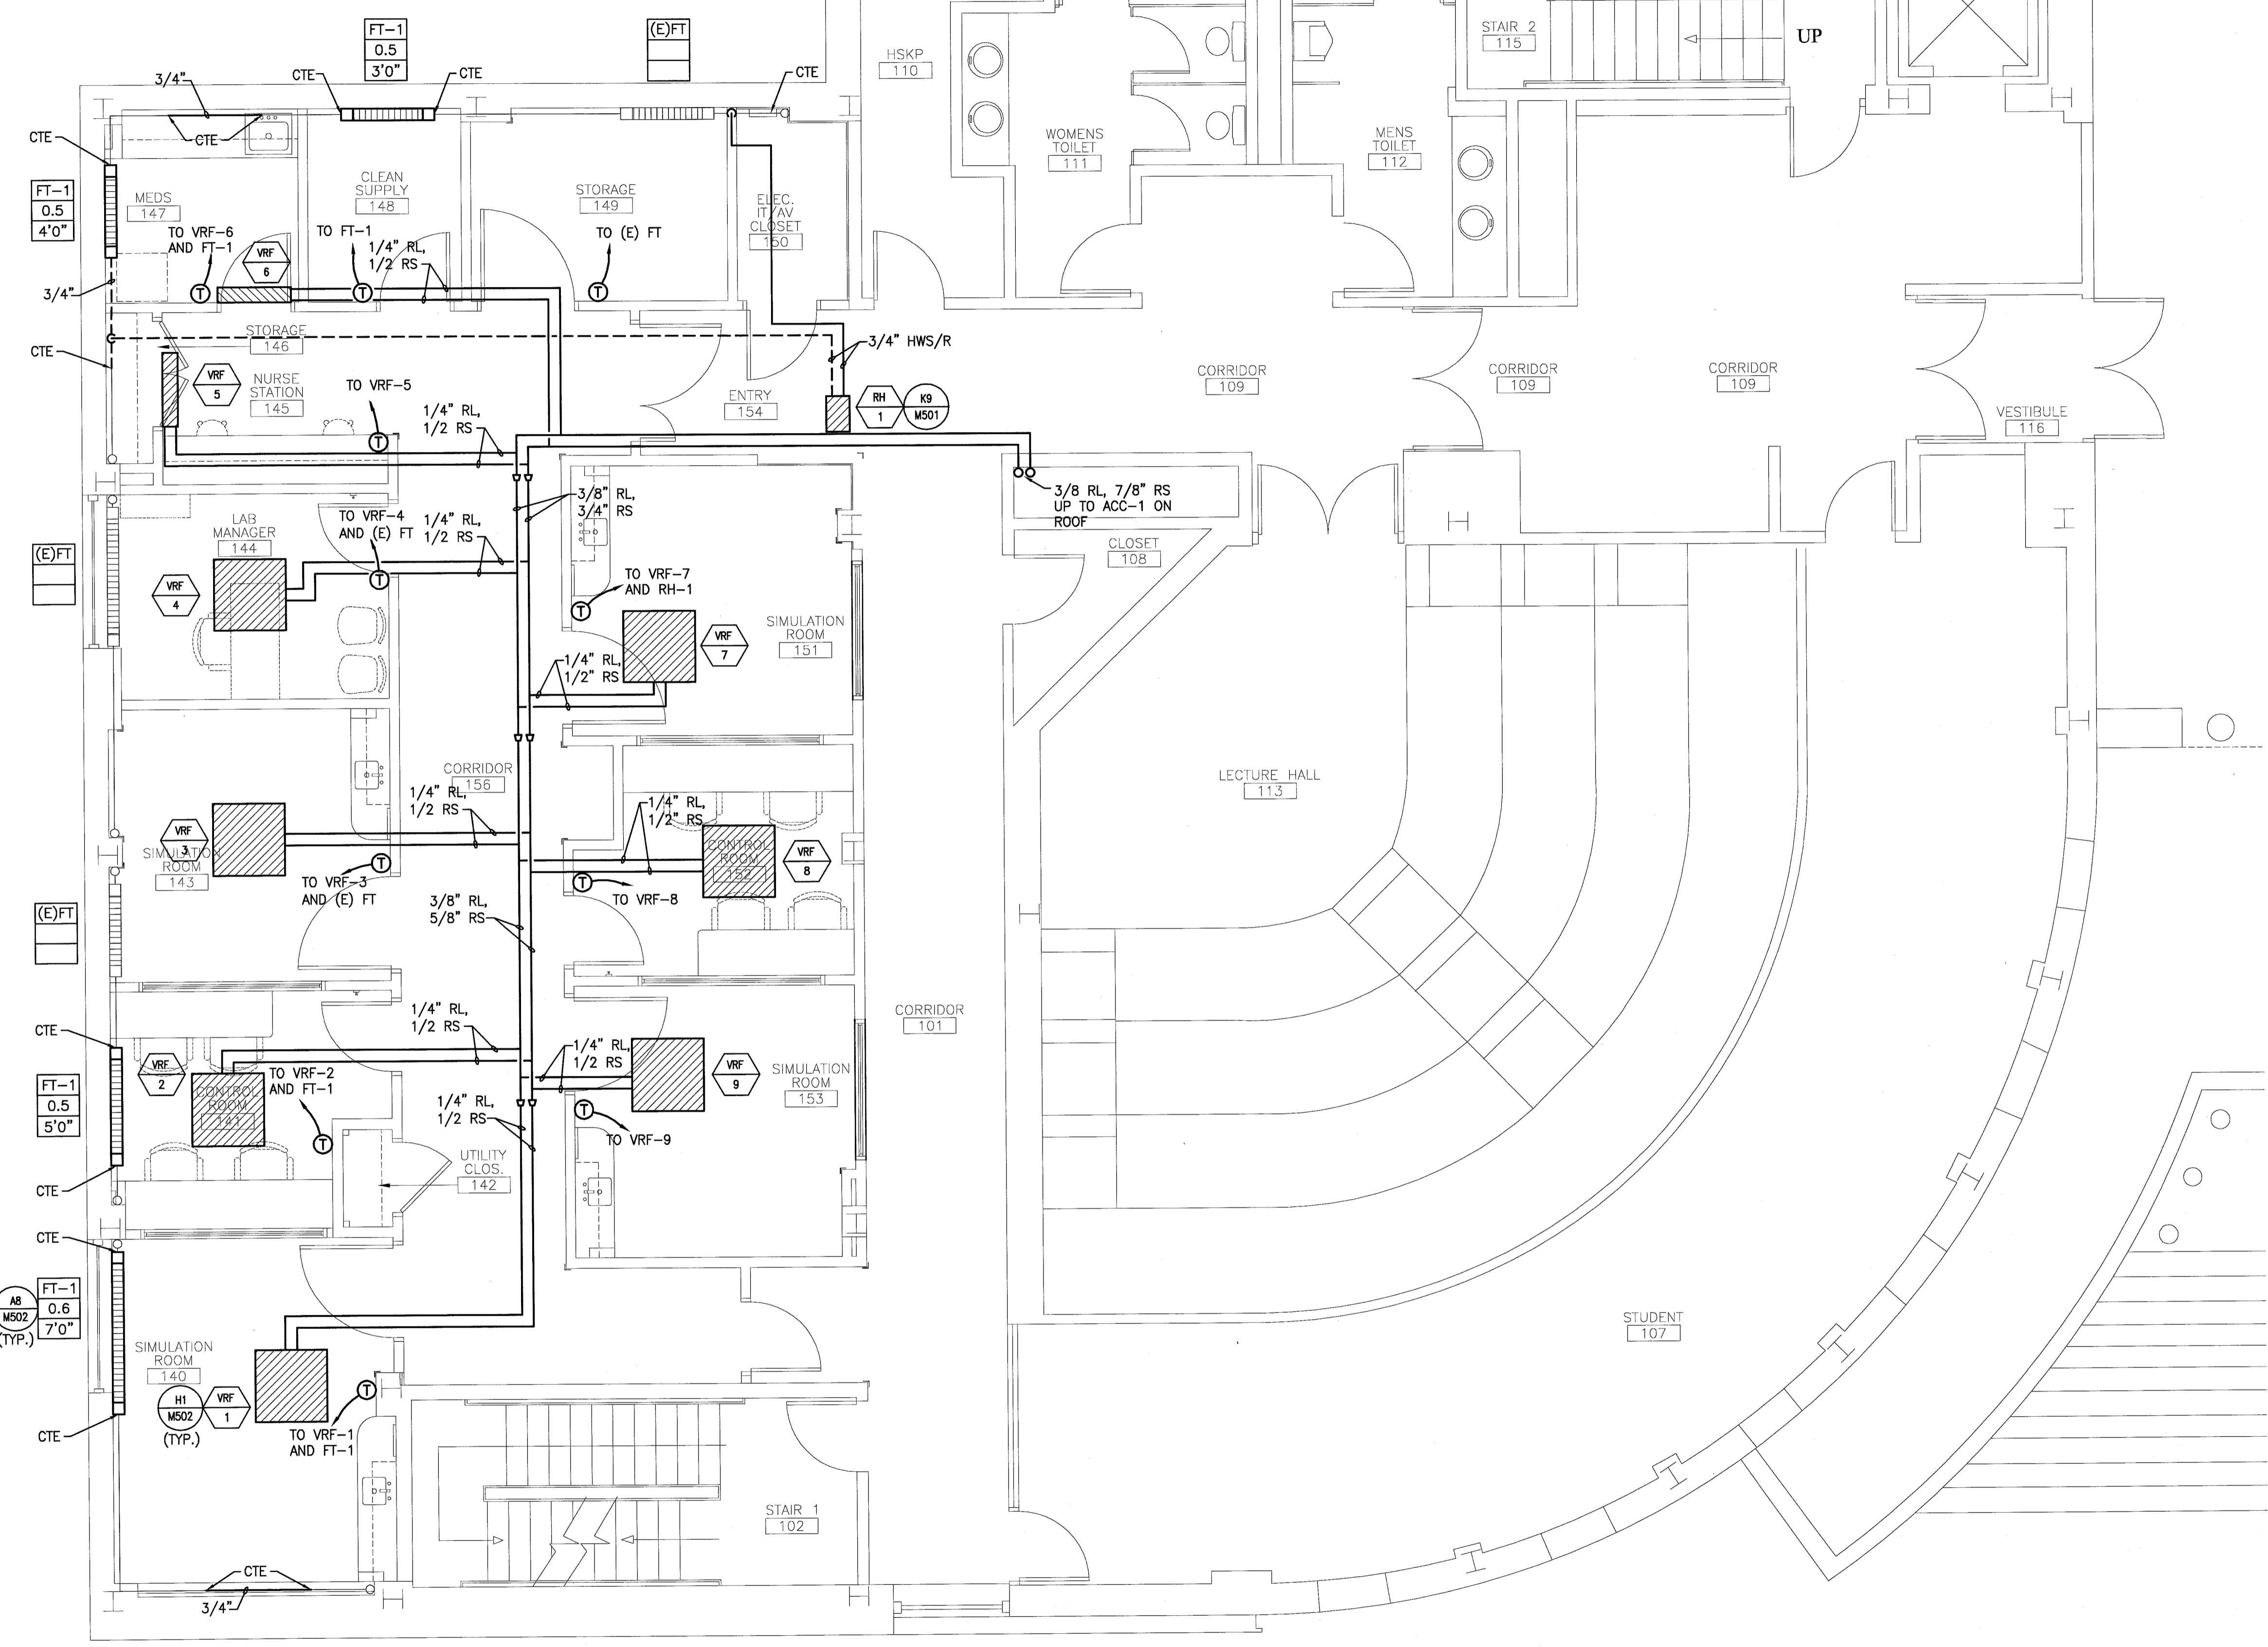

**A1 FIRST FLOOR HVAC PIPING PLAN**

**A14 KEY PLAN**

1/4" = 1'-0"

NTS \*