

NOTE:



- SEE SHEET M-001 FOR LEGEND AND ABBREVIATIONS.
- EXISTING SPRINKLER PIPING AND HEADS TO REMAIN, MODIFY AND REWORK EXISTING SPRINKLER SYSTEM, PER NFPA 13 REQUIREMENTS, TO AVOID CONFLICTS WITH HVAC AND OTHER NEW INSTALLATIONS.

KEYED NOTES:

① 1-1/4" CD FROM CONDENSATE PUMP PROVIDED WITH MECHANICAL EQUIPMENT.

144 Fore Street/P.O. Box 618
Portland, Maine 04104
tel. (207) 772-3846
fax. (207) 772-1070
www.smrtinc.com

ARCHITECTURE
ENGINEERING
PLANNING
INTERIOR DESIGN
COMMISSIONING

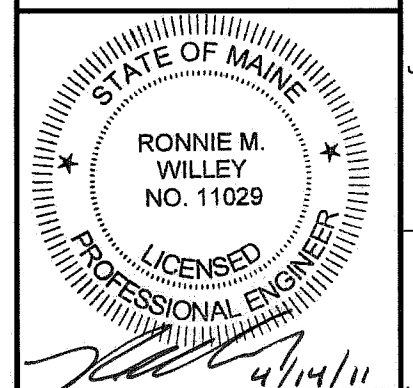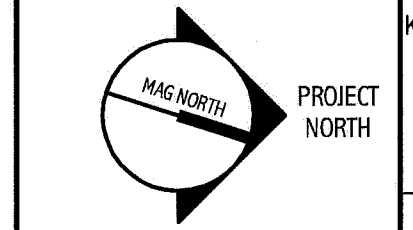

UNIVERSITY OF SOUTHERN MAINE
SIMULATION LABORATORY
PORTLAND, MAINE

ISSUED FOR BIDDING & CONSTRUCTION
4-15-11


CURRENT ISSUE STATUS

REV	DESCRIPTION	DATE
0	ISSUED FOR BIDDING, PERMITTING & CONSTRUCTION	4-15-11

GRAPHIC SCALE:
0" 1"

SCALE: 1/4"=1'-0"

PROJECT MANAGER: SLB
JC/DRAWN BY: BAL
A/E OF RECORD: RMW
CAD FILE: PL103-10150
PROJECT NO: 10150-00
DATE: 4-15-11
SHEET TITLE:

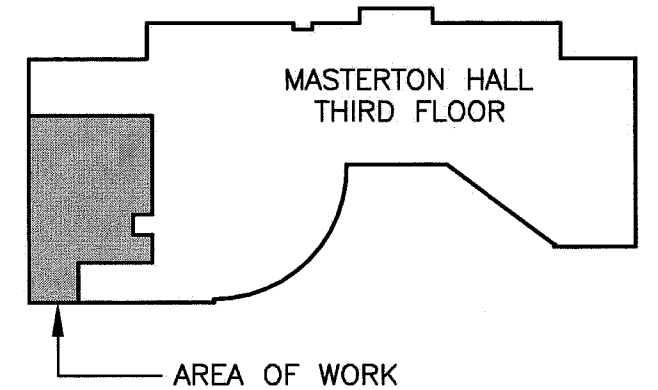

A1 THIRD FLOOR PLUMBING PLAN
1/4" = 1'-0"

A14 KEY PLAN
NTS *

THIRD FLOOR
PLUMBING PLAN
SHEET No.
PL103
© copyright 2009 SMRT INC.